


A

D


H




10		11		12		
REFERENCE						
REFERENCE.TITLE			REFERENCE.NO			
NOTES						
ALL DIMENSIONS ARE IN mm.						
LEGEND						
KEY PLAN						
14	06/10/2026	15TH VERSION OF DRAWINGS	H ZAREIEE	H ZAREIEE	F. ESMAEILZADE	H. REZAIEE
13	05/24/2026	14TH VERSION OF DRAWINGS	H ZAREIEE	H ZAREIEE	F. ESMAEILZADE	H. REZAIEE
12	04/29/2026	13TH VERSION OF DRAWINGS	H ZAREIEE	H ZAREIEE	F. ESMAEILZADE	H. REZAIEE
11	04/11/2026	12TH VERSION OF DRAWINGS	H ZAREIEE	H ZAREIEE	F. ESMAEILZADE	H. REZAIEE
10	02/24/2026	11TH VERSION OF DRAWINGS	H ZAREIEE	H ZAREIEE	F. ESMAEILZADE	H. REZAIEE
09	02/07/2026	10TH VERSION OF DRAWINGS	H ZAREIEE	H ZAREIEE	F. ESMAEILZADE	H. REZAIEE
08	01/25/2026	9TH VERSION OF DRAWINGS	H ZAREIEE	H ZAREIEE	F. ESMAEILZADE	H. REZAIEE
07	01/14/2026	8TH VERSION OF DRAWINGS	H ZAREIEE	H ZAREIEE	F. ESMAEILZADE	H. REZAIEE
06	01/10/2026	7TH VERSION OF DRAWINGS	H ZAREIEE	H ZAREIEE	F. ESMAEILZADE	H. REZAIEE
05	12/28/2025	6TH VERSION OF DRAWINGS	H ZAREIEE	H ZAREIEE	F. ESMAEILZADE	H. REZAIEE
04	12/03/2025	5TH VERSION OF DRAWINGS	H ZAREIEE	H ZAREIEE	F. ESMAEILZADE	H. REZAIEE
03	11/16/2025	4TH VERSION OF DRAWINGS	H ZAREIEE	H ZAREIEE	F. ESMAEILZADE	H. REZAIEE
02	10/16/2025	3TH VERSION OF DRAWINGS	H ZAREIEE	H ZAREIEE	F. ESMAEILZADE	H. REZAIEE
01	08/17/2025	SECOND VERSION OF DRAWINGS	H ZAREIEE	H ZAREIEE	F. ESMAEILZADE	H. REZAIEE
00	07/19/2025	FIRST VERSION OF DRAWINGS	H ZAREIEE	H ZAREIEE	F. ESMAEILZADE	H. REZAIEE
REV.	DATE	DESCRIPTION	DESIGN	DRAWN	CHECKED	APPROVED
Client:			Consultant:			
 شرکت ملی صنایع مسکن ایران NICICO			 موتنکو ایران Monenco Iran			
			Contractor:		Sub Contractor:	
			 گروه مهام شرق			
Project: 100MW Solar Power Plant (SARCHESHME)						
Title: PLOT PLAN						
DOC NO.:	28P2-B-3MG-DWG-SOL-000000-ST-330				REV. 14	
SCALE		SIZE	SHEET		FORMAT	
FIT		A3	02/26		DWC	

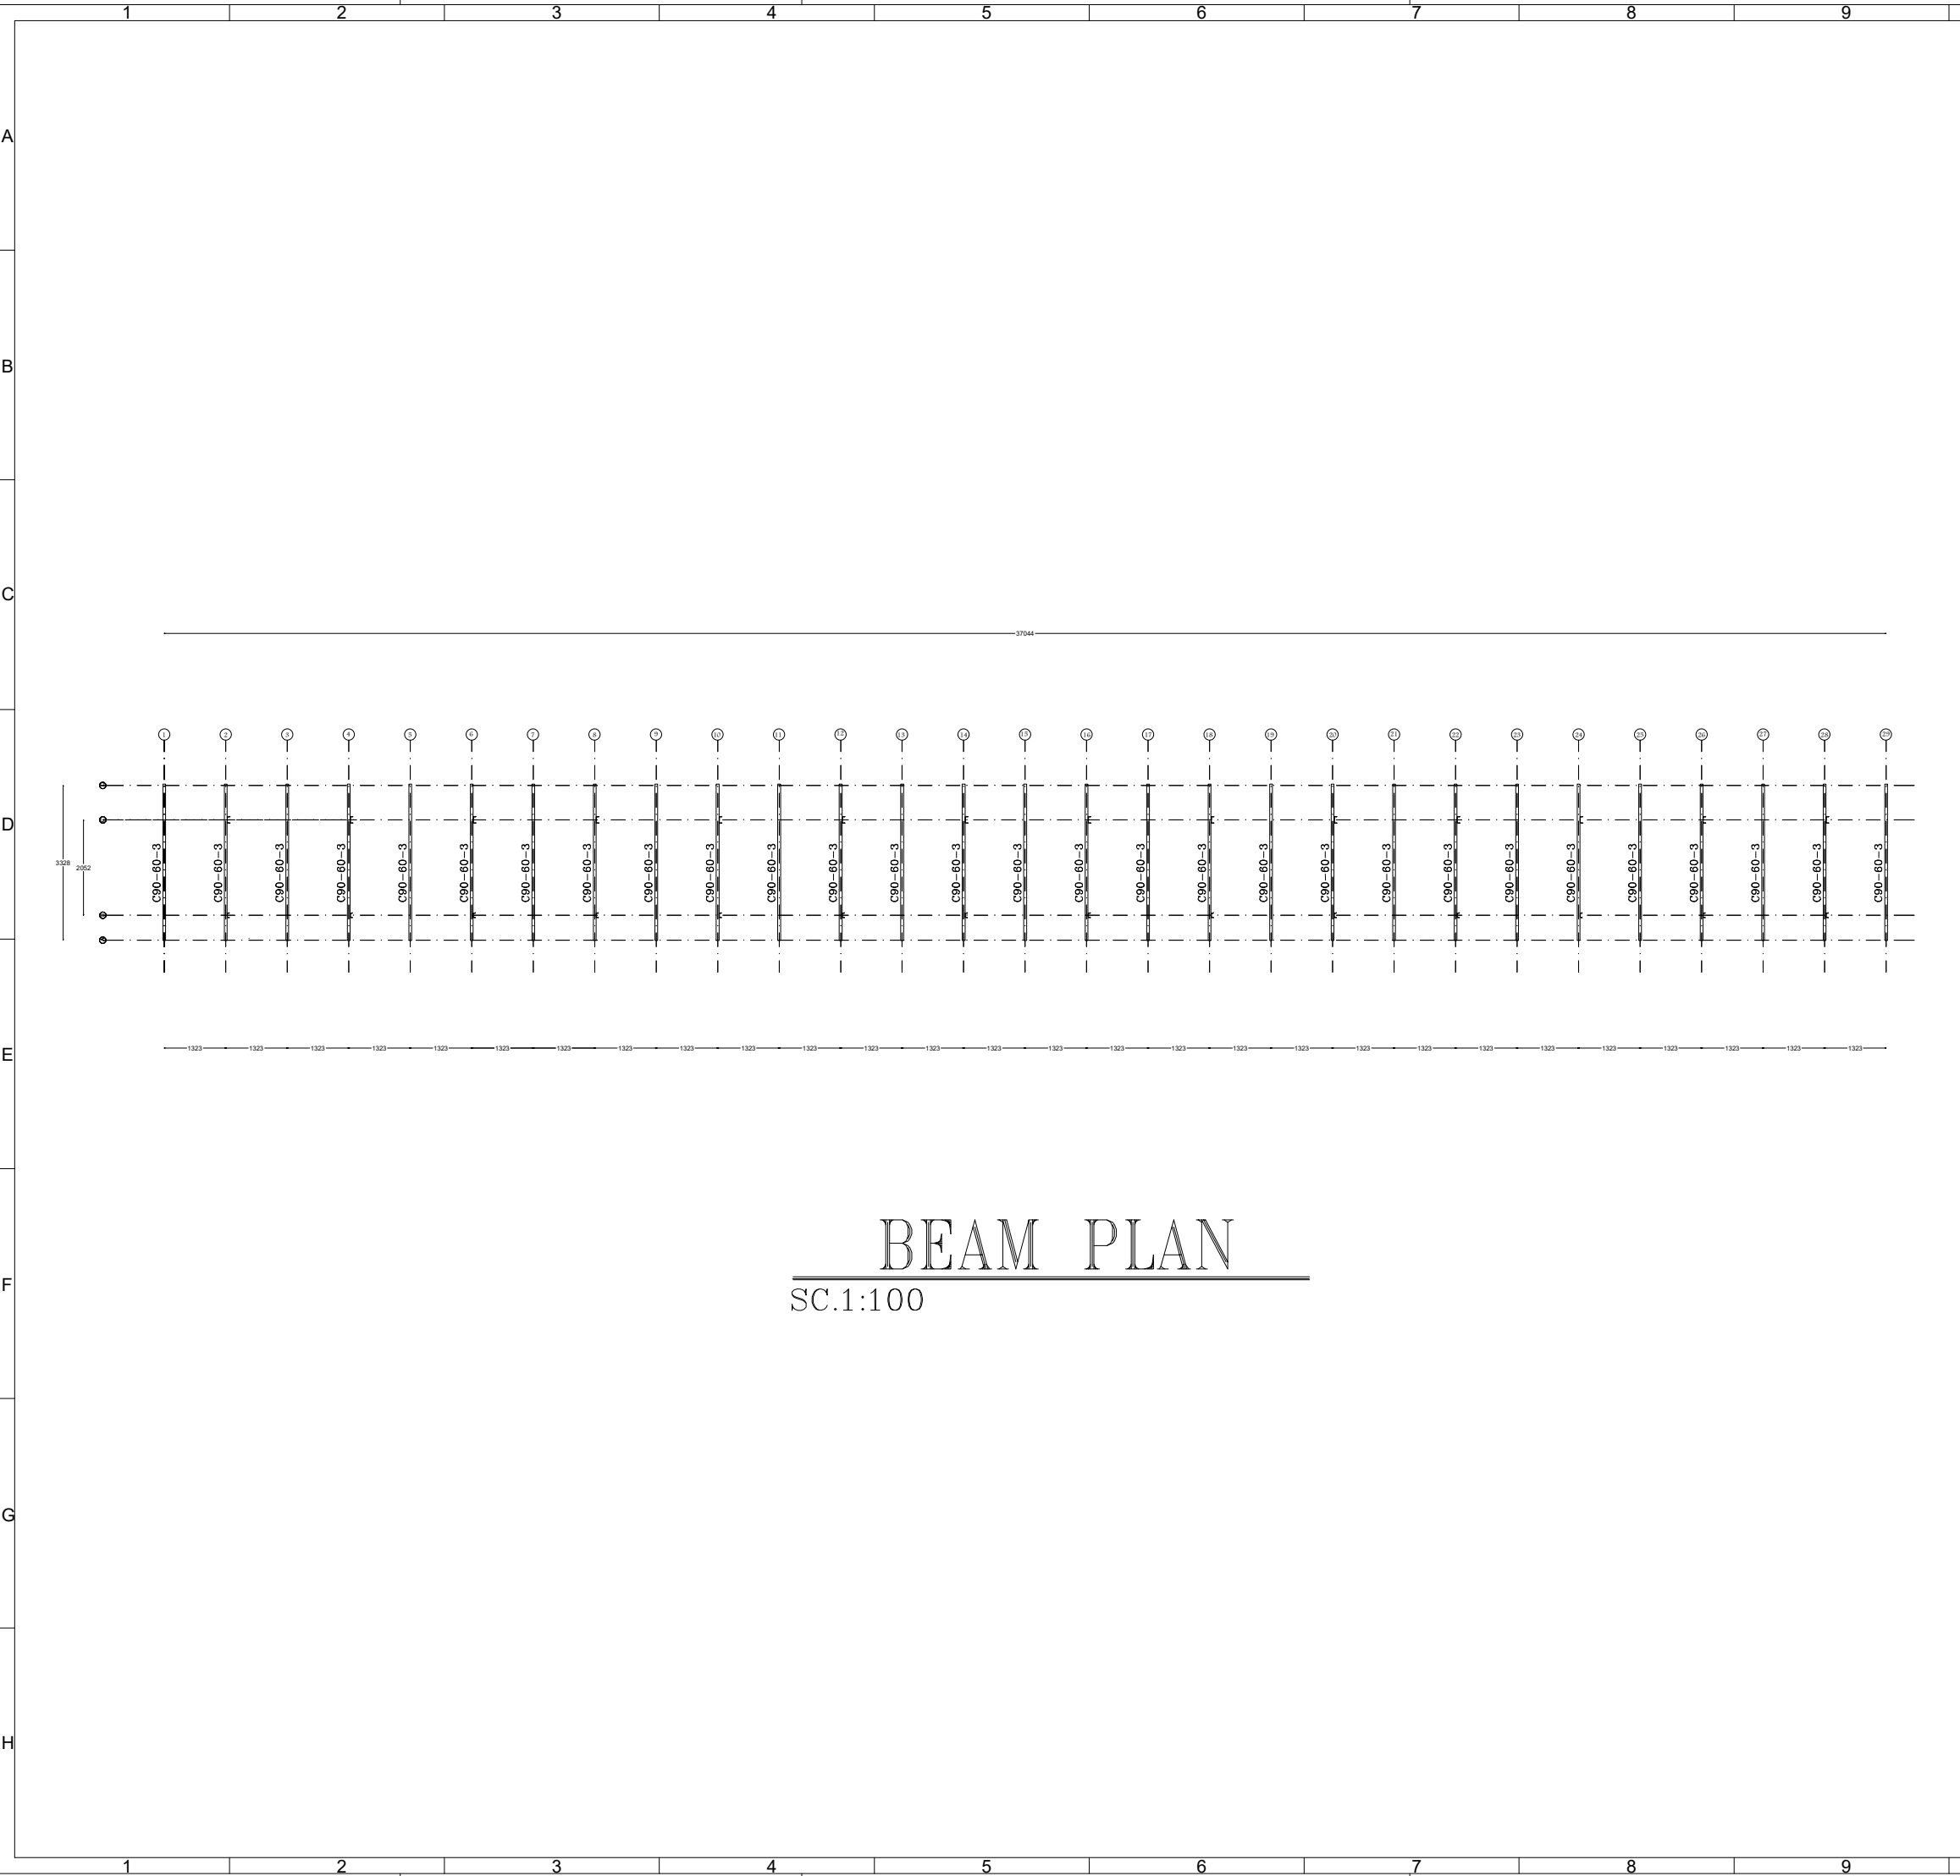

10		11		12	
REFERENCE					
REFERENCE.TITLE			REFERENCE.NO .		
NOTES					
ALL DIMENSIONS ARE IN mm.					
LEGEND					
KEY PLAN					
14	06/10/2026	15TH VERSION OF DRAWINGS	H ZAREIEE	H ZAREIEE	F. ESMAEILZADE H. REZAEIE
13	05/24/2026	14TH VERSION OF DRAWINGS	H ZAREIEE	H ZAREIEE	F. ESMAEILZADE H. REZAEIE
12	04/29/2026	13TH VERSION OF DRAWINGS	H ZAREIEE	H ZAREIEE	F. ESMAEILZADE H. REZAEIE
11	04/11/2026	12TH VERSION OF DRAWINGS	H ZAREIEE	H ZAREIEE	F. ESMAEILZADE H. REZAEIE
10	02/24/2026	11TH VERSION OF DRAWINGS	H ZAREIEE	H ZAREIEE	F. ESMAEILZADE H. REZAEIE
09	02/07/2026	10TH VERSION OF DRAWINGS	H ZAREIEE	H ZAREIEE	F. ESMAEILZADE H. REZAEIE
08	01/25/2026	9TH VERSION OF DRAWINGS	H ZAREIEE	H ZAREIEE	F. ESMAEILZADE H. REZAEIE
07	01/14/2026	8TH VERSION OF DRAWINGS	H ZAREIEE	H ZAREIEE	F. ESMAEILZADE H. REZAEIE
06	01/10/2026	7TH VERSION OF DRAWINGS	H ZAREIEE	H ZAREIEE	F. ESMAEILZADE H. REZAEIE
05	12/28/2025	6TH VERSION OF DRAWINGS	H ZAREIEE	H ZAREIEE	F. ESMAEILZADE H. REZAEIE
04	12/03/2025	5TH VERSION OF DRAWINGS	H ZAREIEE	H ZAREIEE	F. ESMAEILZADE H. REZAEIE
03	11/16/2025	4TH VERSION OF DRAWINGS	H ZAREIEE	H ZAREIEE	F. ESMAEILZADE H. REZAEIE
02	10/16/2025	3TH VERSION OF DRAWINGS	H ZAREIEE	H ZAREIEE	F. ESMAEILZADE H. REZAEIE
01	08/17/2025	SECOND VERSION OF DRAWINGS	H ZAREIEE	H ZAREIEE	F. ESMAEILZADE H. REZAEIE
00	07/19/2025	FIRST VERSION OF DRAWINGS	H ZAREIEE	H ZAREIEE	F. ESMAEILZADE H. REZAEIE
REV.	DATE	DESCRIPTION	DESIGN	DRAWN	CHECKED APPROVED
Client:			Consultant:		
 NICICO			 موندکو ایران Monenco Iran		
			Contractor:		
			 گروه مهام شرقی		
			Sub Contractor:		
Project: 100MW Solar Power Plant (SARCHESHME)					
Title: Module Arrangement on Table					
DOC NO.:		28P2-B-3MG-DWC-SOL-000000-ST-330			REV. 14
SCALE		SIZE	SHEET		FORMAT
FIT		A3	03/26		DWG
10		11		12	

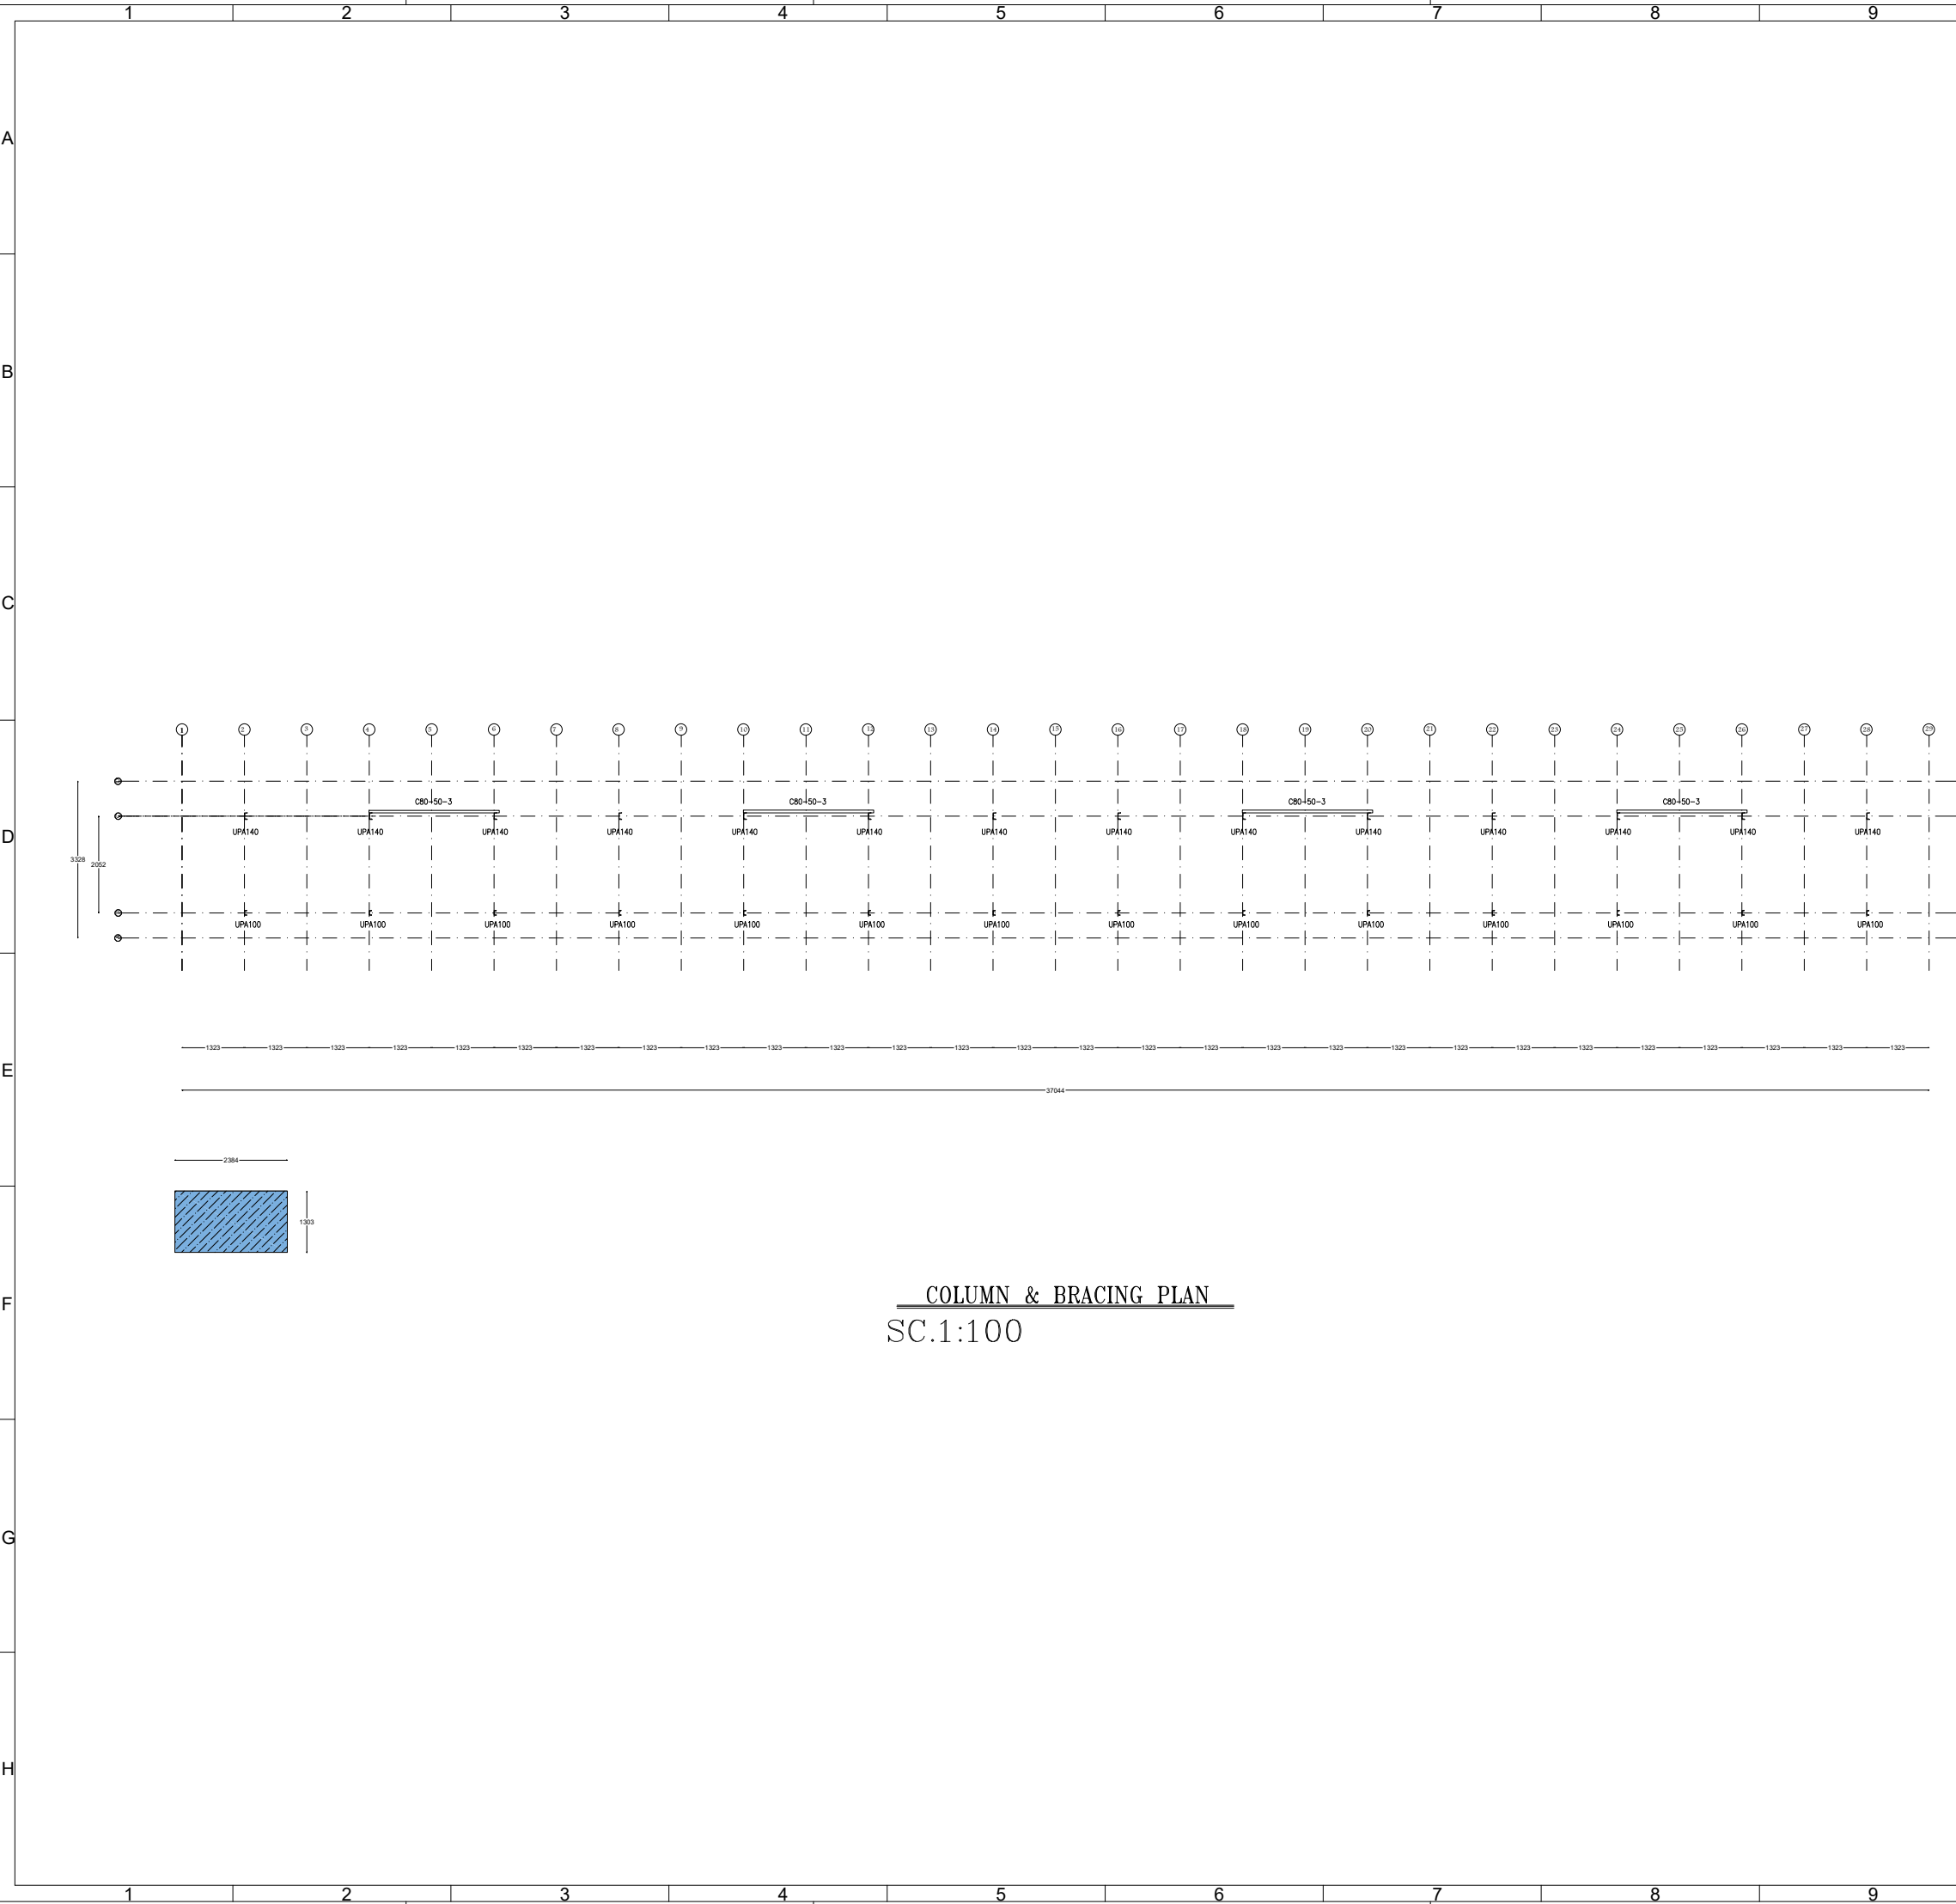

REFERENCE						
REFERENCE.TITLE			REFERENCE.NO .			
NOTES						
ALL DIMENSIONS ARE IN mm.						
LEGEND						
KEY PLAN						
14	06/10/2026	15TH VERSION OF DRAWINGS	H ZAREIEE	H ZAREIEE	F. ESMAEILZADE	H. REZAEIEE
13	05/24/2026	14TH VERSION OF DRAWINGS	H ZAREIEE	H ZAREIEE	F. ESMAEILZADE	H. REZAEIEE
12	04/29/2026	13TH VERSION OF DRAWINGS	H ZAREIEE	H ZAREIEE	F. ESMAEILZADE	H. REZAEIEE
11	04/11/2026	12TH VERSION OF DRAWINGS	H ZAREIEE	H ZAREIEE	F. ESMAEILZADE	H. REZAEIEE
10	02/24/2026	11TH VERSION OF DRAWINGS	H ZAREIEE	H ZAREIEE	F. ESMAEILZADE	H. REZAEIEE
09	02/07/2026	10TH VERSION OF DRAWINGS	H ZAREIEE	H ZAREIEE	F. ESMAEILZADE	H. REZAEIEE
08	01/25/2026	9TH VERSION OF DRAWINGS	H ZAREIEE	H ZAREIEE	F. ESMAEILZADE	H. REZAEIEE
07	01/14/2026	8TH VERSION OF DRAWINGS	H ZAREIEE	H ZAREIEE	F. ESMAEILZADE	H. REZAEIEE
06	01/10/2026	7TH VERSION OF DRAWINGS	H ZAREIEE	H ZAREIEE	F. ESMAEILZADE	H. REZAEIEE
05	12/28/2025	6TH VERSION OF DRAWINGS	H ZAREIEE	H ZAREIEE	F. ESMAEILZADE	H. REZAEIEE
04	12/03/2025	5TH VERSION OF DRAWINGS	H ZAREIEE	H ZAREIEE	F. ESMAEILZADE	H. REZAEIEE
03	11/16/2025	4TH VERSION OF DRAWINGS	H ZAREIEE	H ZAREIEE	F. ESMAEILZADE	H. REZAEIEE
02	10/16/2025	3TH VERSION OF DRAWINGS	H ZAREIEE	H ZAREIEE	F. ESMAEILZADE	H. REZAEIEE
01	08/17/2025	SECOND VERSION OF DRAWINGS	H ZAREIEE	H ZAREIEE	F. ESMAEILZADE	H. REZAEIEE
00	07/19/2025	FIRST VERSION OF DRAWINGS	H ZAREIEE	H ZAREIEE	F. ESMAEILZADE	H. REZAEIEE
REV.	DATE	DESCRIPTION	DESIGN	DRAWN	CHECKED	APPROVED
Client:			Consultant:			
						
			Contractor:		Sub Contractor:	
						
Project: 100MW Solar Power Plant (SARCHESHME)						
Title: Ramming Details & Location						
DOC NO.:		28P2-B-3MG-DWC-SOL-000000-ST-330				REV. 14
SCALE		SIZE		SHEET		FORMAT
FIT		A3		04/26		DWG

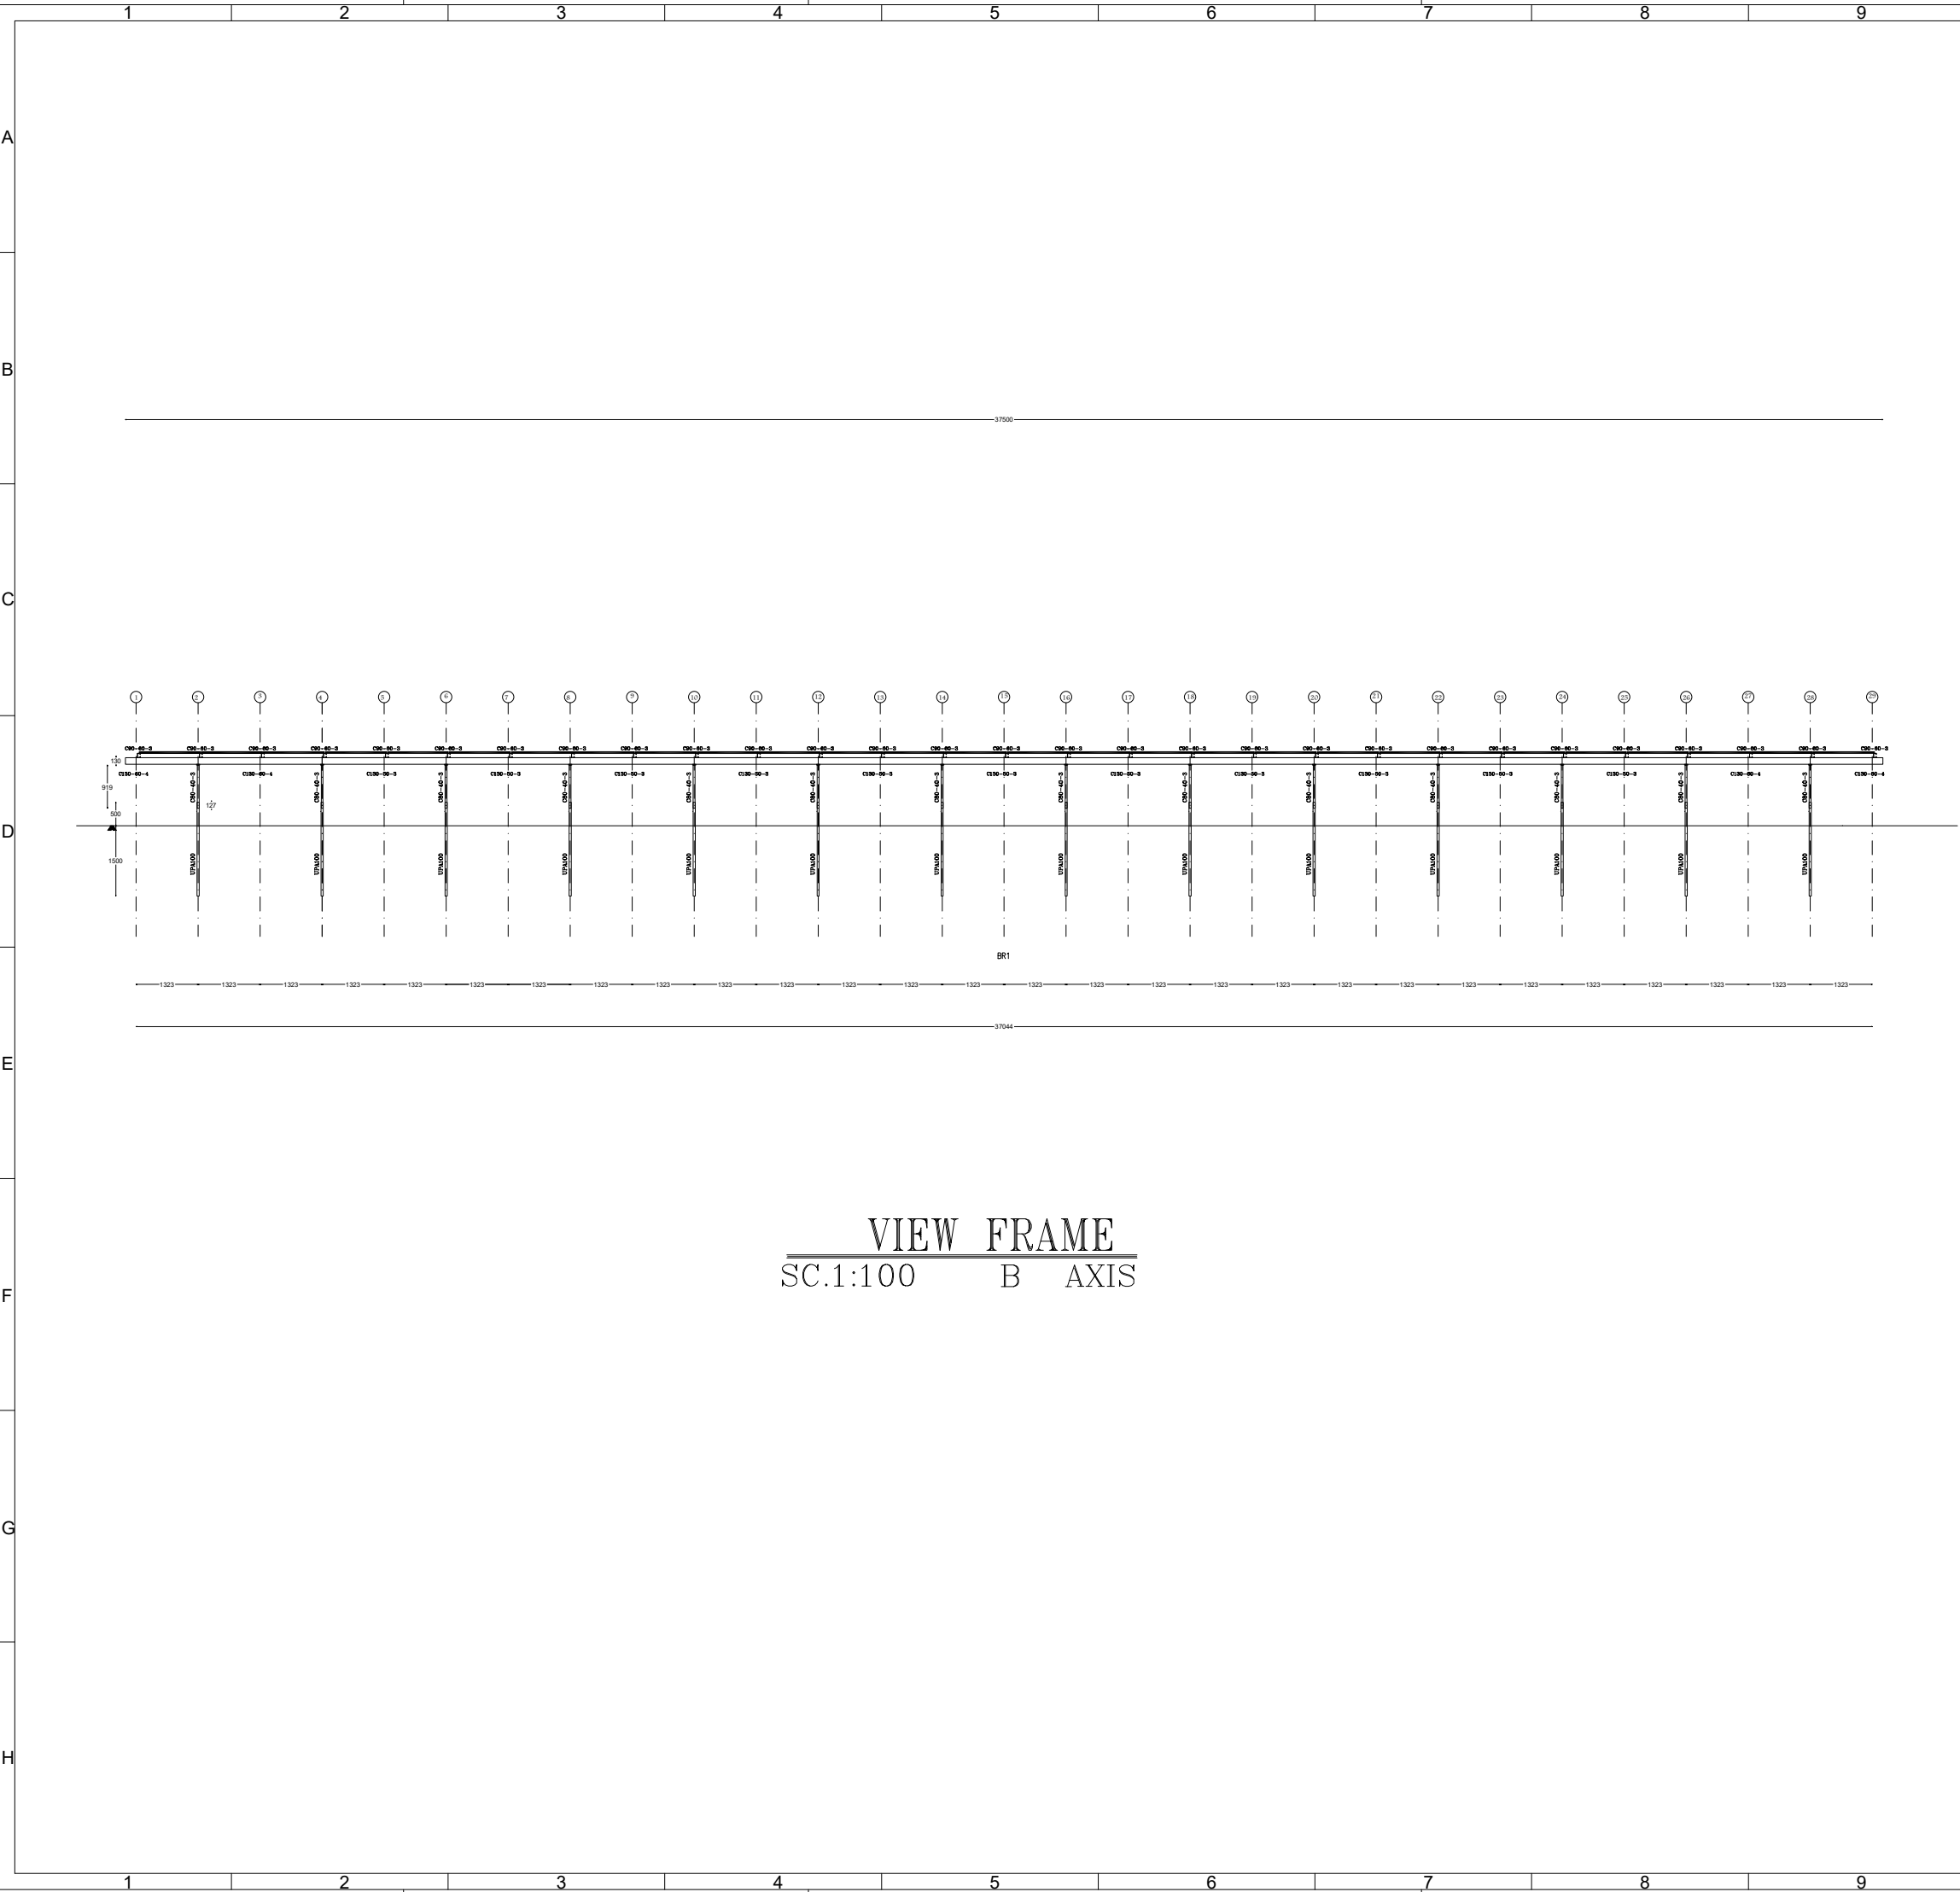

REFERENCE

REFERENCE.TITLE	REFERENCE.NO .

NOTES

ALL DIMENSIONS ARE IN mm.

LEGEND

KEY PLAN

14	06/10/2026	15TH VERSION OF DRAWINGS	H ZAREIEE	H ZAREIEE	F. ESMAEILZADE	H. REZAIEE
13	05/24/2026	14TH VERSION OF DRAWINGS	H ZAREIEE	H ZAREIEE	F. ESMAEILZADE	H. REZAIEE
12	04/29/2026	13TH VERSION OF DRAWINGS	H ZAREIEE	H ZAREIEE	F. ESMAEILZADE	H. REZAIEE
11	04/11/2026	12TH VERSION OF DRAWINGS	H ZAREIEE	H ZAREIEE	F. ESMAEILZADE	H. REZAIEE
10	02/24/2026	11TH VERSION OF DRAWINGS	H ZAREIEE	H ZAREIEE	F. ESMAEILZADE	H. REZAIEE
09	02/07/2026	10TH VERSION OF DRAWINGS	H ZAREIEE	H ZAREIEE	F. ESMAEILZADE	H. REZAIEE
08	01/25/2026	9TH VERSION OF DRAWINGS	H ZAREIEE	H ZAREIEE	F. ESMAEILZADE	H. REZAIEE
07	01/14/2026	8TH VERSION OF DRAWINGS	H ZAREIEE	H ZAREIEE	F. ESMAEILZADE	H. REZAIEE
06	01/10/2026	7TH VERSION OF DRAWINGS	H ZAREIEE	H ZAREIEE	F. ESMAEILZADE	H. REZAIEE
05	12/28/2025	6TH VERSION OF DRAWINGS	H ZAREIEE	H ZAREIEE	F. ESMAEILZADE	H. REZAIEE
04	12/03/2025	5TH VERSION OF DRAWINGS	H ZAREIEE	H ZAREIEE	F. ESMAEILZADE	H. REZAIEE
03	11/16/2025	4TH VERSION OF DRAWINGS	H ZAREIEE	H ZAREIEE	F. ESMAEILZADE	H. REZAIEE
02	10/16/2025	3TH VERSION OF DRAWINGS	H ZAREIEE	H ZAREIEE	F. ESMAEILZADE	H. REZAIEE
01	08/17/2025	SECOND VERSION OF DRAWINGS	H ZAREIEE	H ZAREIEE	F. ESMAEILZADE	H. REZAIEE
00	07/19/2025	FIRST VERSION OF DRAWINGS	H ZAREIEE	H ZAREIEE	F. ESMAEILZADE	H. REZAIEE
REV.	DATE	DESCRIPTION	DESIGN	DRAWN	CHECKED	APPROVED

Client:



Consultant:

موننکو ایران
Monenco Iran



Contractor:




Sub Contractor:


Project: 100MW Solar Power Plant (SARCHESHME)

Title: Modeling File

DOC NO.:	28P2-B-3MG-DWC-SOL-000000-ST-330	REV.	
		14	
SCALE	SIZE	SHEET	FORMAT
FIT	A3	05/26	DWC

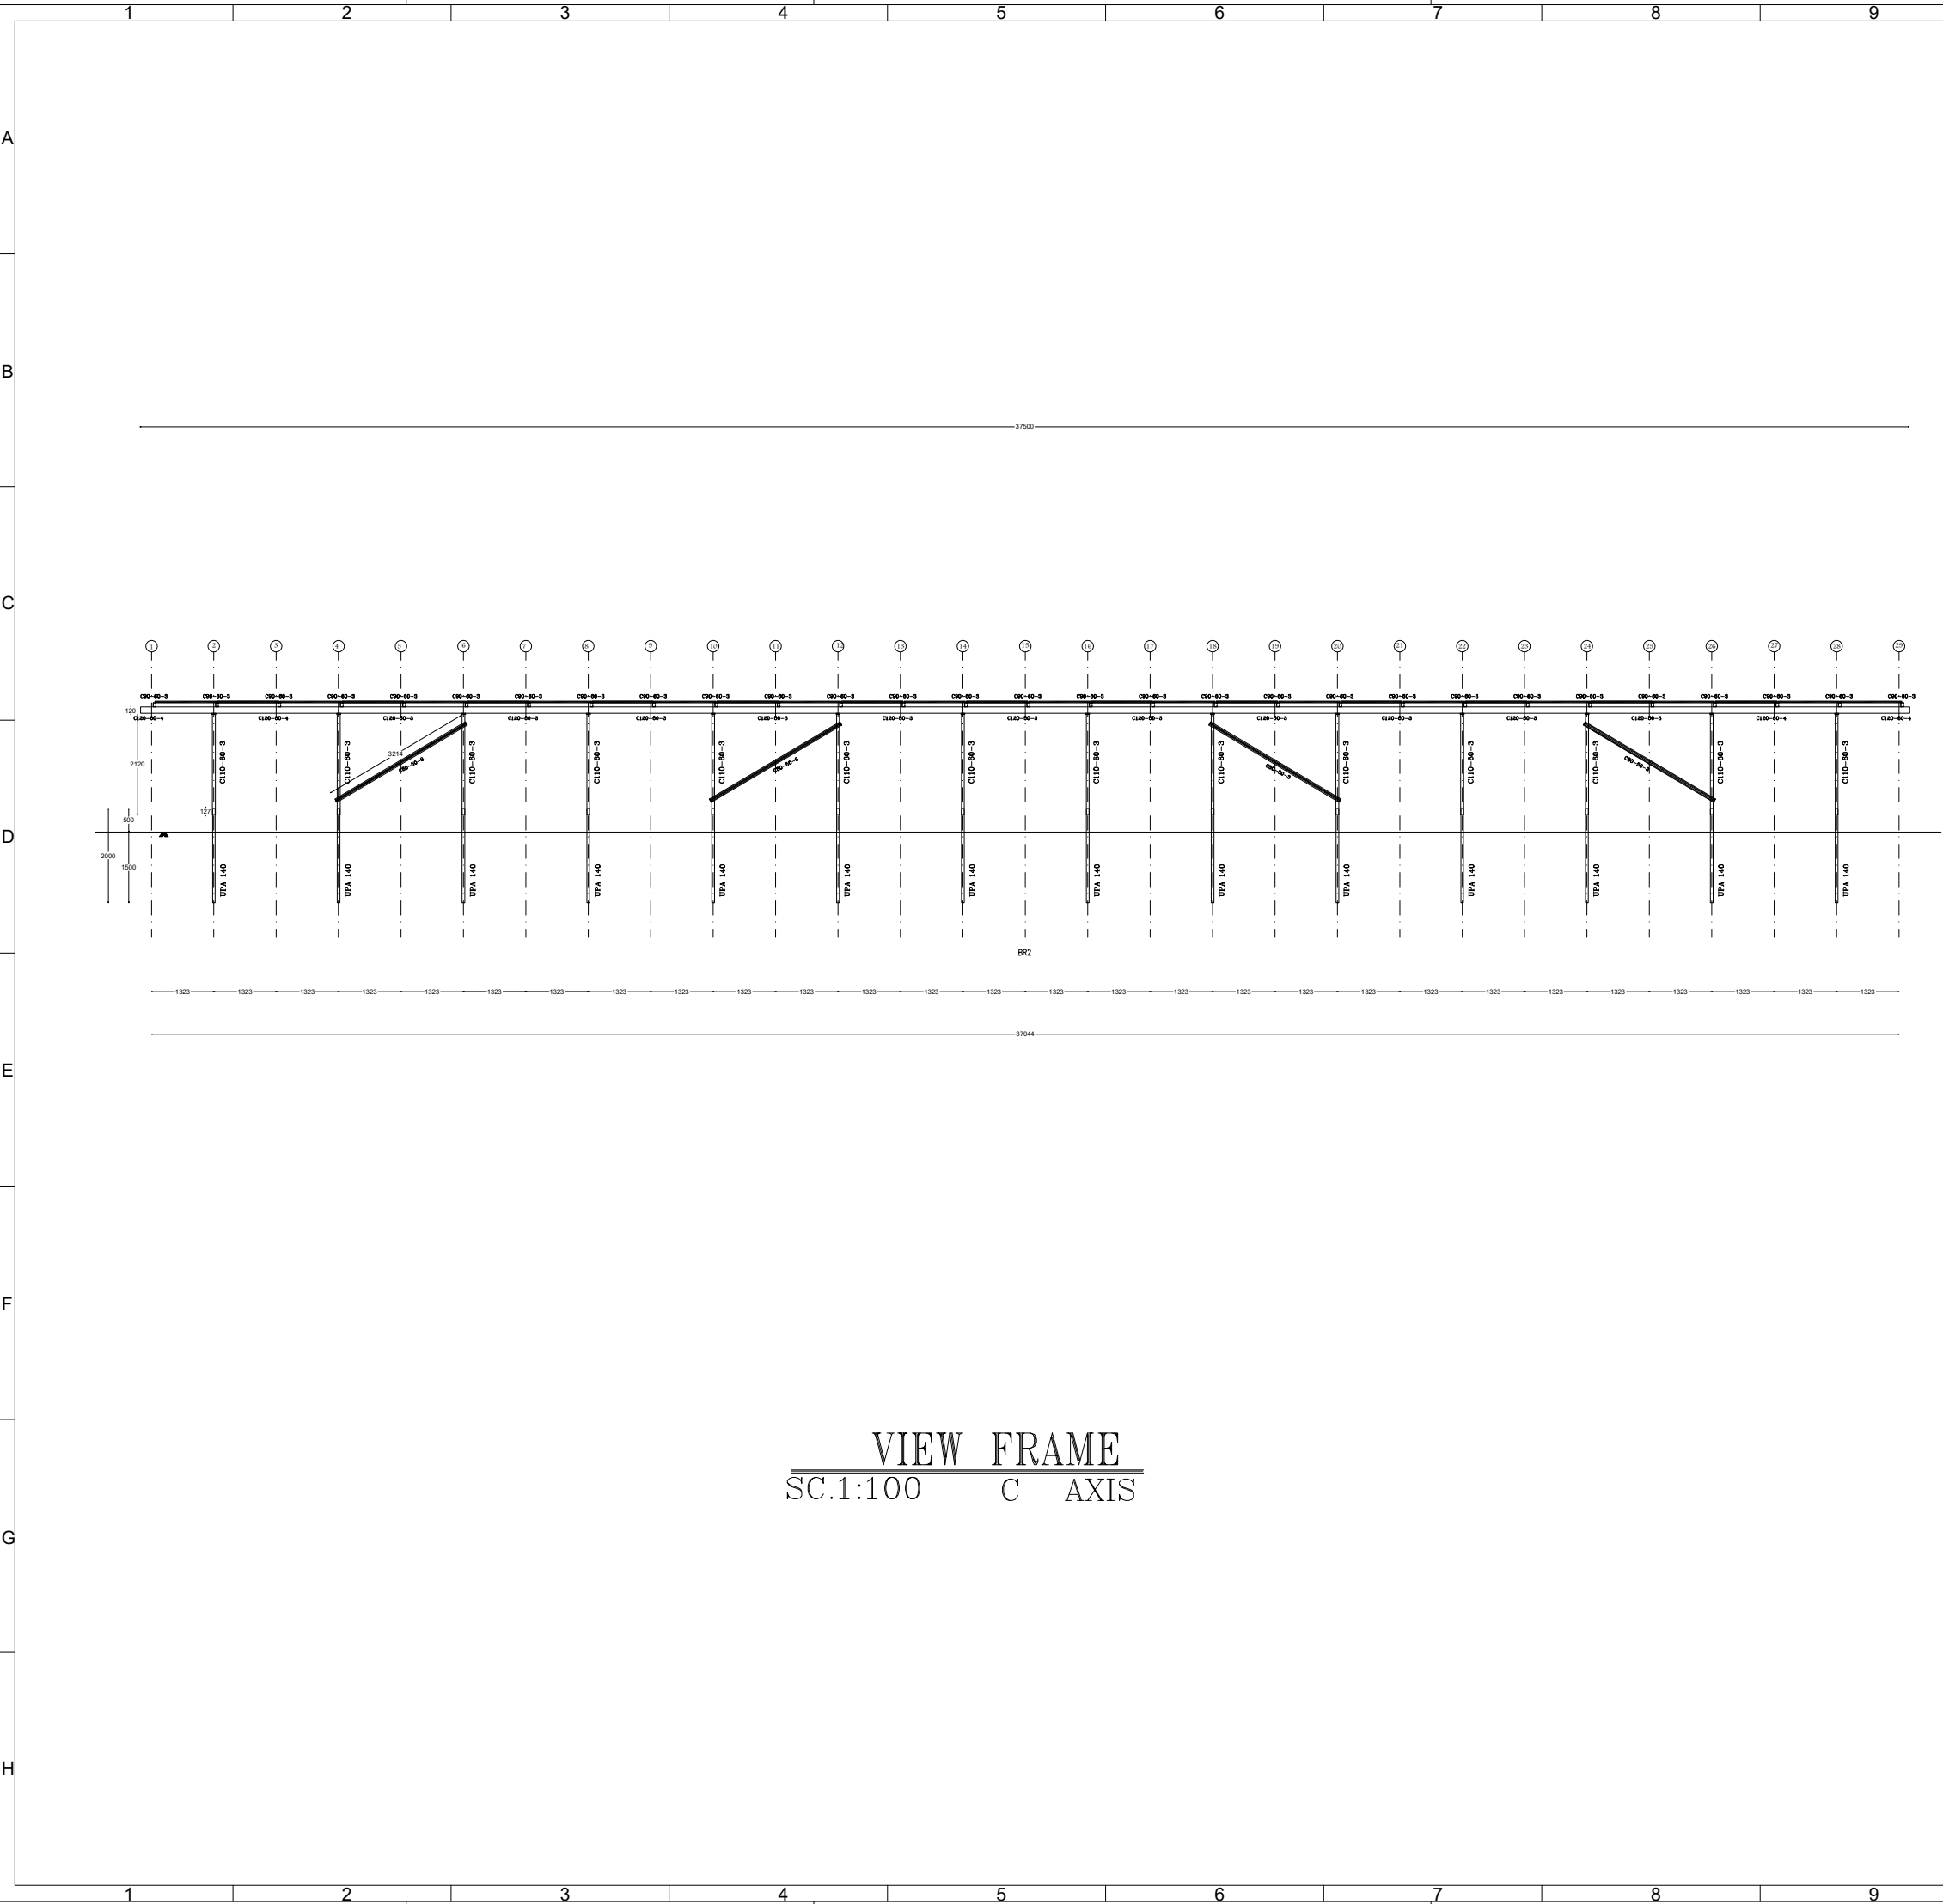

REFERENCE						
REFERENCE.TITLE			REFERENCE.NO .			
NOTES						
ALL DIMENSIONS ARE IN mm.						
LEGEND						
KEY PLAN						
14	06/10/2026	15TH VERSION OF DRAWINGS	H ZAREIEE	H ZAREIEE	F. ESMAEILZADE	H. REZAIIEE
13	05/24/2026	14TH VERSION OF DRAWINGS	H ZAREIEE	H ZAREIEE	F. ESMAEILZADE	H. REZAIIEE
12	04/29/2026	13TH VERSION OF DRAWINGS	H ZAREIEE	H ZAREIEE	F. ESMAEILZADE	H. REZAIIEE
11	04/11/2026	12TH VERSION OF DRAWINGS	H ZAREIEE	H ZAREIEE	F. ESMAEILZADE	H. REZAIIEE
10	02/24/2026	11TH VERSION OF DRAWINGS	H ZAREIEE	H ZAREIEE	F. ESMAEILZADE	H. REZAIIEE
09	02/07/2026	10TH VERSION OF DRAWINGS	H ZAREIEE	H ZAREIEE	F. ESMAEILZADE	H. REZAIIEE
08	01/25/2026	9TH VERSION OF DRAWINGS	H ZAREIEE	H ZAREIEE	F. ESMAEILZADE	H. REZAIIEE
07	01/14/2026	8TH VERSION OF DRAWINGS	H ZAREIEE	H ZAREIEE	F. ESMAEILZADE	H. REZAIIEE
06	01/10/2026	7TH VERSION OF DRAWINGS	H ZAREIEE	H ZAREIEE	F. ESMAEILZADE	H. REZAIIEE
05	12/28/2025	6TH VERSION OF DRAWINGS	H ZAREIEE	H ZAREIEE	F. ESMAEILZADE	H. REZAIIEE
04	12/03/2025	5TH VERSION OF DRAWINGS	H ZAREIEE	H ZAREIEE	F. ESMAEILZADE	H. REZAIIEE
03	11/16/2025	4TH VERSION OF DRAWINGS	H ZAREIEE	H ZAREIEE	F. ESMAEILZADE	H. REZAIIEE
02	10/16/2025	3TH VERSION OF DRAWINGS	H ZAREIEE	H ZAREIEE	F. ESMAEILZADE	H. REZAIIEE
01	08/17/2025	SECOND VERSION OF DRAWINGS	H ZAREIEE	H ZAREIEE	F. ESMAEILZADE	H. REZAIIEE
00	07/19/2025	FIRST VERSION OF DRAWINGS	H ZAREIEE	H ZAREIEE	F. ESMAEILZADE	H. REZAIIEE
REV.	DATE	DESCRIPTION	DESIGN	DRAWN	CHECKED	APPROVED
Client:			Consultant:			
						
			Contractor:		Sub Contractor:	
						
Project: 100MW Solar Power Plant (SARCHESHME)						
Title: Modeling File						
DOC NO.:		28P2-B-3MG-DWC-SOL-000000-ST-330				REV. 14
SCALE		SIZE		SHEET		FORMAT
FIT		A3		06/26		DWC

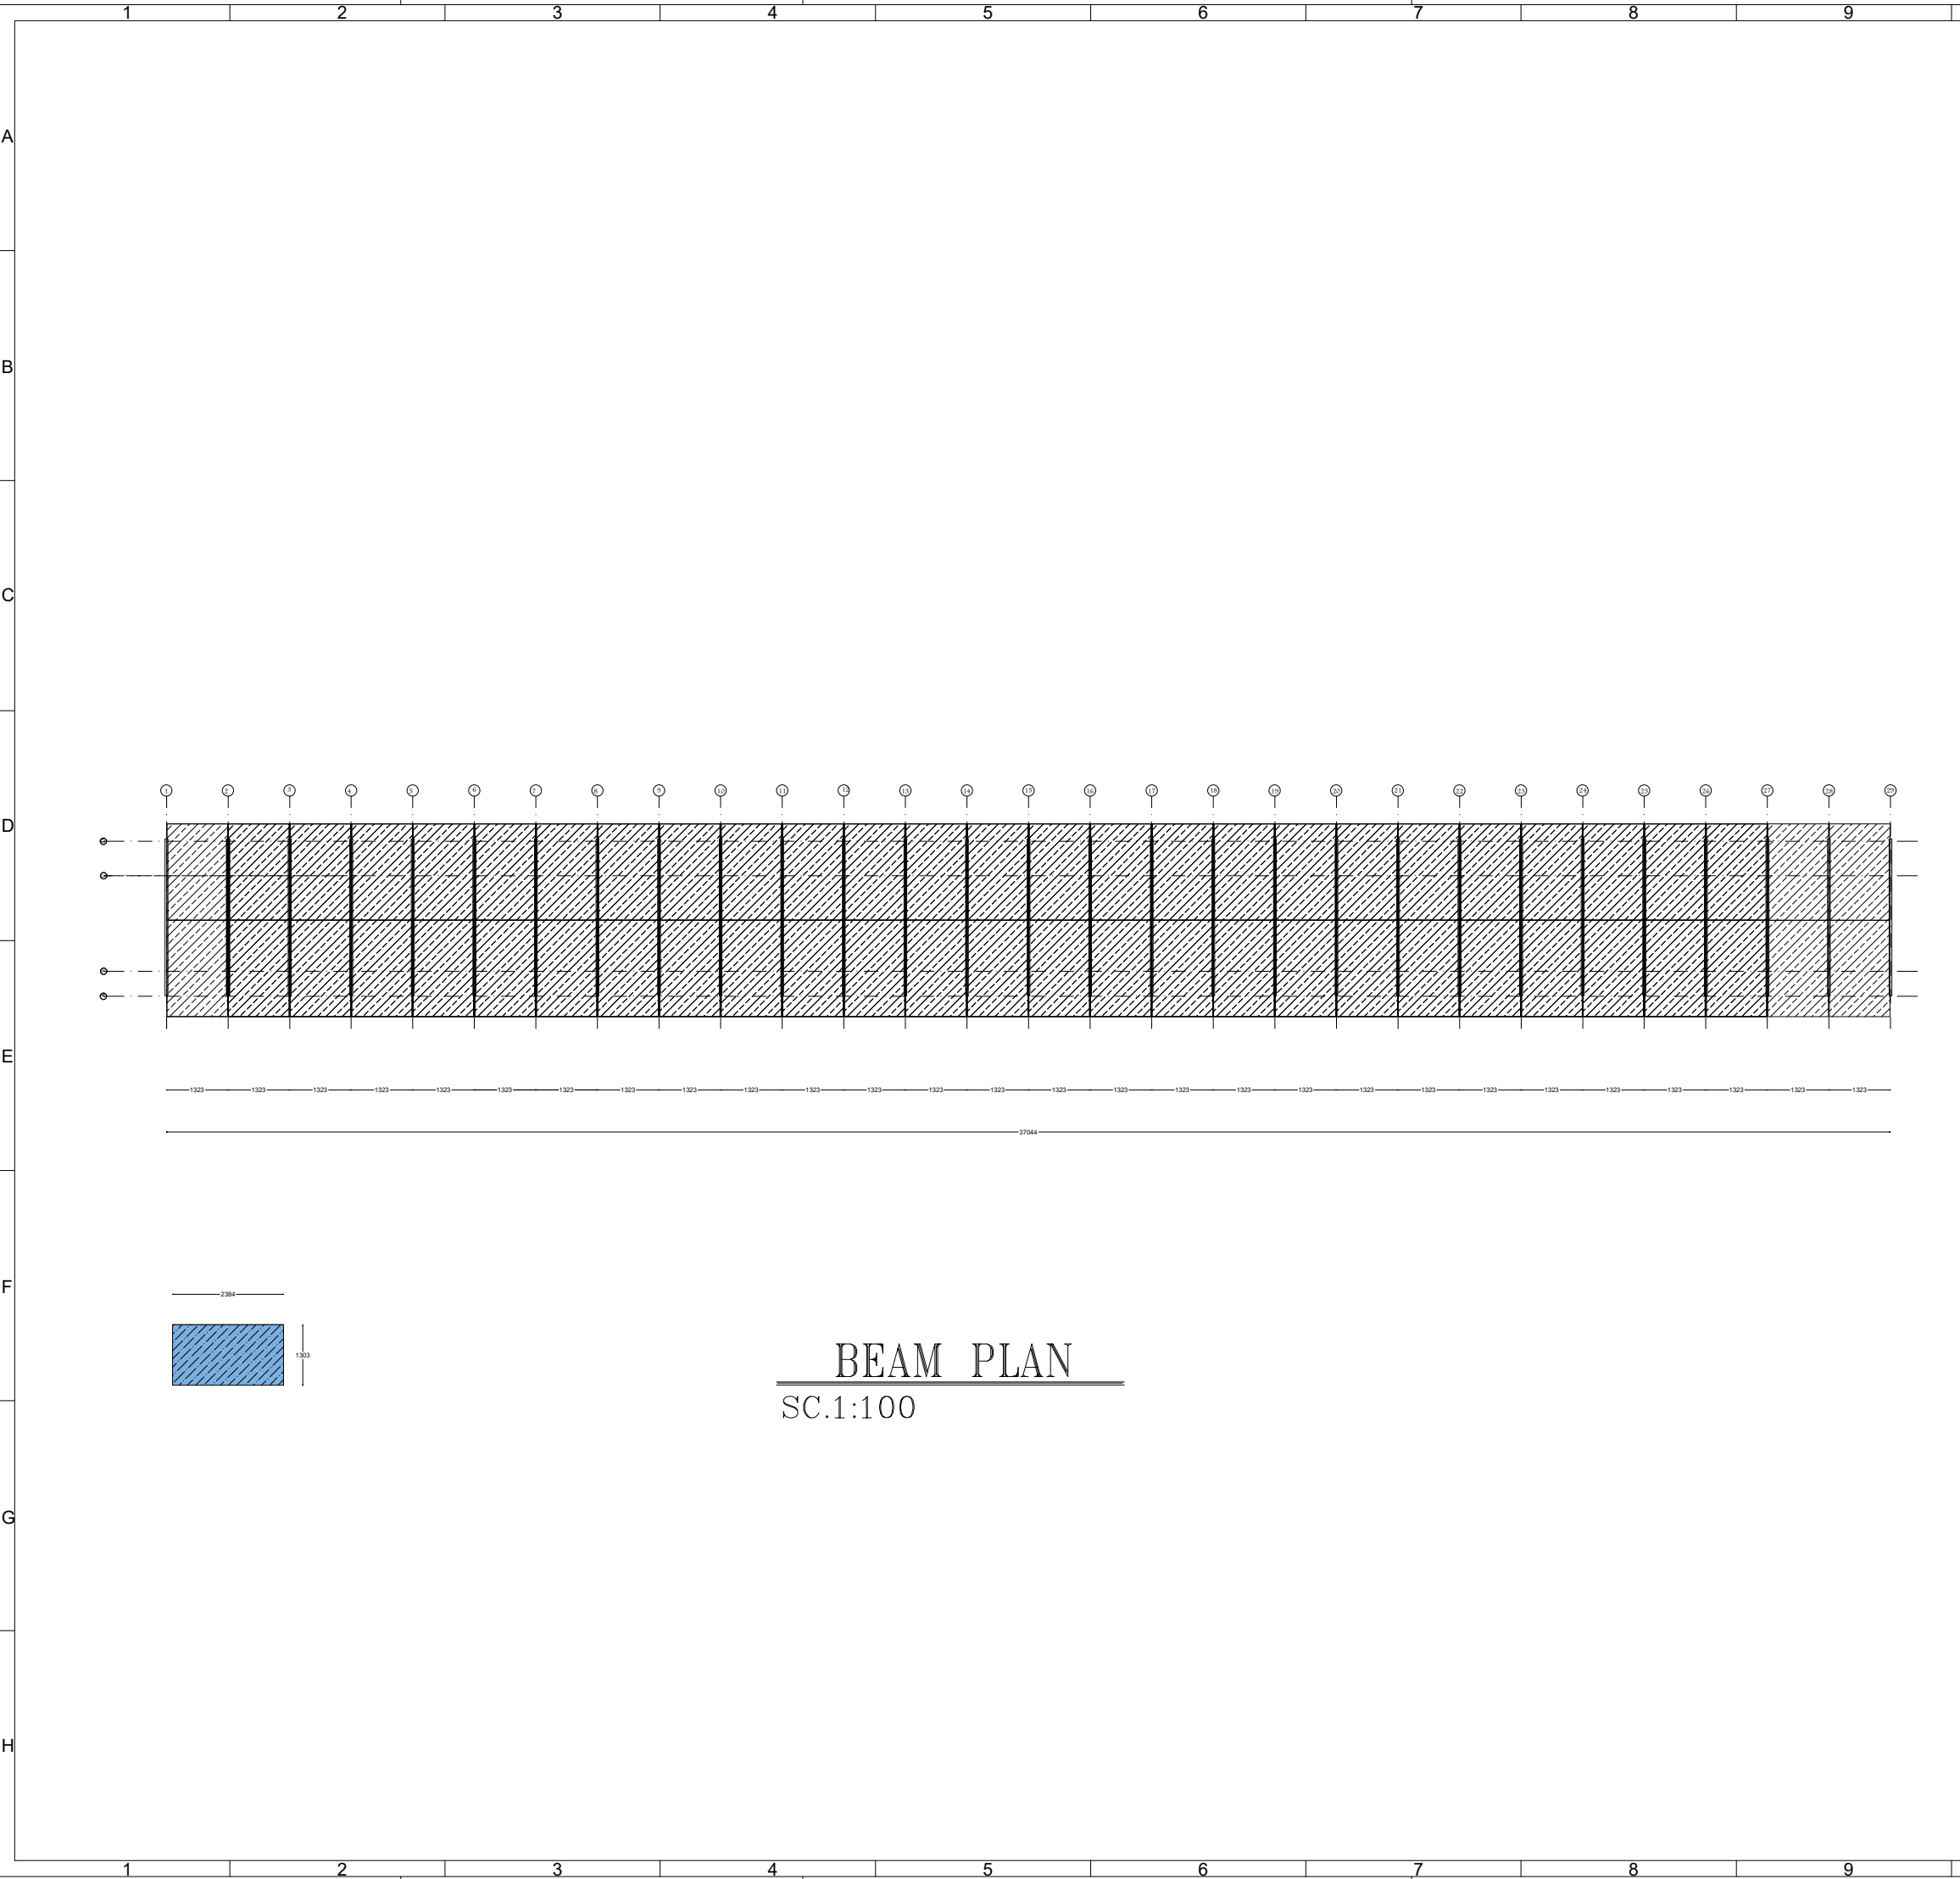

REFERENCE

REFERENCE.TITLE	REFERENCE.NO

NOTES

ALL DIMENSIONS ARE IN mm.

LEGEND

KEY PLAN

14	06/10/2026	15TH VERSION OF DRAWINGS	H ZAREIEE	H ZAREIEE	F. ESMAEILZADE	H. REZAIIEE
13	05/24/2026	14TH VERSION OF DRAWINGS	H ZAREIEE	H ZAREIEE	F. ESMAEILZADE	H. REZAIIEE
12	04/29/2026	13TH VERSION OF DRAWINGS	H ZAREIEE	H ZAREIEE	F. ESMAEILZADE	H. REZAIIEE
11	04/11/2026	12TH VERSION OF DRAWINGS	H ZAREIEE	H ZAREIEE	F. ESMAEILZADE	H. REZAIIEE
10	02/24/2026	11TH VERSION OF DRAWINGS	H ZAREIEE	H ZAREIEE	F. ESMAEILZADE	H. REZAIIEE
09	02/07/2026	10TH VERSION OF DRAWINGS	H ZAREIEE	H ZAREIEE	F. ESMAEILZADE	H. REZAIIEE
08	01/25/2026	9TH VERSION OF DRAWINGS	H ZAREIEE	H ZAREIEE	F. ESMAEILZADE	H. REZAIIEE
07	01/14/2026	8TH VERSION OF DRAWINGS	H ZAREIEE	H ZAREIEE	F. ESMAEILZADE	H. REZAIIEE
06	01/10/2026	7TH VERSION OF DRAWINGS	H ZAREIEE	H ZAREIEE	F. ESMAEILZADE	H. REZAIIEE
05	12/28/2025	6TH VERSION OF DRAWINGS	H ZAREIEE	H ZAREIEE	F. ESMAEILZADE	H. REZAIIEE
04	12/03/2025	5TH VERSION OF DRAWINGS	H ZAREIEE	H ZAREIEE	F. ESMAEILZADE	H. REZAIIEE
03	11/16/2025	4TH VERSION OF DRAWINGS	H ZAREIEE	H ZAREIEE	F. ESMAEILZADE	H. REZAIIEE
02	10/16/2025	3TH VERSION OF DRAWINGS	H ZAREIEE	H ZAREIEE	F. ESMAEILZADE	H. REZAIIEE
01	08/17/2025	SECOND VERSION OF DRAWINGS	H ZAREIEE	H ZAREIEE	F. ESMAEILZADE	H. REZAIIEE
00	07/19/2025	FIRST VERSION OF DRAWINGS	H ZAREIEE	H ZAREIEE	F. ESMAEILZADE	H. REZAIIEE
REV.	DATE	DESCRIPTION	DESIGN	DRAWN	CHECKED	APPROVED

Client:



Consultant:

موننکو ایران
Monenco Iran



Contractor:



Sub Contractor:

Project:

100MW Solar Power Plant
(SARCHESHME)

Title:


Module Arrangement on Table

DOC NO.:	28P2-B-3MG-DWC-SOL-000000-ST-330	REV. 14	
SCALE FIT	SIZE A3	SHEET 07/26	FORMAT DWC


10

11


12

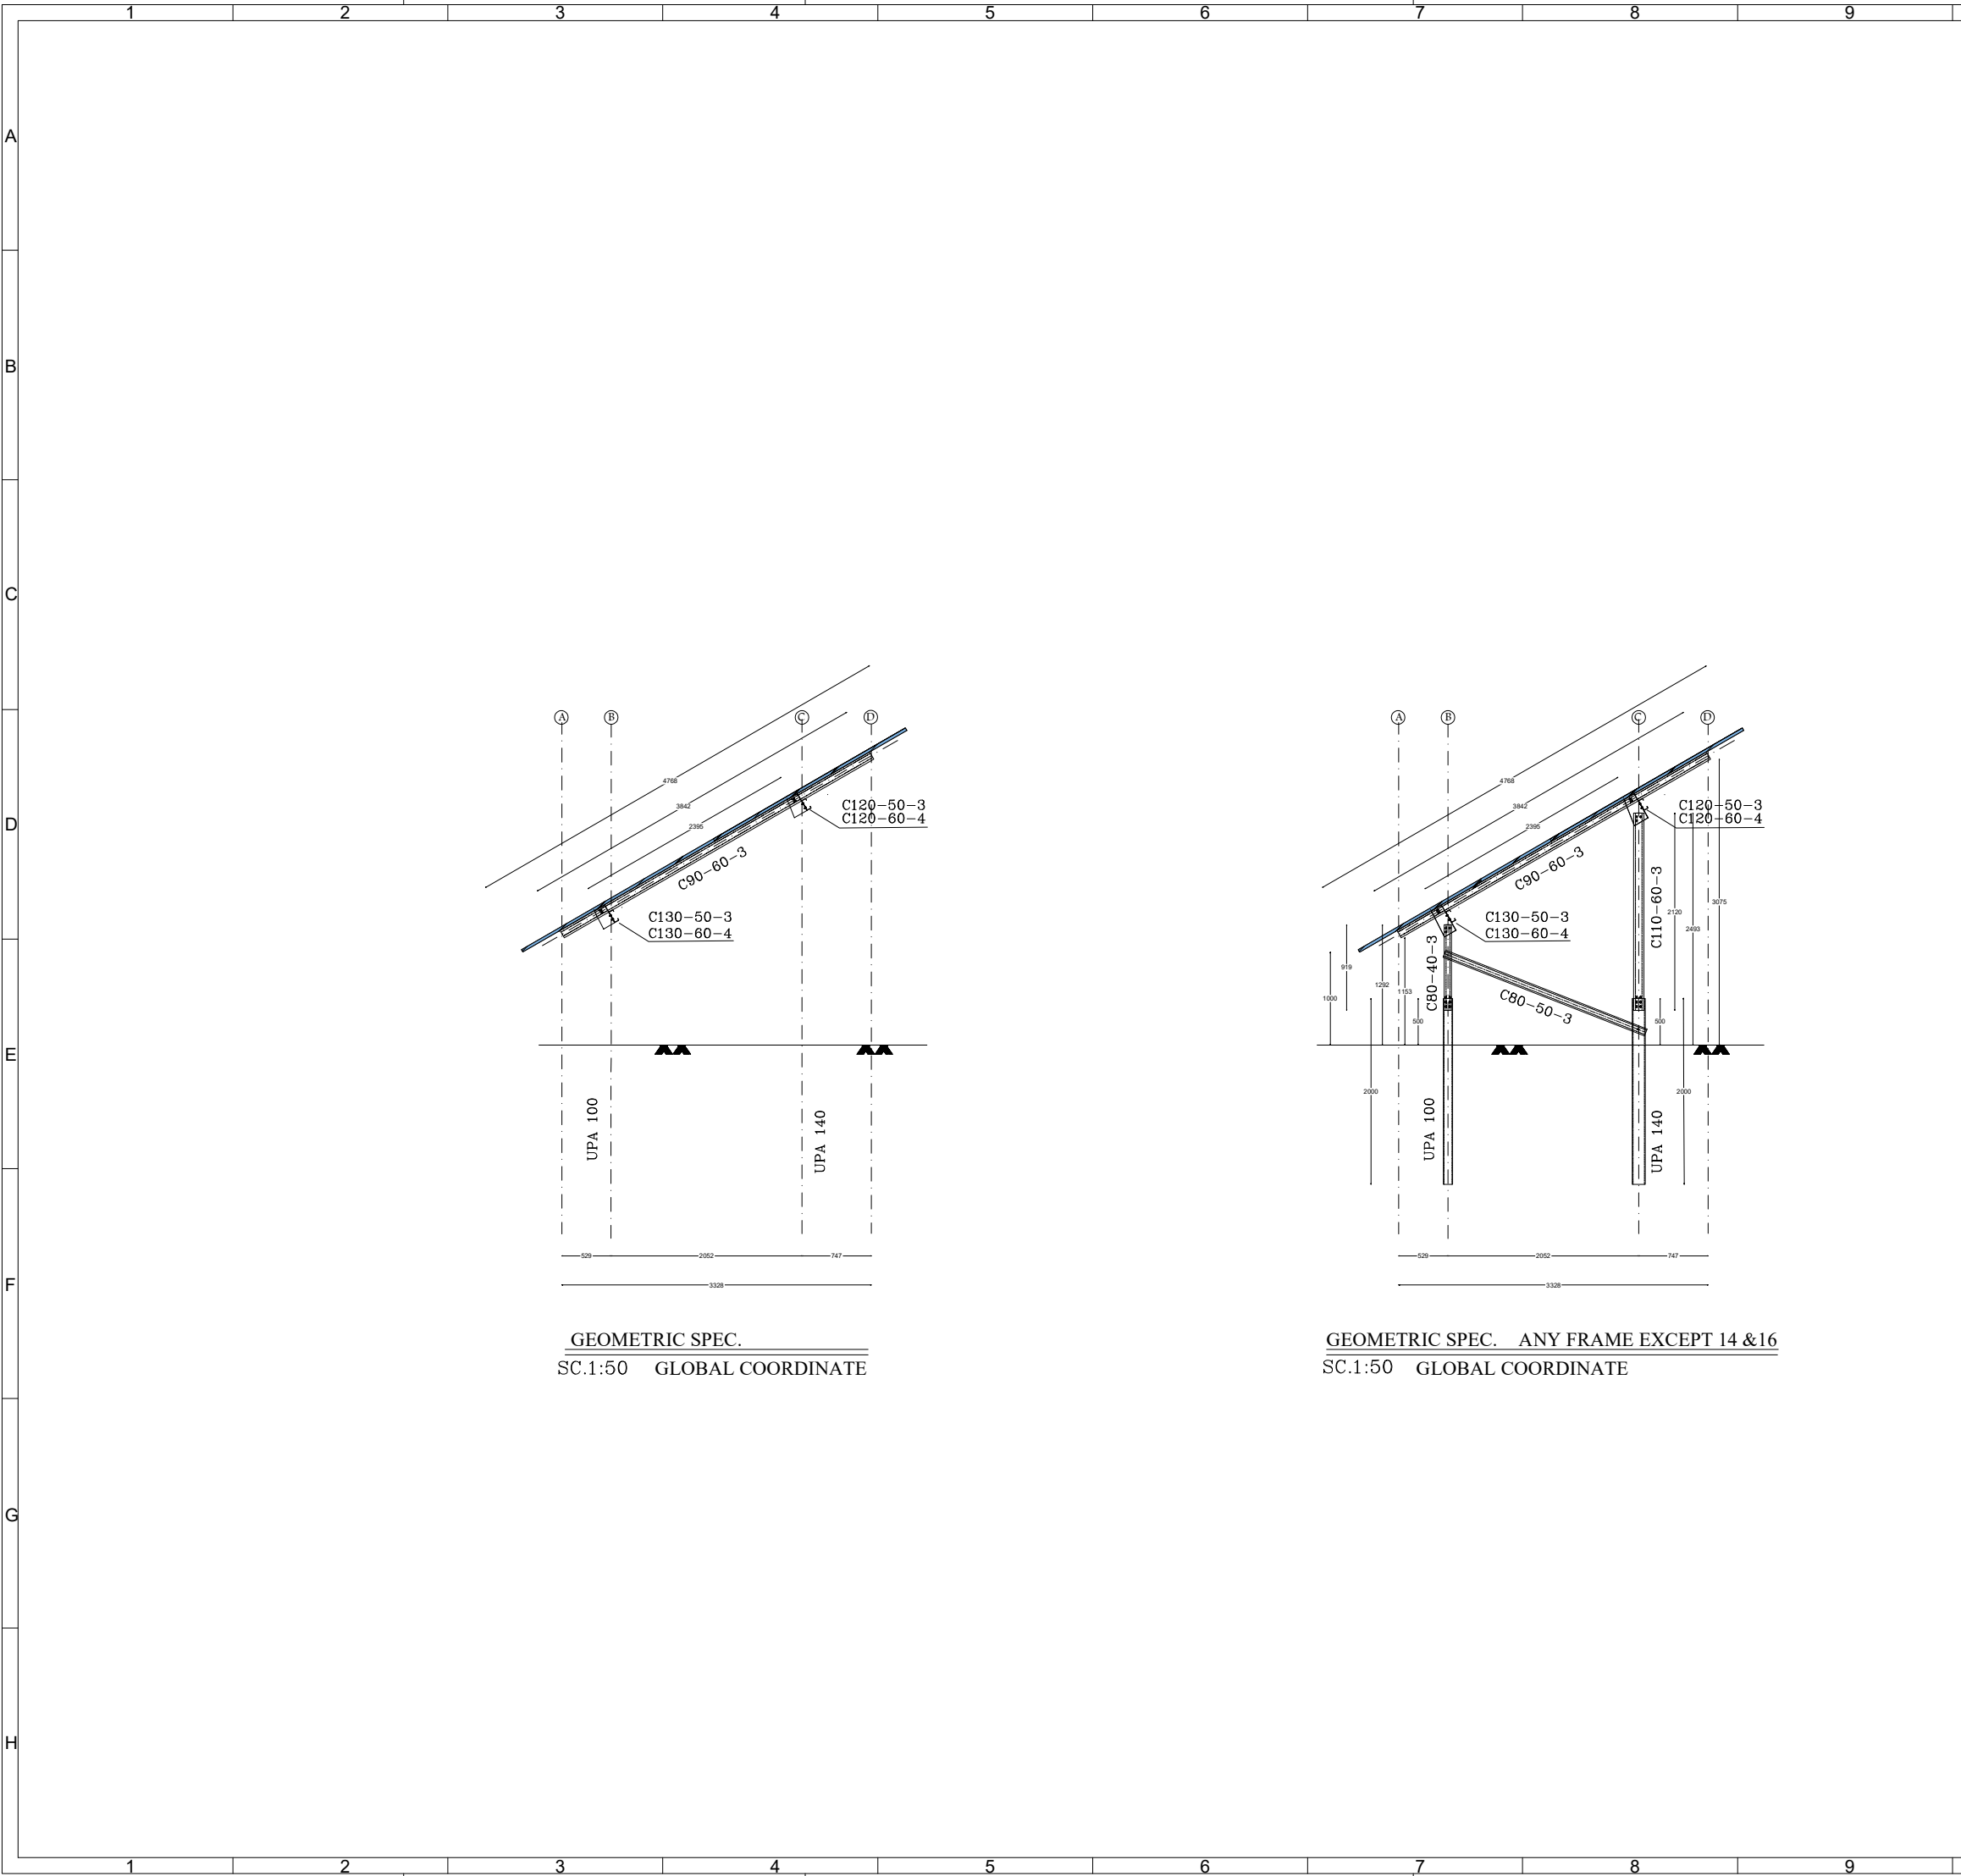











10			11			12		
REFERENCE								
REFERENCE.TITLE				REFERENCE.NO .				
NOTES								
ALL DIMENSIONS ARE IN mm.								
LEGEND								
KEY PLAN								
14	06/10/2026	15TH VERSION OF DRAWINGS	H ZAREIEE	H ZAREIEE	F. ESMAEILZADE	H. REZAEIE		
13	05/24/2026	14TH VERSION OF DRAWINGS	H ZAREIEE	H ZAREIEE	F. ESMAEILZADE	H. REZAEIE		
12	04/29/2026	13TH VERSION OF DRAWINGS	H ZAREIEE	H ZAREIEE	F. ESMAEILZADE	H. REZAEIE		
11	04/11/2026	12TH VERSION OF DRAWINGS	H ZAREIEE	H ZAREIEE	F. ESMAEILZADE	H. REZAEIE		
10	02/24/2026	11TH VERSION OF DRAWINGS	H ZAREIEE	H ZAREIEE	F. ESMAEILZADE	H. REZAEIE		
09	02/07/2026	10TH VERSION OF DRAWINGS	H ZAREIEE	H ZAREIEE	F. ESMAEILZADE	H. REZAEIE		
08	01/25/2026	9TH VERSION OF DRAWINGS	H ZAREIEE	H ZAREIEE	F. ESMAEILZADE	H. REZAEIE		
07	01/14/2026	8TH VERSION OF DRAWINGS	H ZAREIEE	H ZAREIEE	F. ESMAEILZADE	H. REZAEIE		
06	01/10/2026	7TH VERSION OF DRAWINGS	H ZAREIEE	H ZAREIEE	F. ESMAEILZADE	H. REZAEIE		
05	12/28/2025	6TH VERSION OF DRAWINGS	H ZAREIEE	H ZAREIEE	F. ESMAEILZADE	H. REZAEIE		
04	12/03/2025	5TH VERSION OF DRAWINGS	H ZAREIEE	H ZAREIEE	F. ESMAEILZADE	H. REZAEIE		
03	11/16/2025	4TH VERSION OF DRAWINGS	H ZAREIEE	H ZAREIEE	F. ESMAEILZADE	H. REZAEIE		
02	10/16/2025	3TH VERSION OF DRAWINGS	H ZAREIEE	H ZAREIEE	F. ESMAEILZADE	H. REZAEIE		
01	08/17/2025	SECOND VERSION OF DRAWINGS	H ZAREIEE	H ZAREIEE	F. ESMAEILZADE	H. REZAEIE		
00	07/19/2025	FIRST VERSION OF DRAWINGS	H ZAREIEE	H ZAREIEE	F. ESMAEILZADE	H. REZAEIE		
REV.	DATE	DESCRIPTION	DESIGN	DRAWN	CHECKED	APPROVED		
Client:			Consultant:					
								
								
Project:			100MW Solar Power Plant (SARCHESHME)					
Title:			Modeling File					
DOC NO.:	28P2-B-3MG-DWC-SOL-000000-ST-330				REV. 14			
SCALE		SIZE	SHEET		FORMAT			
FIT		A3	08/26		DWG			
10			11			12		

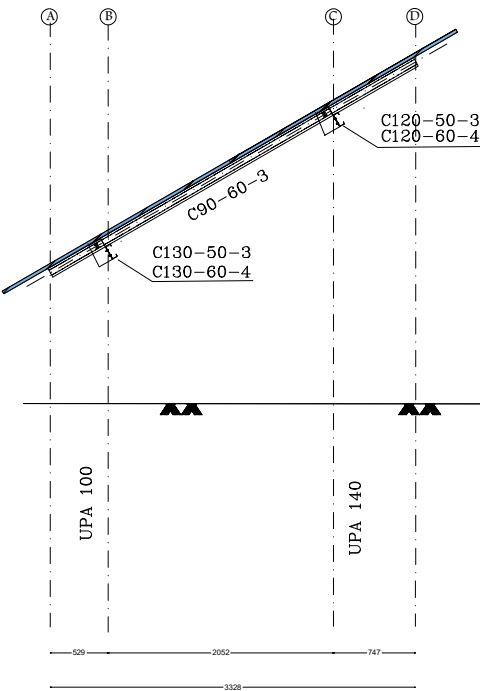

SECTION SPEC. AXIS 1 & 11
SC.1:50 GLOBAL COORDINATE

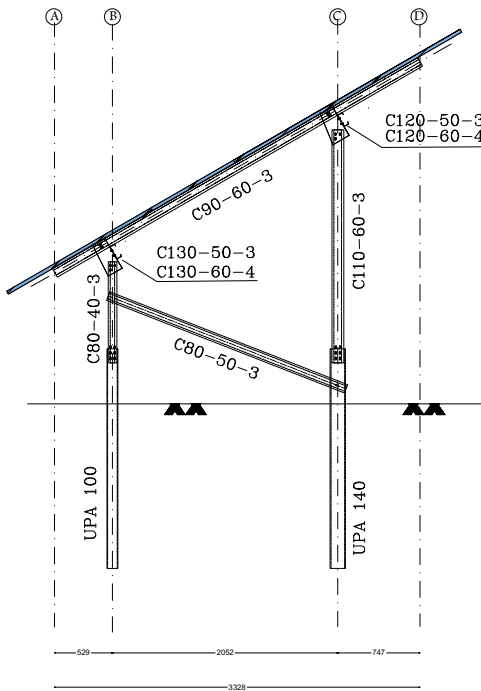


          SECTION SPEC. AXIS 2 TO 1
SC.1:50 GLOBAL COORDINATE

 C130-60-4 st52	 C130-50-3 st52	 C120-60-4 st52	 C120-50-3 st52	 C110-60-3 st52	 C90-60-3 st52	 C80-50-3 st52	 C80-40-3 st52	 UPA140 st37	 UPA100 st37
--	--	---	--	--	---	---	---	---	---

LSF SECTION
SC.1:10

REFERENCE						
REFERENCE.TITLE			REFERENCE.NO .			
NOTES						
ALL DIMENSIONS ARE IN mm.						
LEGEND						
KEY PLAN						
14	06/10/2026	15TH VERSION OF DRAWINGS	H ZAREIEE	H ZAREIEE	F. ESMAEILZADE	H. REZAEIEE
13	05/24/2026	14TH VERSION OF DRAWINGS	H ZAREIEE	H ZAREIEE	F. ESMAEILZADE	H. REZAEIEE
12	04/29/2026	13TH VERSION OF DRAWINGS	H ZAREIEE	H ZAREIEE	F. ESMAEILZADE	H. REZAEIEE
11	04/11/2026	12TH VERSION OF DRAWINGS	H ZAREIEE	H ZAREIEE	F. ESMAEILZADE	H. REZAEIEE
10	02/24/2026	11TH VERSION OF DRAWINGS	H ZAREIEE	H ZAREIEE	F. ESMAEILZADE	H. REZAEIEE
09	02/07/2026	10TH VERSION OF DRAWINGS	H ZAREIEE	H ZAREIEE	F. ESMAEILZADE	H. REZAEIEE
08	01/25/2026	9TH VERSION OF DRAWINGS	H ZAREIEE	H ZAREIEE	F. ESMAEILZADE	H. REZAEIEE
07	01/14/2026	8TH VERSION OF DRAWINGS	H ZAREIEE	H ZAREIEE	F. ESMAEILZADE	H. REZAEIEE
06	01/10/2026	7TH VERSION OF DRAWINGS	H ZAREIEE	H ZAREIEE	F. ESMAEILZADE	H. REZAEIEE
05	12/28/2025	6TH VERSION OF DRAWINGS	H ZAREIEE	H ZAREIEE	F. ESMAEILZADE	H. REZAEIEE
04	12/03/2025	5TH VERSION OF DRAWINGS	H ZAREIEE	H ZAREIEE	F. ESMAEILZADE	H. REZAEIEE
03	11/16/2025	4TH VERSION OF DRAWINGS	H ZAREIEE	H ZAREIEE	F. ESMAEILZADE	H. REZAEIEE
02	10/16/2025	3TH VERSION OF DRAWINGS	H ZAREIEE	H ZAREIEE	F. ESMAEILZADE	H. REZAEIEE
01	08/17/2025	SECOND VERSION OF DRAWINGS	H ZAREIEE	H ZAREIEE	F. ESMAEILZADE	H. REZAEIEE
00	07/19/2025	FIRST VERSION OF DRAWINGS	H ZAREIEE	H ZAREIEE	F. ESMAEILZADE	H. REZAEIEE
REV.	DATE	DESCRIPTION	DESIGN	DRAWN	CHECKED	APPROVED
Client:			Consultant:			
						
			Contractor:		Sub Contractor:	
						
Project: 100MW Solar Power Plant (SARCHESHME)						
Title: Modeling File						
DOC NO.:		28P2-B-3MG-DWG-SOL-000000-ST-330			REV.	
					14	
SCALE		SIZE		SHEET		FORMAT
FIT		A3		09/26		DWG

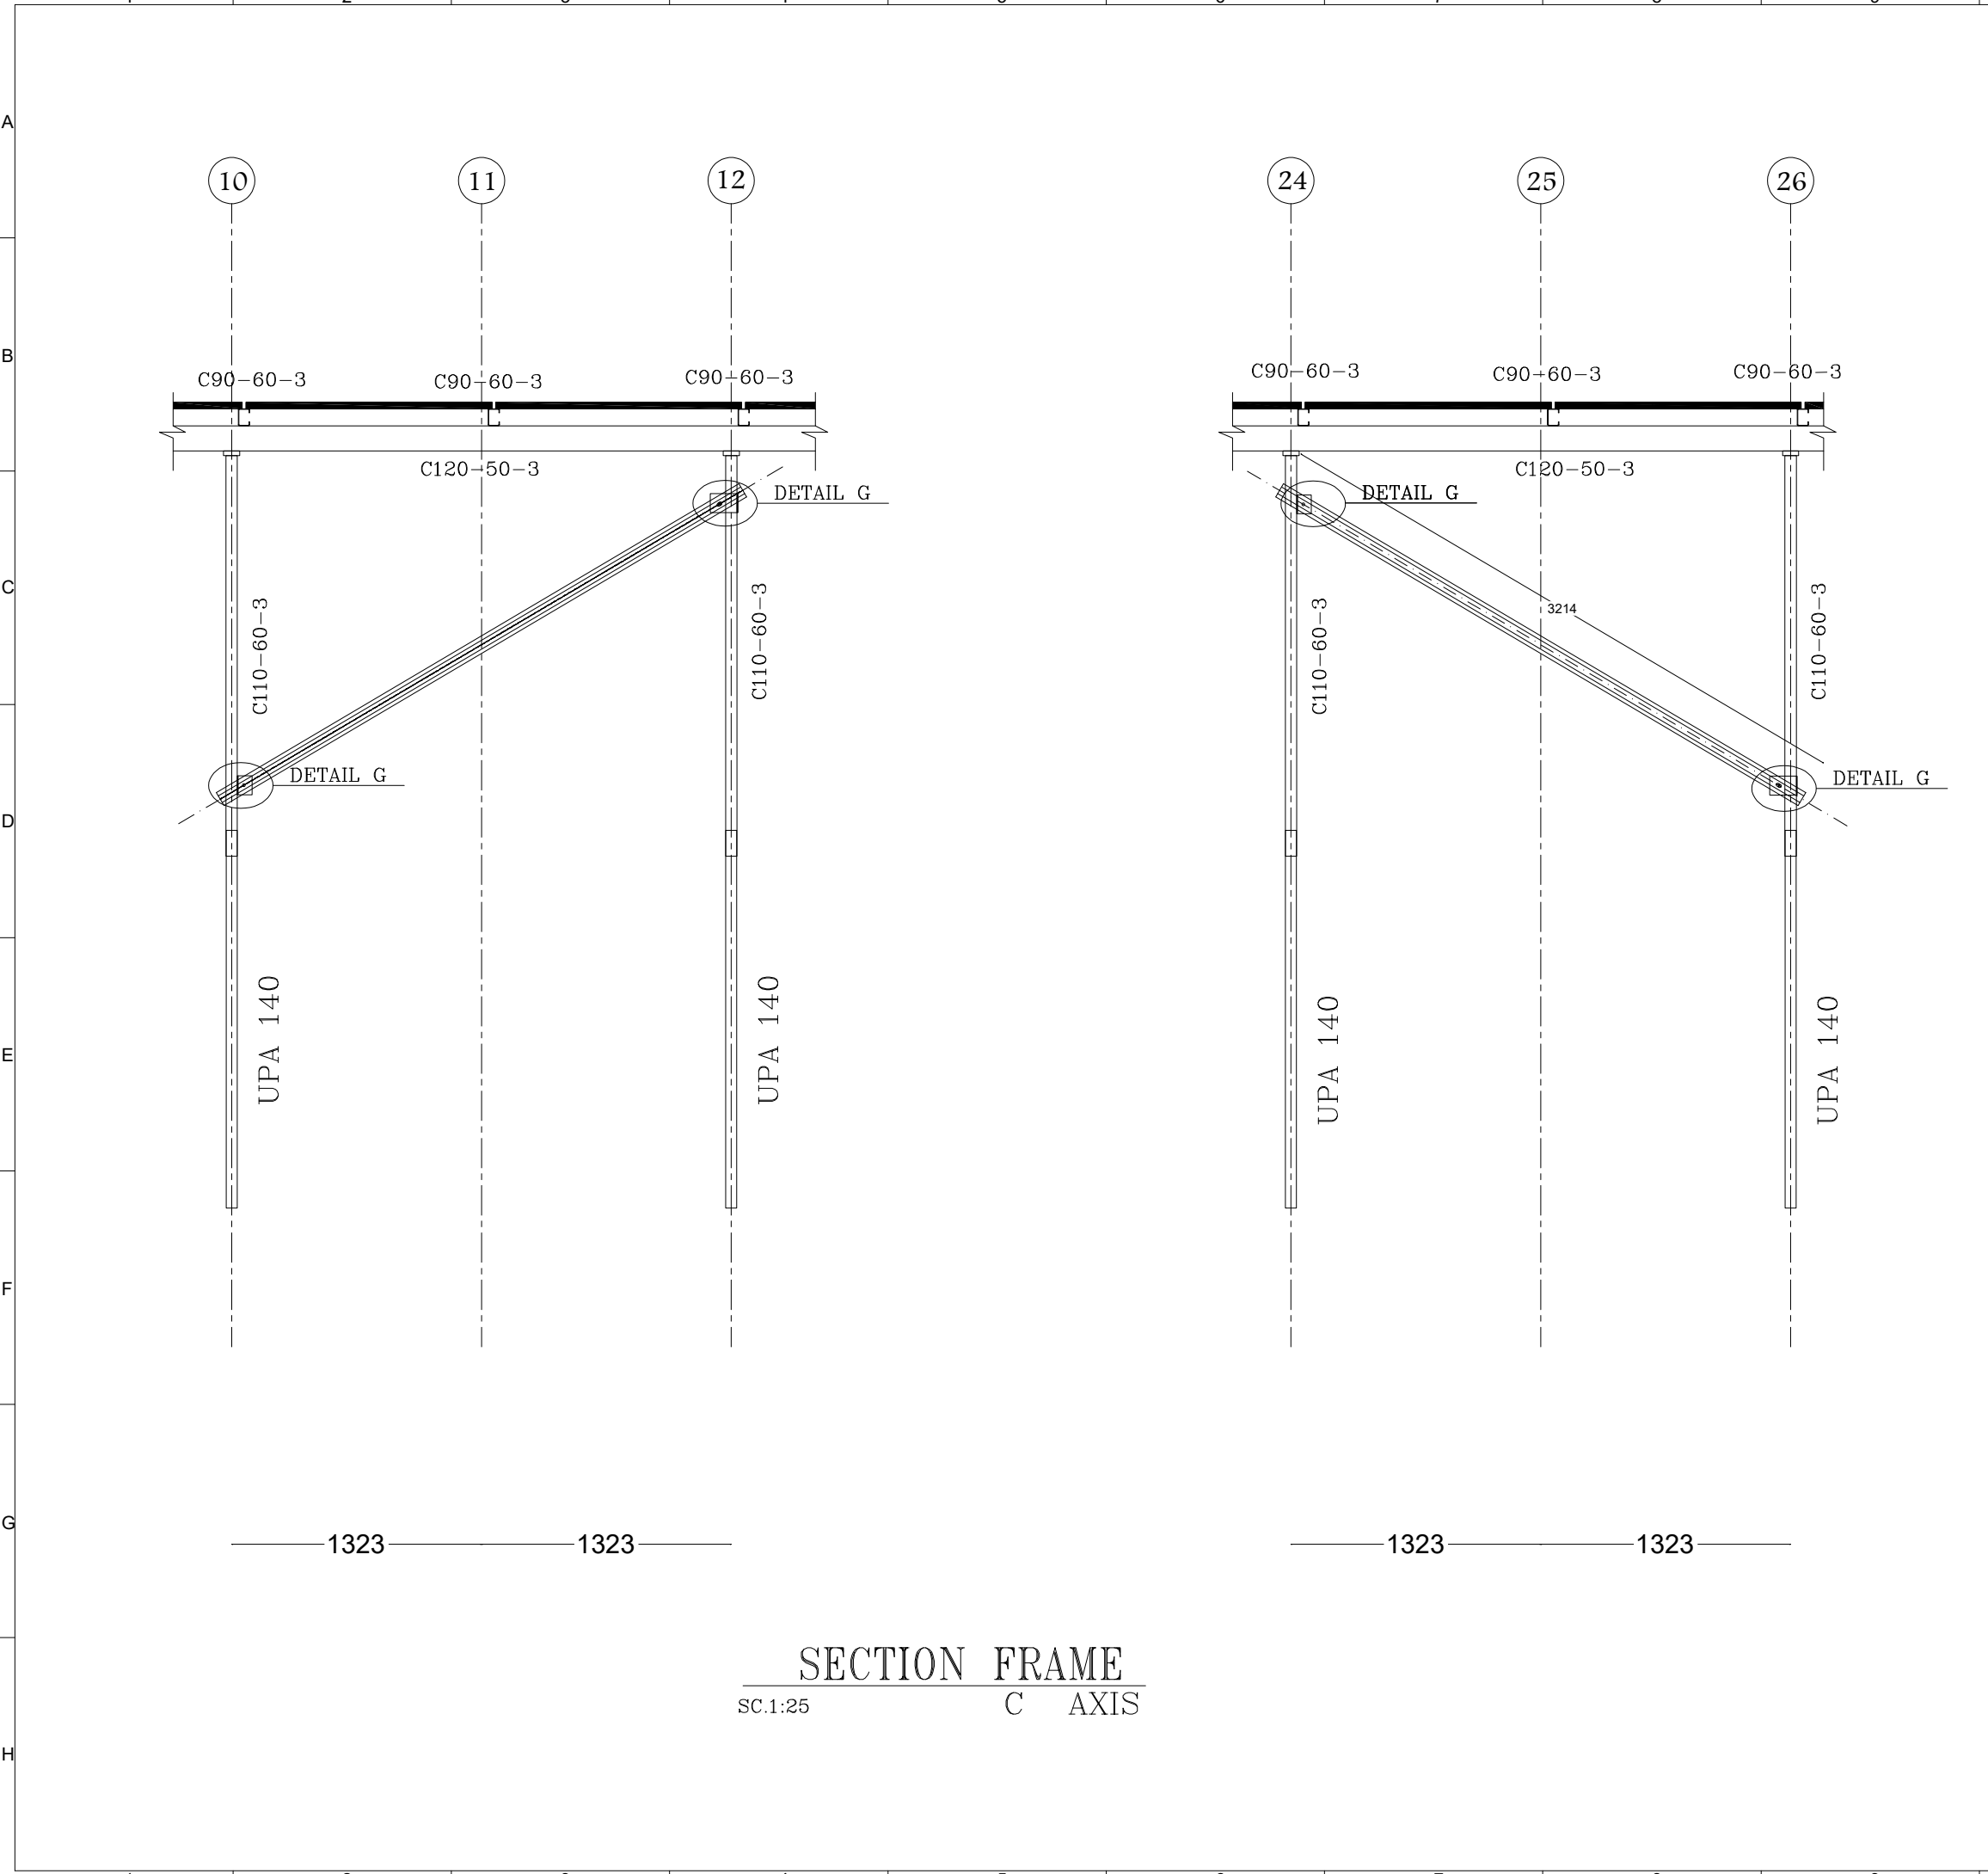

REFERENCE

REFERENCE.TITLE	REFERENCE.NO .

NOTES

ALL DIMENSIONS ARE IN mm.

LEGEND

KEY PLAN

14	06/10/2026	15TH VERSION OF DRAWINGS	H ZAREIEE	H ZAREIEE	F. ESMAEILZADE	H. REZAEIE
13	05/24/2026	14TH VERSION OF DRAWINGS	H ZAREIEE	H ZAREIEE	F. ESMAEILZADE	H. REZAEIE
12	04/29/2026	13TH VERSION OF DRAWINGS	H ZAREIEE	H ZAREIEE	F. ESMAEILZADE	H. REZAEIE
11	04/11/2026	12TH VERSION OF DRAWINGS	H ZAREIEE	H ZAREIEE	F. ESMAEILZADE	H. REZAEIE
10	02/24/2026	11TH VERSION OF DRAWINGS	H ZAREIEE	H ZAREIEE	F. ESMAEILZADE	H. REZAEIE
09	02/07/2026	10TH VERSION OF DRAWINGS	H ZAREIEE	H ZAREIEE	F. ESMAEILZADE	H. REZAEIE
08	01/25/2026	9TH VERSION OF DRAWINGS	H ZAREIEE	H ZAREIEE	F. ESMAEILZADE	H. REZAEIE
07	01/14/2026	8TH VERSION OF DRAWINGS	H ZAREIEE	H ZAREIEE	F. ESMAEILZADE	H. REZAEIE
06	01/10/2026	7TH VERSION OF DRAWINGS	H ZAREIEE	H ZAREIEE	F. ESMAEILZADE	H. REZAEIE
05	12/28/2025	6TH VERSION OF DRAWINGS	H ZAREIEE	H ZAREIEE	F. ESMAEILZADE	H. REZAEIE
04	12/03/2025	5TH VERSION OF DRAWINGS	H ZAREIEE	H ZAREIEE	F. ESMAEILZADE	H. REZAEIE
03	11/16/2025	4TH VERSION OF DRAWINGS	H ZAREIEE	H ZAREIEE	F. ESMAEILZADE	H. REZAEIE
02	10/16/2025	3TH VERSION OF DRAWINGS	H ZAREIEE	H ZAREIEE	F. ESMAEILZADE	H. REZAEIE
01	08/17/2025	SECOND VERSION OF DRAWINGS	H ZAREIEE	H ZAREIEE	F. ESMAEILZADE	H. REZAEIE
00	07/19/2025	FIRST VERSION OF DRAWINGS	H ZAREIEE	H ZAREIEE	F. ESMAEILZADE	H. REZAEIE
REV.	DATE	DESCRIPTION	DESIGN	DRAWN	CHECKED	APPROVED

Client:



Consultant:

مونenco ایران
Monenco Iran



Contractor:




Sub Contractor:



Project: 100MW Solar Power Plant (SARCHESHME)

Title: Modeling File


DOC NO.:	28P2-B-3MG-DWC-SOL-000000-ST-330	REV.	
SCALE	SIZE	SHEET	FORMAT
FIT	A3	10/26	DWG

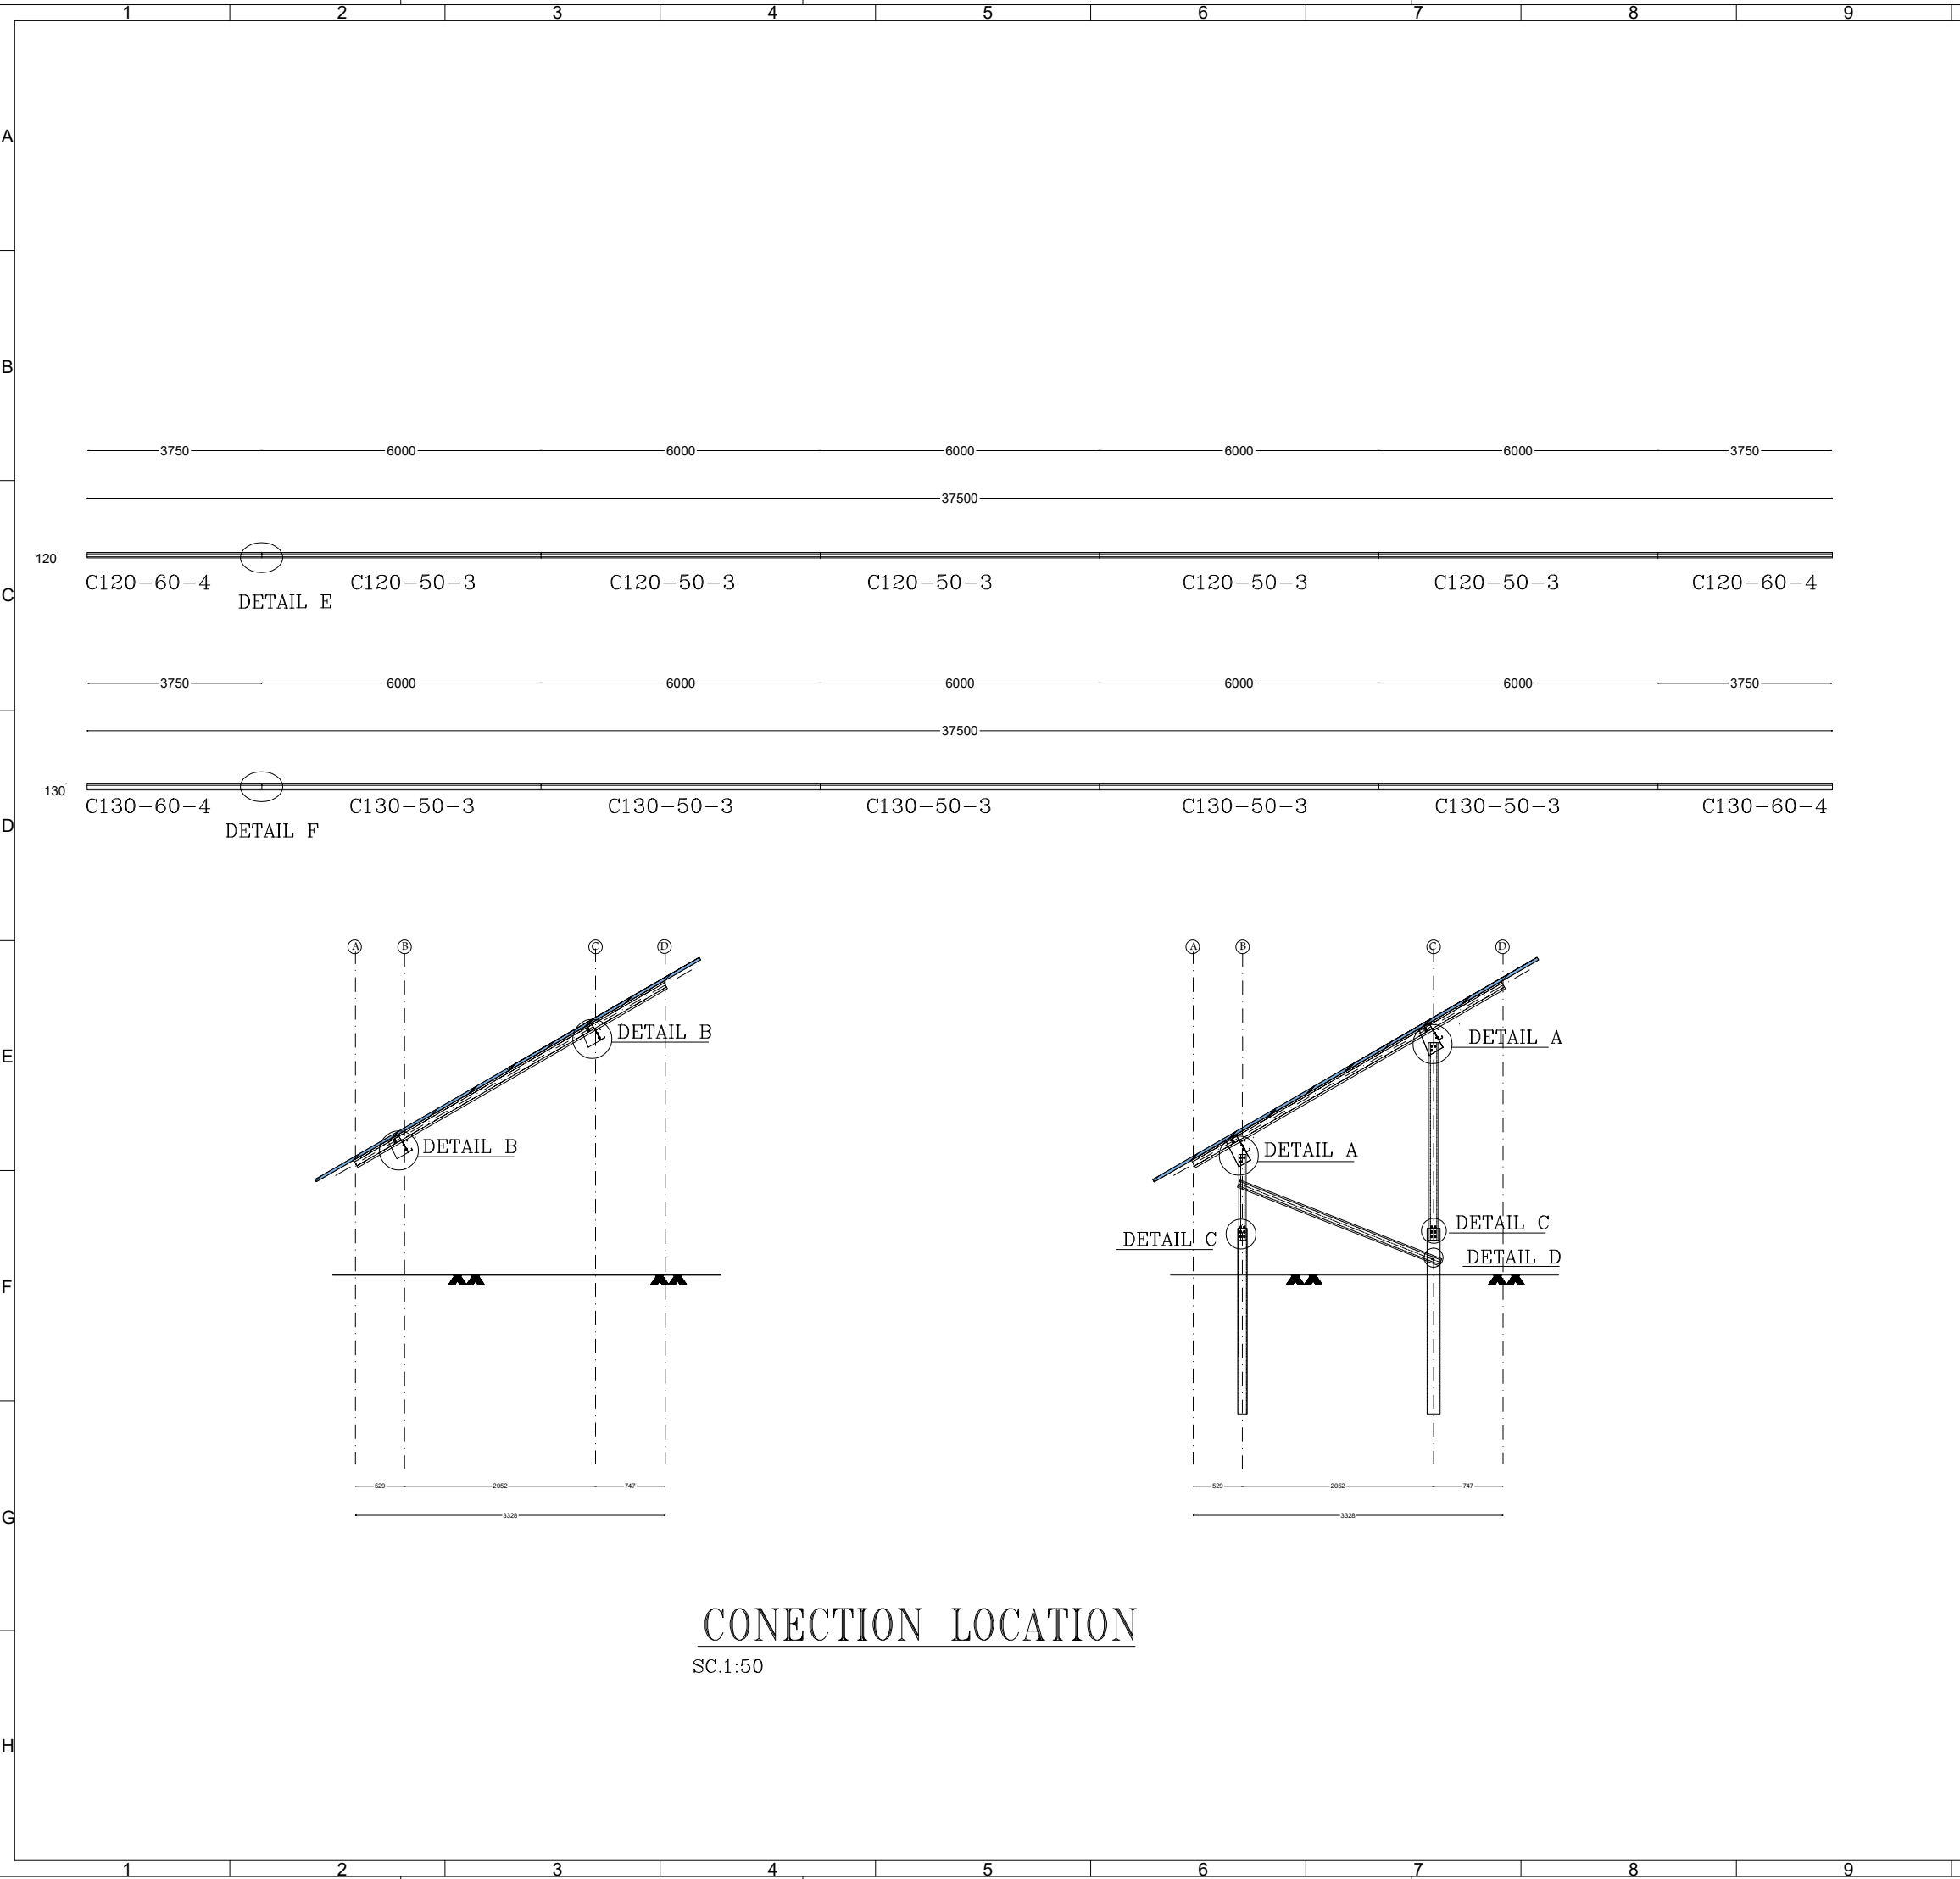

10		11		12	
REFERENCE					
REFERENCE.TITLE			REFERENCE.NO .		
NOTES					
ALL DIMENSIONS ARE IN mm.					
LEGEND					
KEY PLAN					
14	06/10/2026	15TH VERSION OF DRAWINGS	H ZAREIEE	H ZAREIEE	F. ESMAEILZADE H. REZAIEE
13	05/24/2026	14TH VERSION OF DRAWINGS	H ZAREIEE	H ZAREIEE	F. ESMAEILZADE H. REZAIEE
12	04/29/2026	13TH VERSION OF DRAWINGS	H ZAREIEE	H ZAREIEE	F. ESMAEILZADE H. REZAIEE
11	04/11/2026	12TH VERSION OF DRAWINGS	H ZAREIEE	H ZAREIEE	F. ESMAEILZADE H. REZAIEE
10	02/24/2026	11TH VERSION OF DRAWINGS	H ZAREIEE	H ZAREIEE	F. ESMAEILZADE H. REZAIEE
09	02/07/2026	10TH VERSION OF DRAWINGS	H ZAREIEE	H ZAREIEE	F. ESMAEILZADE H. REZAIEE
08	01/25/2026	9TH VERSION OF DRAWINGS	H ZAREIEE	H ZAREIEE	F. ESMAEILZADE H. REZAIEE
07	01/14/2026	8TH VERSION OF DRAWINGS	H ZAREIEE	H ZAREIEE	F. ESMAEILZADE H. REZAIEE
06	01/10/2026	7TH VERSION OF DRAWINGS	H ZAREIEE	H ZAREIEE	F. ESMAEILZADE H. REZAIEE
05	12/28/2025	6TH VERSION OF DRAWINGS	H ZAREIEE	H ZAREIEE	F. ESMAEILZADE H. REZAIEE
04	12/03/2025	5TH VERSION OF DRAWINGS	H ZAREIEE	H ZAREIEE	F. ESMAEILZADE H. REZAIEE
03	11/16/2025	4TH VERSION OF DRAWINGS	H ZAREIEE	H ZAREIEE	F. ESMAEILZADE H. REZAIEE
02	10/16/2025	3TH VERSION OF DRAWINGS	H ZAREIEE	H ZAREIEE	F. ESMAEILZADE H. REZAIEE
01	08/17/2025	SECOND VERSION OF DRAWINGS	H ZAREIEE	H ZAREIEE	F. ESMAEILZADE H. REZAIEE
00	07/19/2025	FIRST VERSION OF DRAWINGS	H ZAREIEE	H ZAREIEE	F. ESMAEILZADE H. REZAIEE
REV.	DATE	DESCRIPTION	DESIGN	DRAWN	CHECKED APPROVED
Client:			Consultant:		
 NICCO			 مشاورت و مهندسی سازه دانشگاه تهران Monenco Iran		
			 گروه مهام شرق		
Contractor:			Sub Contractor:		
					
Project: 100MW Solar Power Plant (SARCHESHME)					
Title: STRUCTURE DETAILS DRAWING					
DOC NO.:		28P2-B-3MG-DWC-SOL-000000-ST-330			REV. 14
SCALE		SIZE	SHEET		FORMAT
FIT		A3	11 / 26		DWG
10		11		12	

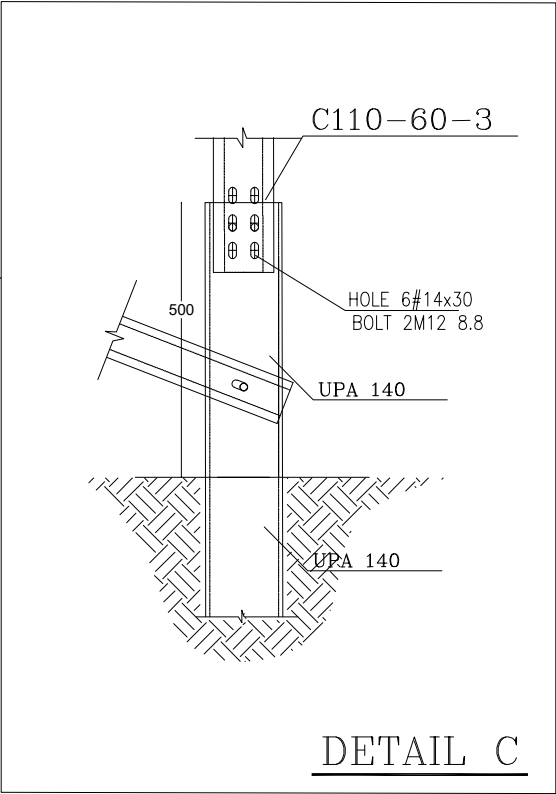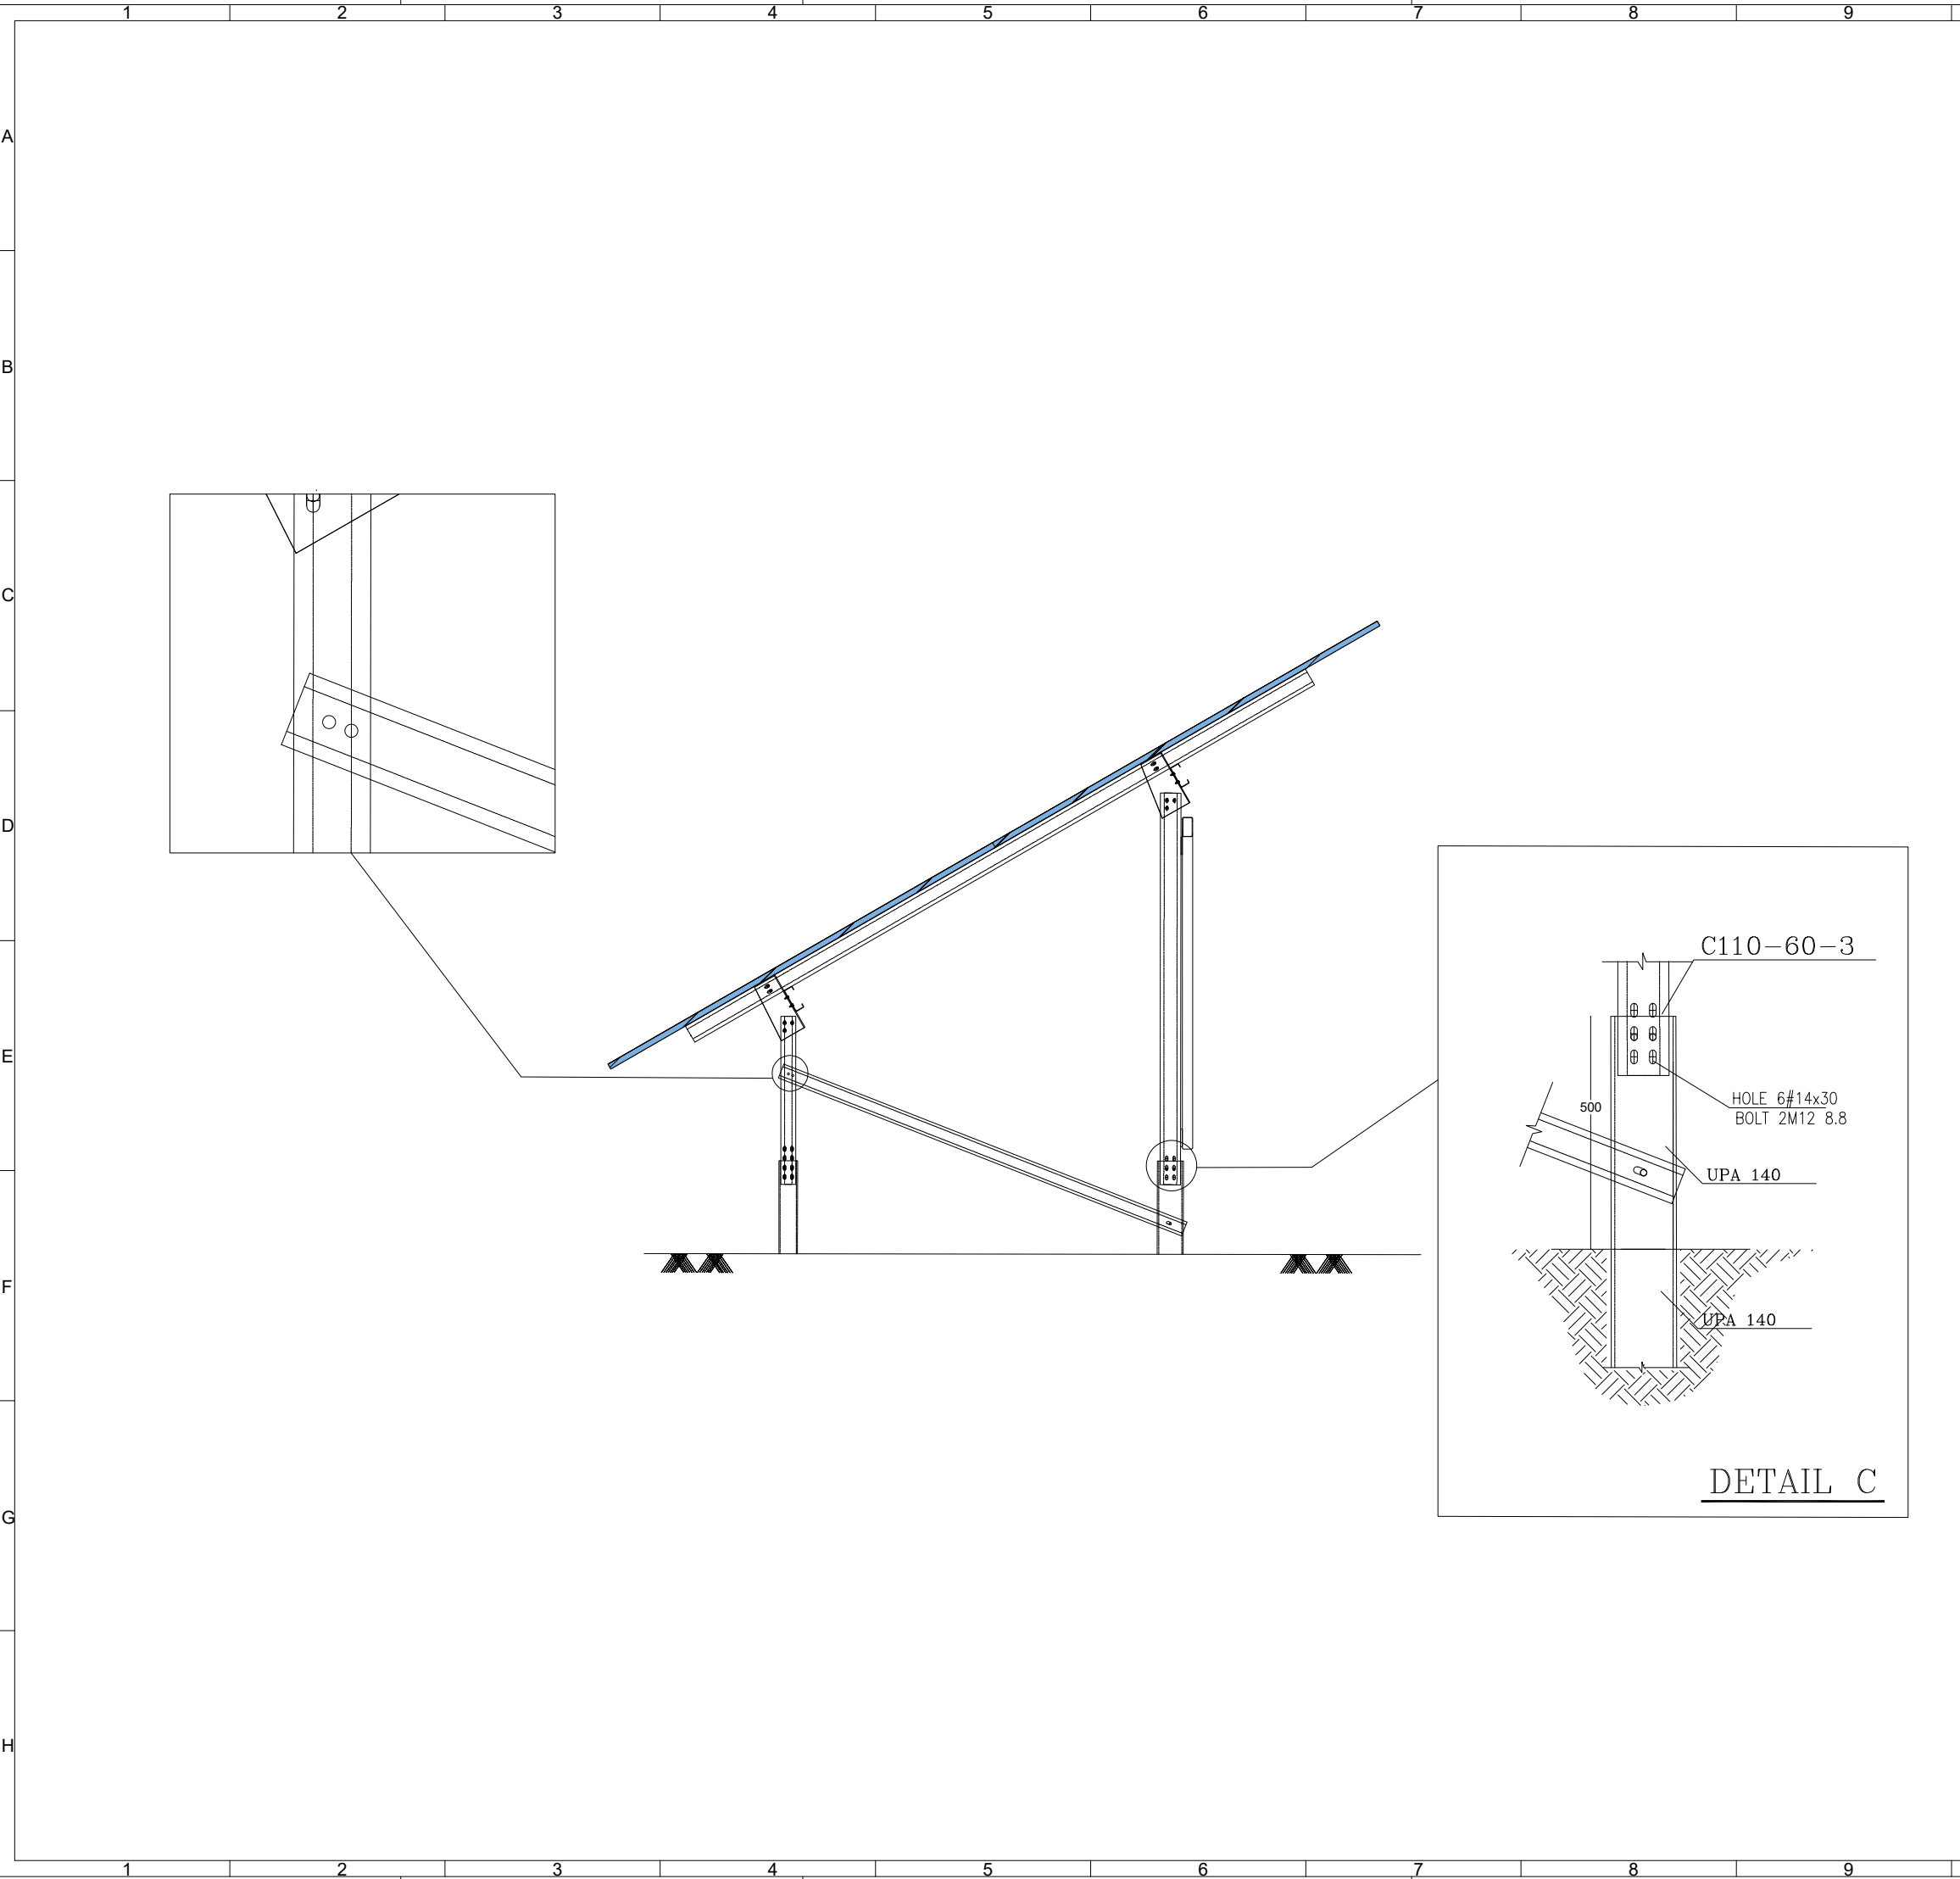


REFERENCE						
REFERENCE.TITLE			REFERENCE.NO .			
NOTES						
ALL DIMENSIONS ARE IN mm.						
LEGEND						
KEY PLAN						
14	06/10/2026	15TH VERSION OF DRAWINGS	H ZAREIEE	H ZAREIEE	F. ESMAEILZADE	H. REZAIIEE
13	05/24/2026	14TH VERSION OF DRAWINGS	H ZAREIEE	H ZAREIEE	F. ESMAEILZADE	H. REZAIIEE
12	04/29/2026	13TH VERSION OF DRAWINGS	H ZAREIEE	H ZAREIEE	F. ESMAEILZADE	H. REZAIIEE
11	04/11/2026	12TH VERSION OF DRAWINGS	H ZAREIEE	H ZAREIEE	F. ESMAEILZADE	H. REZAIIEE
10	02/24/2026	11TH VERSION OF DRAWINGS	H ZAREIEE	H ZAREIEE	F. ESMAEILZADE	H. REZAIIEE
09	02/07/2026	10TH VERSION OF DRAWINGS	H ZAREIEE	H ZAREIEE	F. ESMAEILZADE	H. REZAIIEE
08	01/25/2026	9TH VERSION OF DRAWINGS	H ZAREIEE	H ZAREIEE	F. ESMAEILZADE	H. REZAIIEE
07	01/14/2026	8TH VERSION OF DRAWINGS	H ZAREIEE	H ZAREIEE	F. ESMAEILZADE	H. REZAIIEE
06	01/10/2026	7TH VERSION OF DRAWINGS	H ZAREIEE	H ZAREIEE	F. ESMAEILZADE	H. REZAIIEE
05	12/28/2025	6TH VERSION OF DRAWINGS	H ZAREIEE	H ZAREIEE	F. ESMAEILZADE	H. REZAIIEE
04	12/03/2025	5TH VERSION OF DRAWINGS	H ZAREIEE	H ZAREIEE	F. ESMAEILZADE	H. REZAIIEE
03	11/16/2025	4TH VERSION OF DRAWINGS	H ZAREIEE	H ZAREIEE	F. ESMAEILZADE	H. REZAIIEE
02	10/16/2025	3TH VERSION OF DRAWINGS	H ZAREIEE	H ZAREIEE	F. ESMAEILZADE	H. REZAIIEE
01	08/17/2025	SECOND VERSION OF DRAWINGS	H ZAREIEE	H ZAREIEE	F. ESMAEILZADE	H. REZAIIEE
00	07/19/2025	FIRST VERSION OF DRAWINGS	H ZAREIEE	H ZAREIEE	F. ESMAEILZADE	H. REZAIIEE
REV.	DATE	DESCRIPTION	DESIGN	DRAWN	CHECKED	APPROVED
Client:			Consultant:			
   			Contractor:			
   					Sub Contractor:	
Project: 100MW Solar Power Plant (SARCHESHME)						
Title: <u>STRUCTURE DETAILS DRAWING</u>						
DOC NO.:		28P2-B-3MG-DWG-SOL-000000-ST-330				REV.
						14
SCALE		SIZE		SHEET		FORMAT
FIT		A3		12/26		DWG

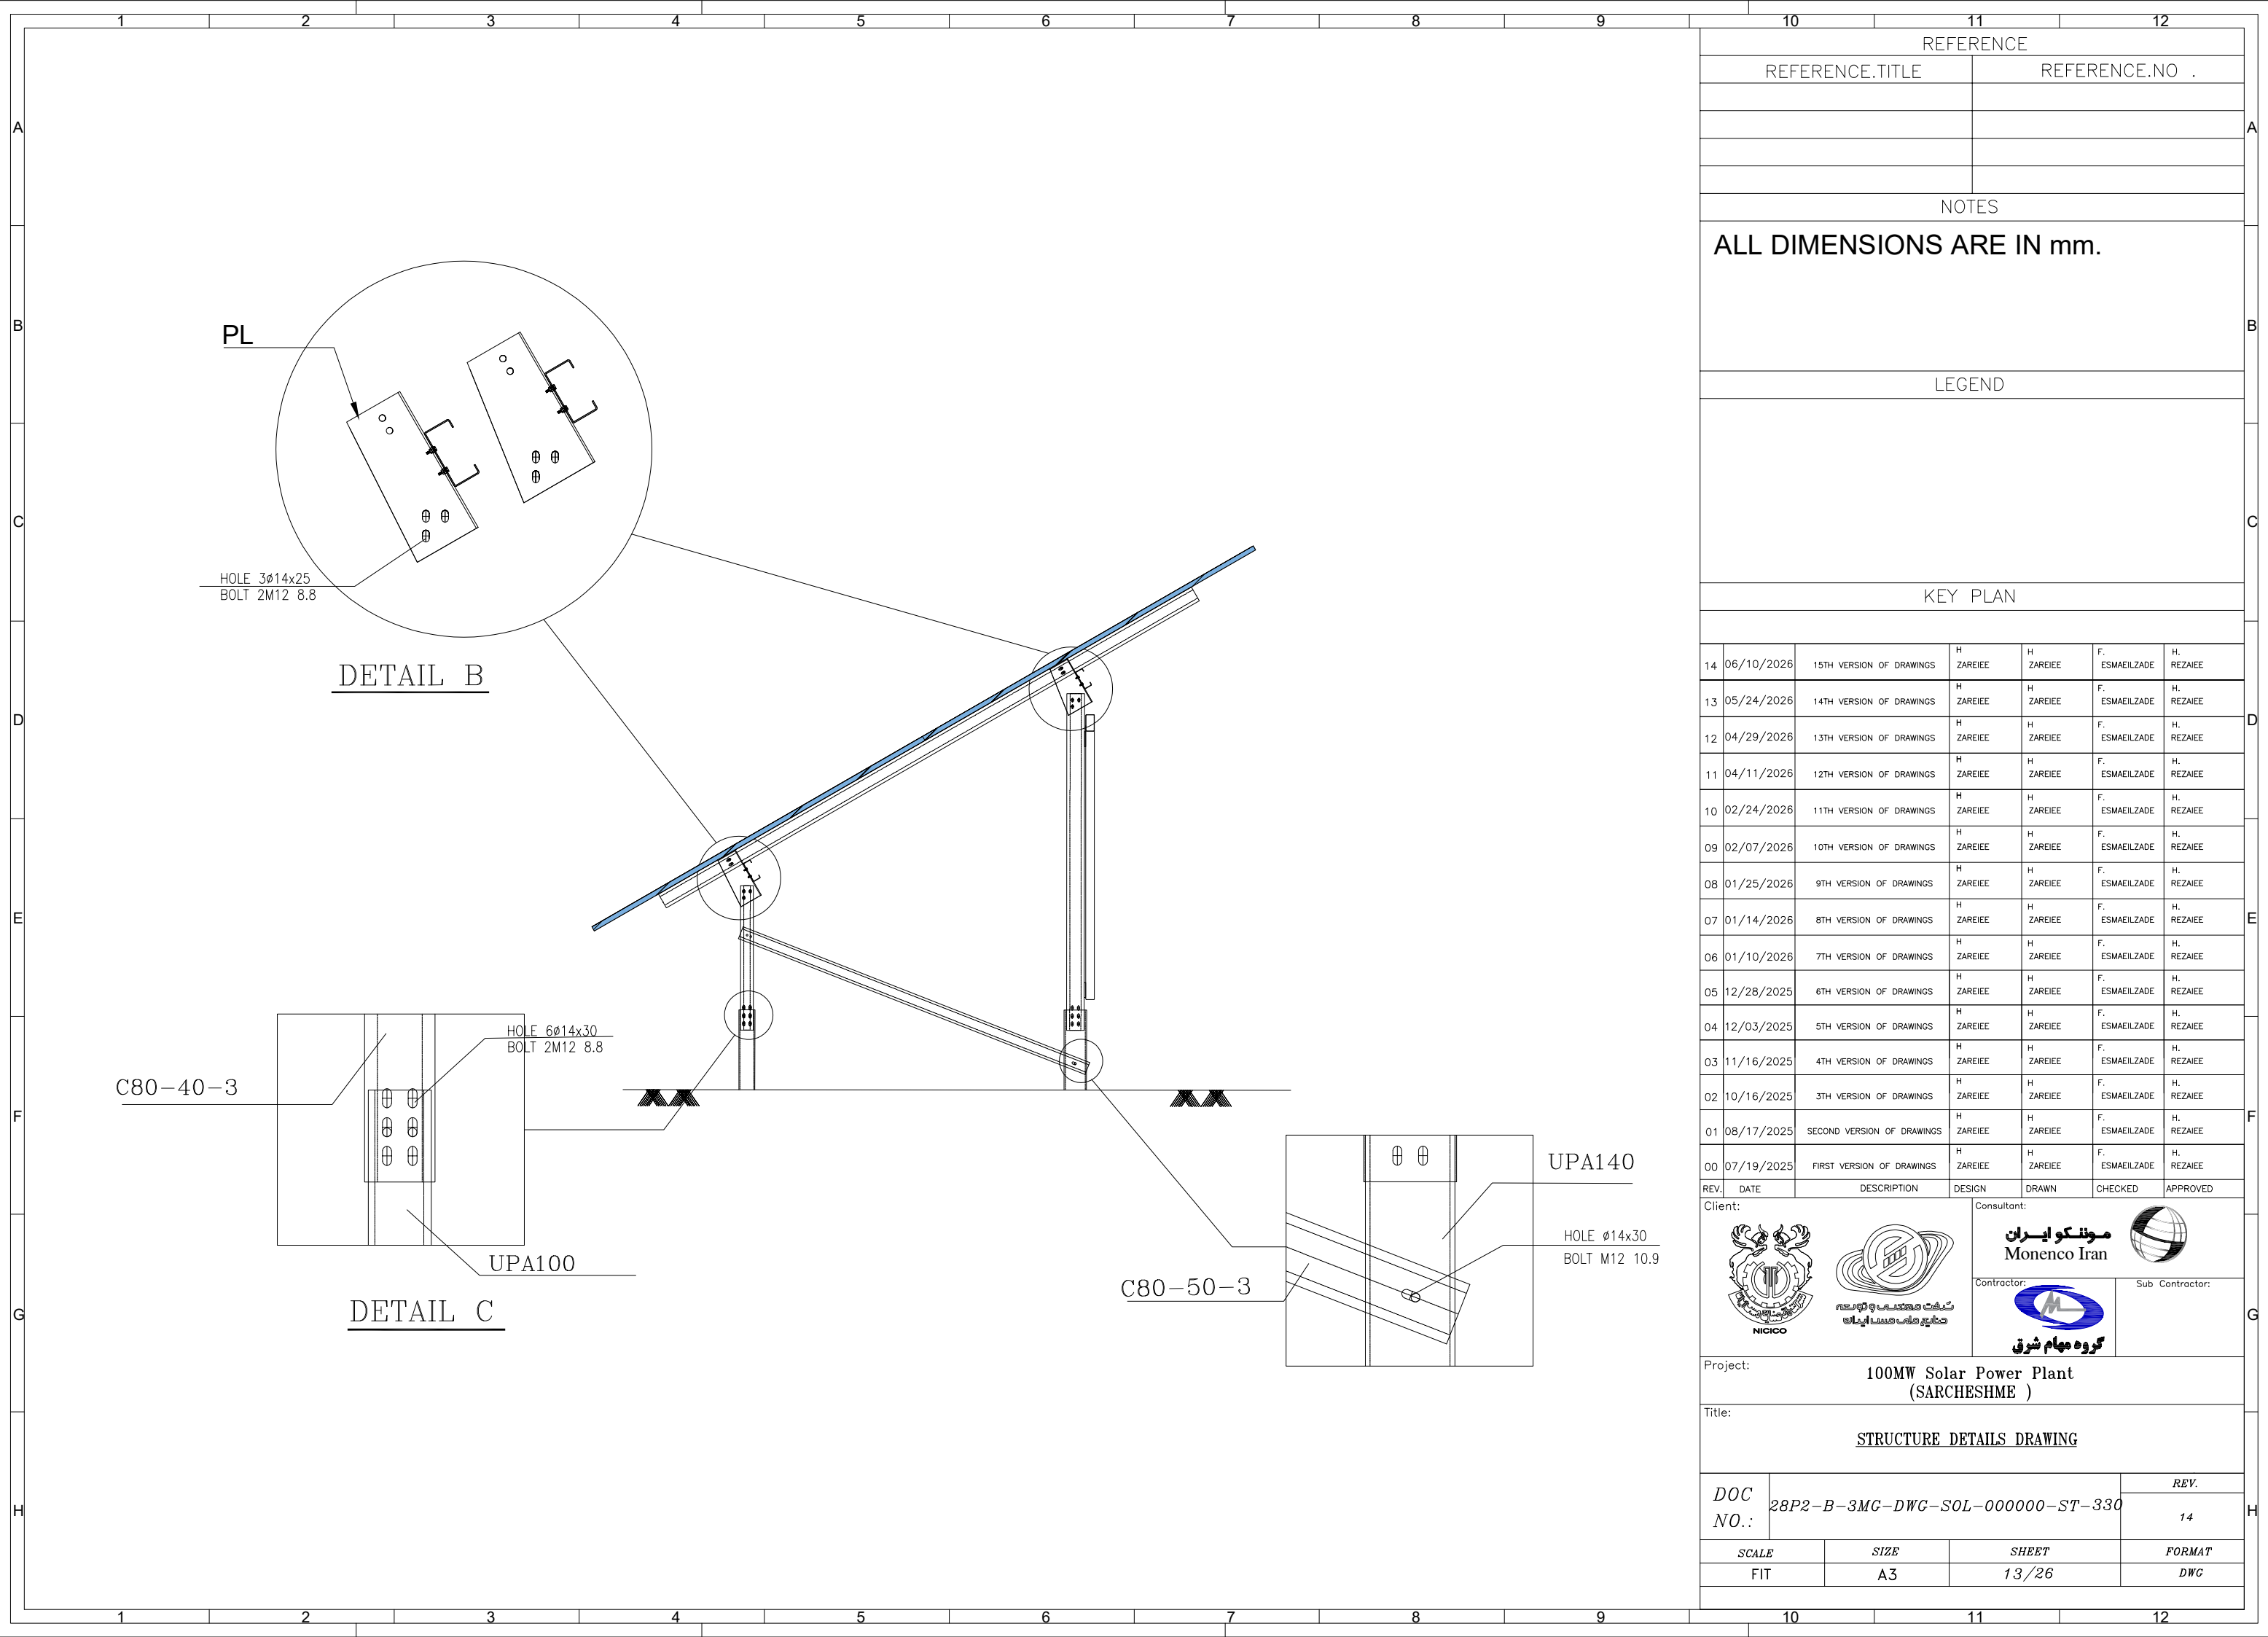









REFERENCE						
REFERENCE.TITLE			REFERENCE.NO .			
NOTES						
ALL DIMENSIONS ARE IN mm.						
LEGEND						
KEY PLAN						
14	06/10/2026	15TH VERSION OF DRAWINGS	H ZAREIEE	H ZAREIEE	F. ESMAEILZADE	H. REZAEIE
13	05/24/2026	14TH VERSION OF DRAWINGS	H ZAREIEE	H ZAREIEE	F. ESMAEILZADE	H. REZAEIE
12	04/29/2026	13TH VERSION OF DRAWINGS	H ZAREIEE	H ZAREIEE	F. ESMAEILZADE	H. REZAEIE
11	04/11/2026	12TH VERSION OF DRAWINGS	H ZAREIEE	H ZAREIEE	F. ESMAEILZADE	H. REZAEIE
10	02/24/2026	11TH VERSION OF DRAWINGS	H ZAREIEE	H ZAREIEE	F. ESMAEILZADE	H. REZAEIE
09	02/07/2026	10TH VERSION OF DRAWINGS	H ZAREIEE	H ZAREIEE	F. ESMAEILZADE	H. REZAEIE
08	01/25/2026	9TH VERSION OF DRAWINGS	H ZAREIEE	H ZAREIEE	F. ESMAEILZADE	H. REZAEIE
07	01/14/2026	8TH VERSION OF DRAWINGS	H ZAREIEE	H ZAREIEE	F. ESMAEILZADE	H. REZAEIE
06	01/10/2026	7TH VERSION OF DRAWINGS	H ZAREIEE	H ZAREIEE	F. ESMAEILZADE	H. REZAEIE
05	12/28/2025	6TH VERSION OF DRAWINGS	H ZAREIEE	H ZAREIEE	F. ESMAEILZADE	H. REZAEIE
04	12/03/2025	5TH VERSION OF DRAWINGS	H ZAREIEE	H ZAREIEE	F. ESMAEILZADE	H. REZAEIE
03	11/16/2025	4TH VERSION OF DRAWINGS	H ZAREIEE	H ZAREIEE	F. ESMAEILZADE	H. REZAEIE
02	10/16/2025	3TH VERSION OF DRAWINGS	H ZAREIEE	H ZAREIEE	F. ESMAEILZADE	H. REZAEIE
01	08/17/2025	SECOND VERSION OF DRAWINGS	H ZAREIEE	H ZAREIEE	F. ESMAEILZADE	H. REZAEIE
00	07/19/2025	FIRST VERSION OF DRAWINGS	H ZAREIEE	H ZAREIEE	F. ESMAEILZADE	H. REZAEIE
REV.	DATE	DESCRIPTION	DESIGN	DRAWN	CHECKED	APPROVED
Client:			Consultant:			
						
						
Contractor:			Sub Contractor:			
						
Project: 100MW Solar Power Plant (SARCHESHME)						
Title: STRUCTURE DETAILS DRAWING						
DOC NO.:	28P2-B-3MG-DWG-SOL-000000-ST-330				REV.	
						14
SCALE		SIZE		SHEET		FORMAT
FIT		A3		13/26		DWG

A
B
C
D
E
F
G
H




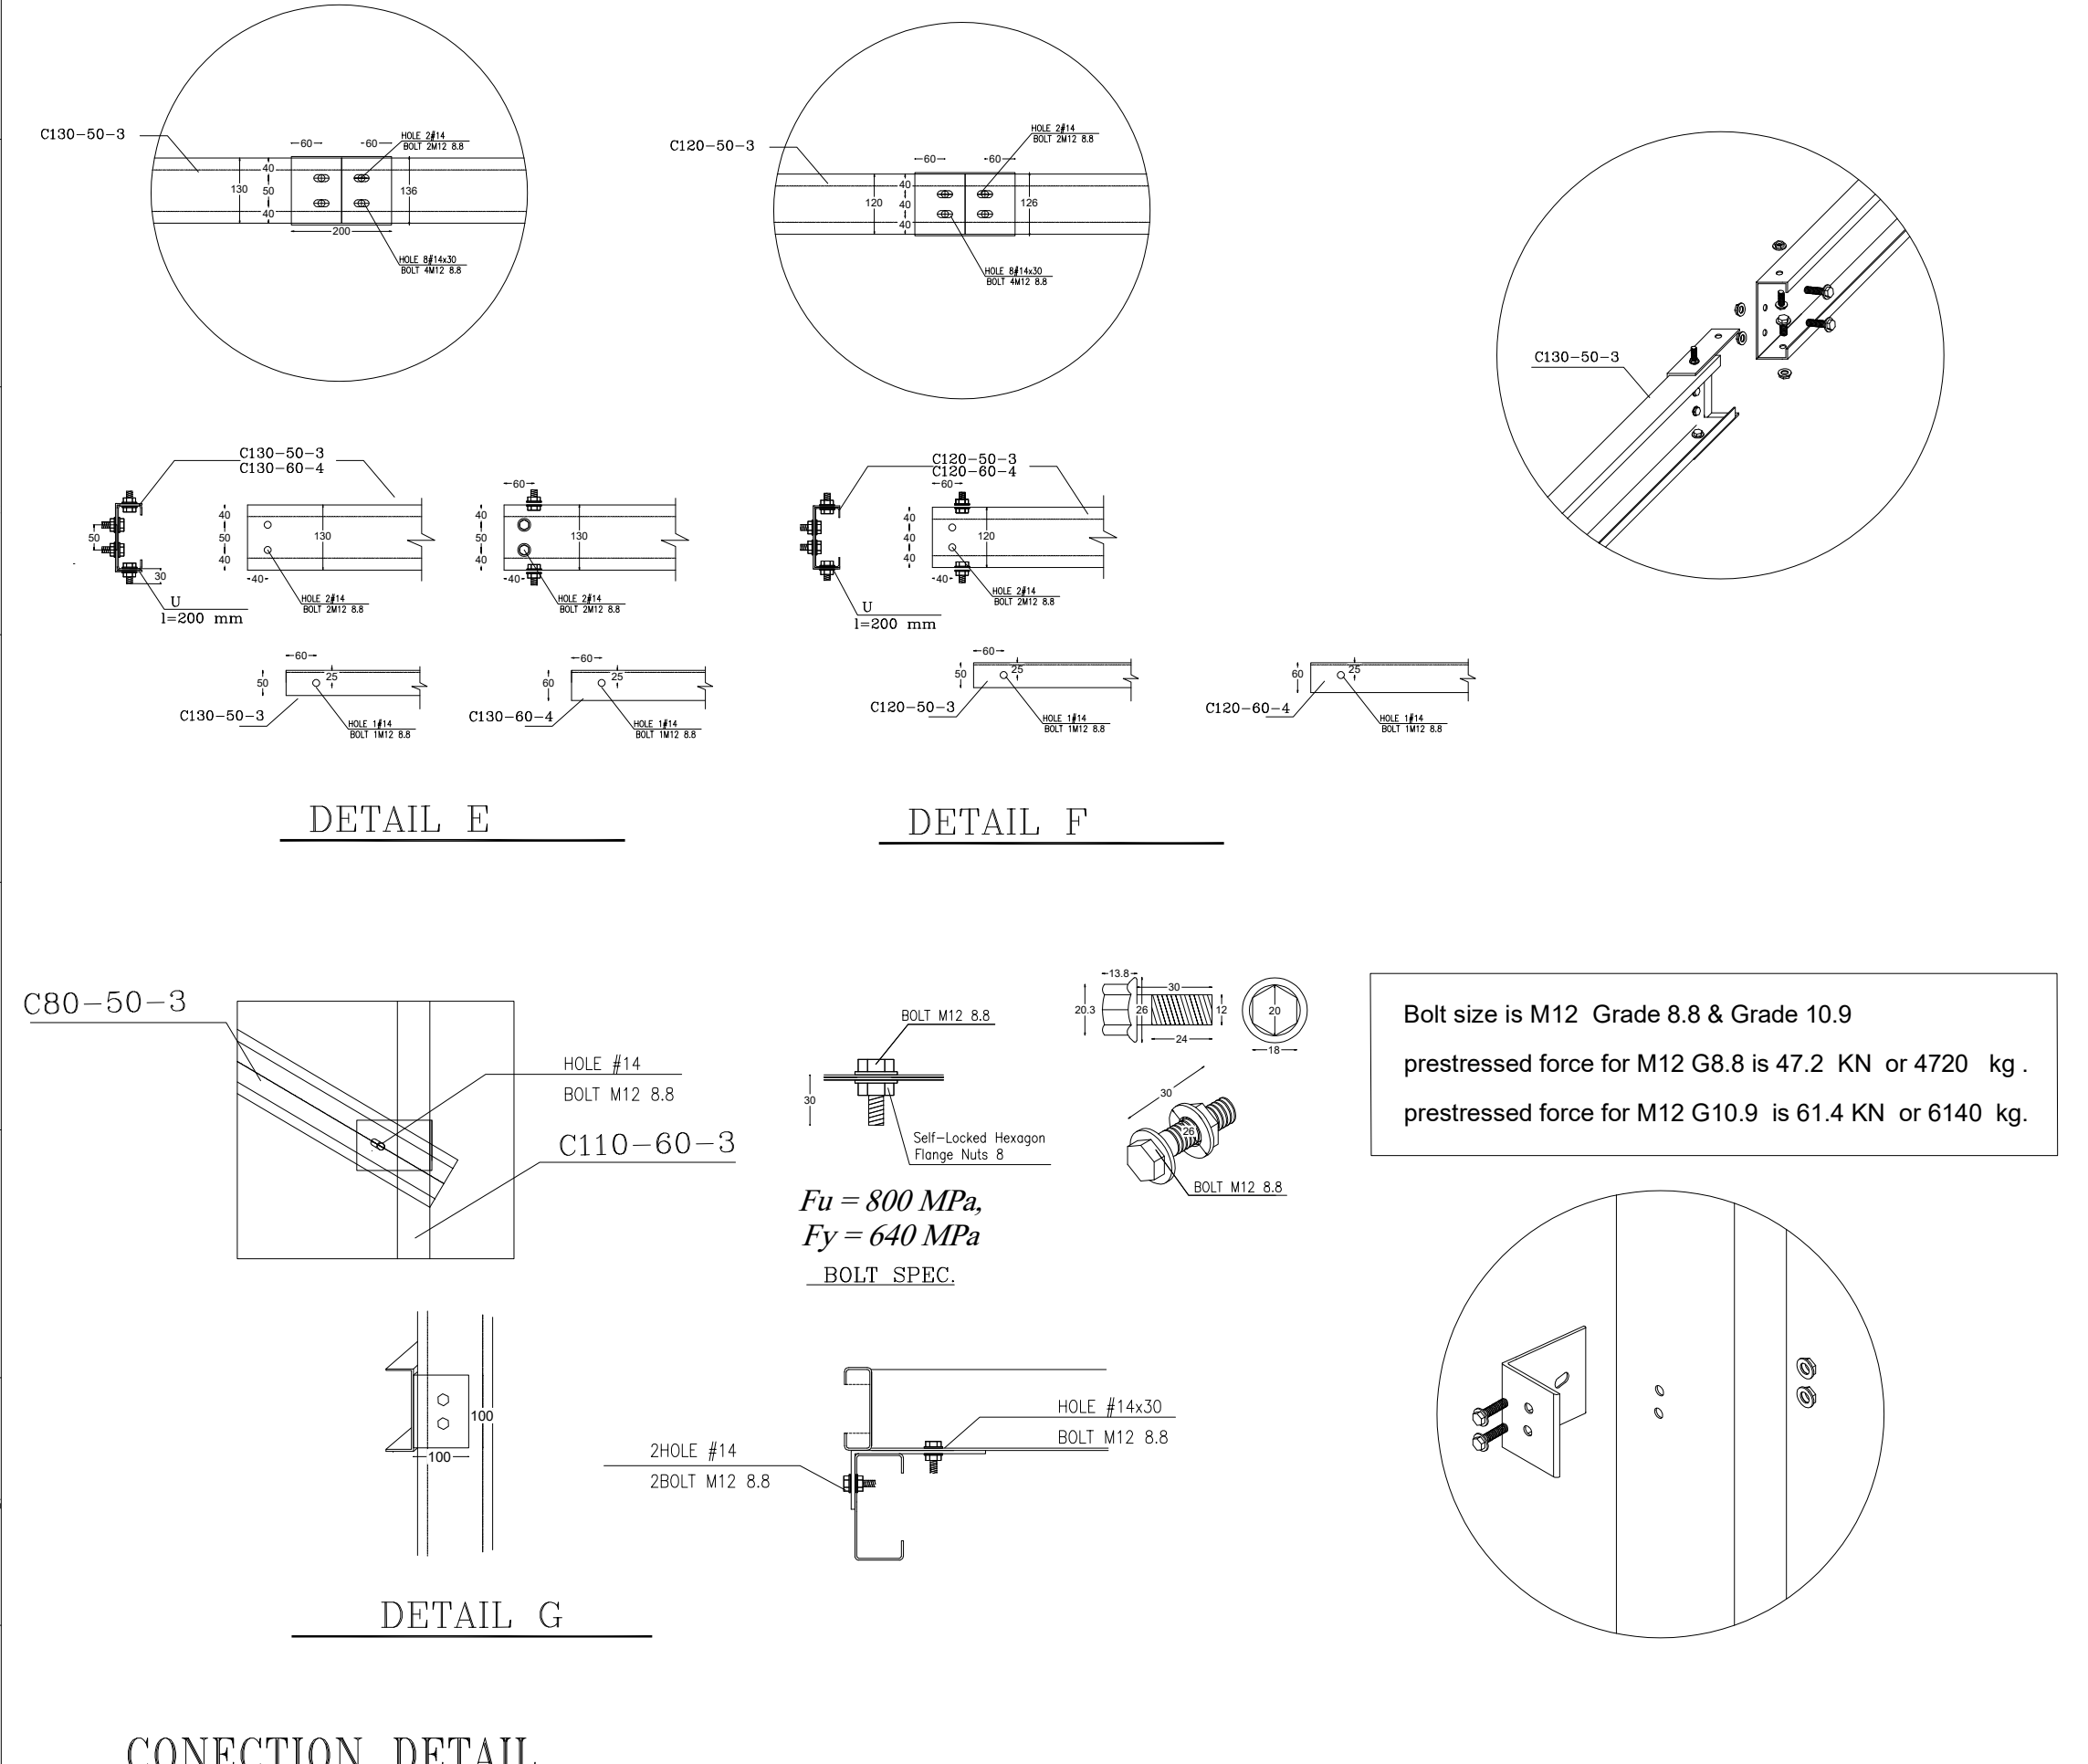


REFERENCE						
REFERENCE.TITLE			REFERENCE.NO .			
NOTES						
ALL DIMENSIONS ARE IN mm.						
LEGEND						
KEY PLAN						
14	06/10/2026	15TH VERSION OF DRAWINGS	H ZAREIEE	H ZAREIEE	F. ESMAEILZADE	H. REZAEIE
13	05/24/2026	14TH VERSION OF DRAWINGS	H ZAREIEE	H ZAREIEE	F. ESMAEILZADE	H. REZAEIE
12	04/29/2026	13TH VERSION OF DRAWINGS	H ZAREIEE	H ZAREIEE	F. ESMAEILZADE	H. REZAEIE
11	04/11/2026	12TH VERSION OF DRAWINGS	H ZAREIEE	H ZAREIEE	F. ESMAEILZADE	H. REZAEIE
10	02/24/2026	11TH VERSION OF DRAWINGS	H ZAREIEE	H ZAREIEE	F. ESMAEILZADE	H. REZAEIE
09	02/07/2026	10TH VERSION OF DRAWINGS	H ZAREIEE	H ZAREIEE	F. ESMAEILZADE	H. REZAEIE
08	01/25/2026	9TH VERSION OF DRAWINGS	H ZAREIEE	H ZAREIEE	F. ESMAEILZADE	H. REZAEIE
07	01/14/2026	8TH VERSION OF DRAWINGS	H ZAREIEE	H ZAREIEE	F. ESMAEILZADE	H. REZAEIE
06	01/10/2026	7TH VERSION OF DRAWINGS	H ZAREIEE	H ZAREIEE	F. ESMAEILZADE	H. REZAEIE
05	12/28/2025	6TH VERSION OF DRAWINGS	H ZAREIEE	H ZAREIEE	F. ESMAEILZADE	H. REZAEIE
04	12/03/2025	5TH VERSION OF DRAWINGS	H ZAREIEE	H ZAREIEE	F. ESMAEILZADE	H. REZAEIE
03	11/16/2025	4TH VERSION OF DRAWINGS	H ZAREIEE	H ZAREIEE	F. ESMAEILZADE	H. REZAEIE
02	10/16/2025	3TH VERSION OF DRAWINGS	H ZAREIEE	H ZAREIEE	F. ESMAEILZADE	H. REZAEIE
01	08/17/2025	SECOND VERSION OF DRAWINGS	H ZAREIEE	H ZAREIEE	F. ESMAEILZADE	H. REZAEIE
00	07/19/2025	FIRST VERSION OF DRAWINGS	H ZAREIEE	H ZAREIEE	F. ESMAEILZADE	H. REZAEIE
REV.	DATE	DESCRIPTION	DESIGN	DRAWN	CHECKED	APPROVED
Client:			Consultant:			
						
			Contractor:		Sub Contractor:	
						
Project: 100MW Solar Power Plant (SARCHESHME)						
Title: STRUCTURE DETAILS DRAWING						
DOC NO.:		28P2-B-3MG-DWG-SOL-000000-ST-330				REV.
						14
SCALE		SIZE		SHEET		FORMAT
FIT		A3		14 /26		DWG





CONECTION DETAIL
SC.1:10

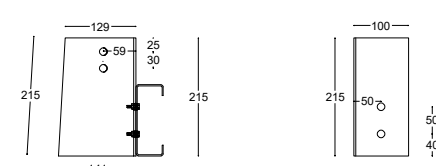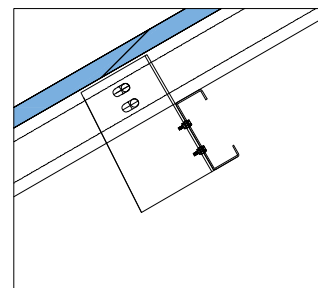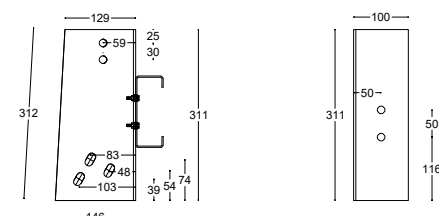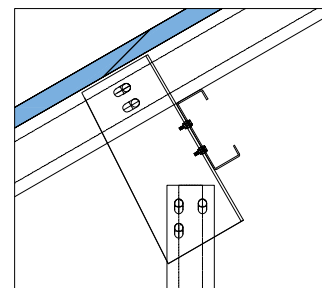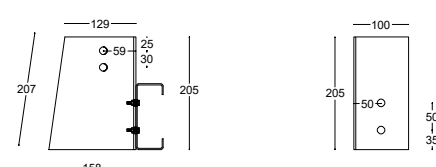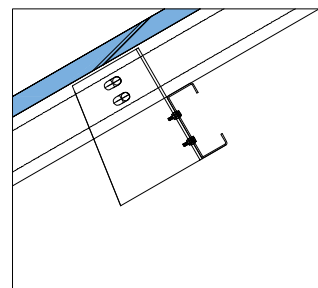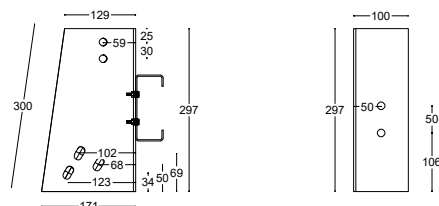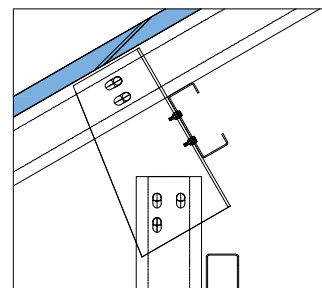

DETAIL A

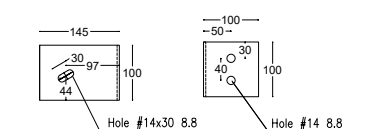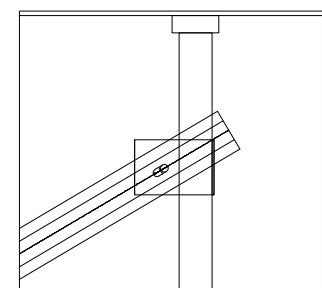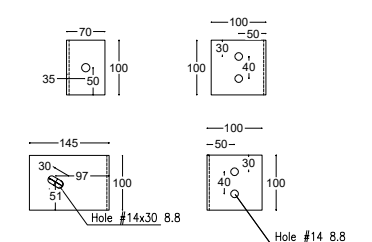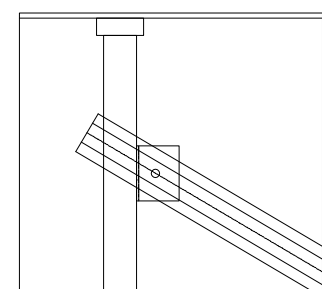








DETAIL G

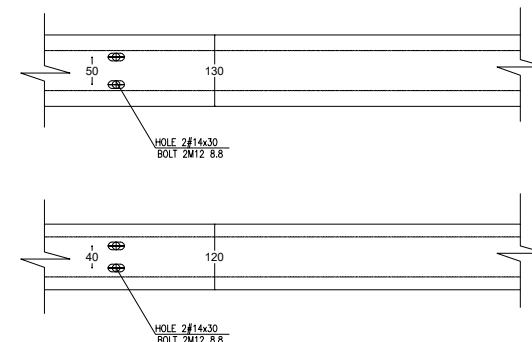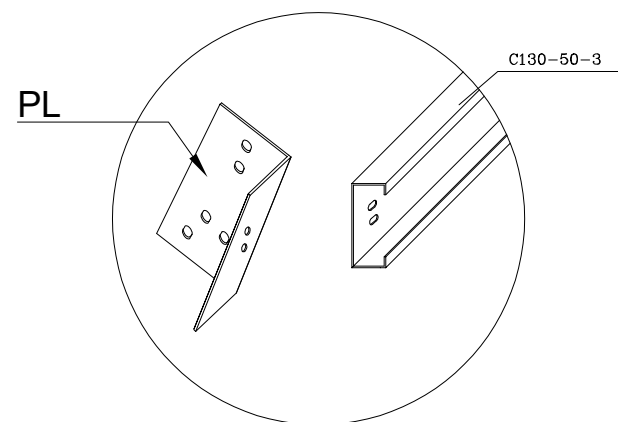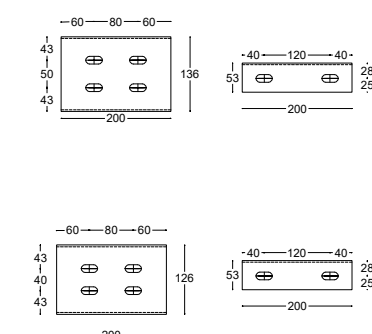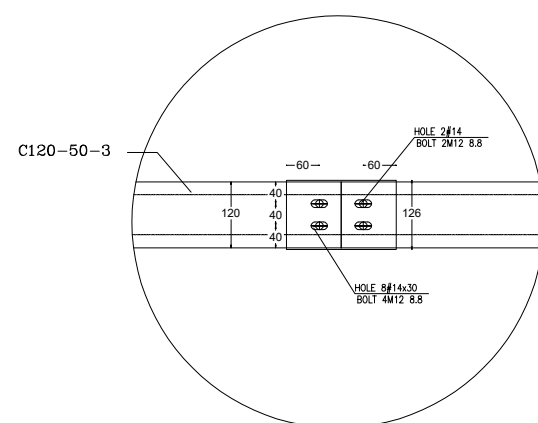


DETAIL E,F

REFERENCE						
REFERENCE.TITLE			REFERENCE.NO .			
NOTES						
ALL DIMENSIONS ARE IN mm.						
LEGEND						
KEY PLAN						
14	06/10/2026	15TH VERSION OF DRAWINGS	H ZAREIEE	H ZAREIEE	F. ESMAEILZADE	H. REZAEIE
13	05/24/2026	14TH VERSION OF DRAWINGS	H ZAREIEE	H ZAREIEE	F. ESMAEILZADE	H. REZAEIE
12	04/29/2026	13TH VERSION OF DRAWINGS	H ZAREIEE	H ZAREIEE	F. ESMAEILZADE	H. REZAEIE
11	04/11/2026	12TH VERSION OF DRAWINGS	H ZAREIEE	H ZAREIEE	F. ESMAEILZADE	H. REZAEIE
10	02/24/2026	11TH VERSION OF DRAWINGS	H ZAREIEE	H ZAREIEE	F. ESMAEILZADE	H. REZAEIE
09	02/07/2026	10TH VERSION OF DRAWINGS	H ZAREIEE	H ZAREIEE	F. ESMAEILZADE	H. REZAEIE
08	01/25/2026	9TH VERSION OF DRAWINGS	H ZAREIEE	H ZAREIEE	F. ESMAEILZADE	H. REZAEIE
07	01/14/2026	8TH VERSION OF DRAWINGS	H ZAREIEE	H ZAREIEE	F. ESMAEILZADE	H. REZAEIE
06	01/10/2026	7TH VERSION OF DRAWINGS	H ZAREIEE	H ZAREIEE	F. ESMAEILZADE	H. REZAEIE
05	12/28/2025	6TH VERSION OF DRAWINGS	H ZAREIEE	H ZAREIEE	F. ESMAEILZADE	H. REZAEIE
04	12/03/2025	5TH VERSION OF DRAWINGS	H ZAREIEE	H ZAREIEE	F. ESMAEILZADE	H. REZAEIE
03	11/16/2025	4TH VERSION OF DRAWINGS	H ZAREIEE	H ZAREIEE	F. ESMAEILZADE	H. REZAEIE
02	10/16/2025	3TH VERSION OF DRAWINGS	H ZAREIEE	H ZAREIEE	F. ESMAEILZADE	H. REZAEIE
01	08/17/2025	SECOND VERSION OF DRAWINGS	H ZAREIEE	H ZAREIEE	F. ESMAEILZADE	H. REZAEIE
00	07/19/2025	FIRST VERSION OF DRAWINGS	H ZAREIEE	H ZAREIEE	F. ESMAEILZADE	H. REZAEIE
REV.	DATE	DESCRIPTION	DESIGN	DRAWN	CHECKED	APPROVED
Client:			Consultant:			
 NICICO			 شماره ثبت: ۱۳۸۴۰۰۰۰۰۰۰۰ دفتر: تهران، خیابان ولیعصر			 موتنکو ایران Monenco Iran
			Contractor:		Sub Contractor:	
			 گروه مہام شرق			
Project: 100MW Solar Power Plant (SARCHESHME)						
Title: Structure Shop Drawing						
DOC NO.:		28P2-B-3MG-DWG-SOL-000000-ST-330			REV.	
					14	
SCALE		SIZE		SHEET		FORMAT
FIT		A3		15/26		DWG


A
B
C
D
E
F
G
H

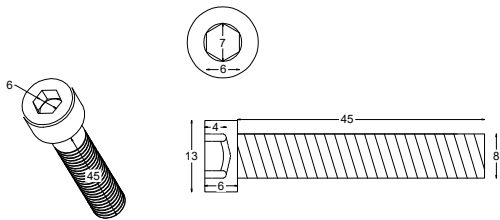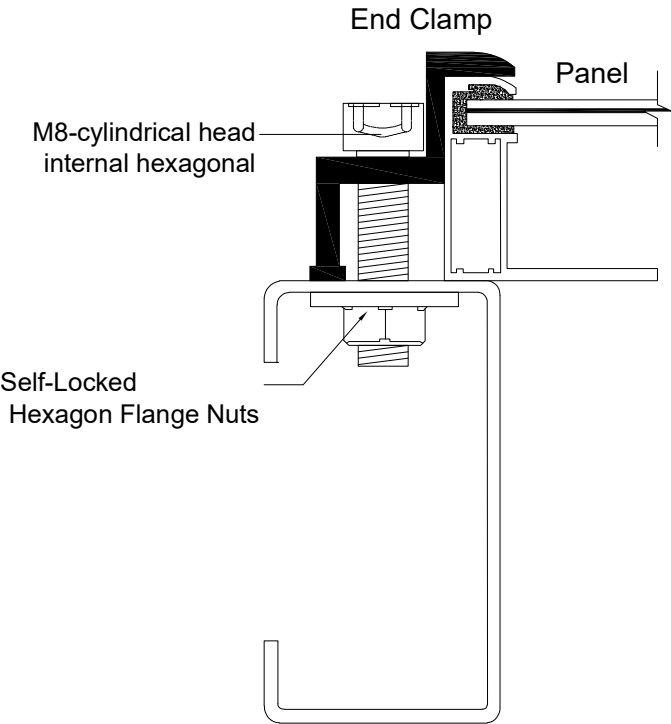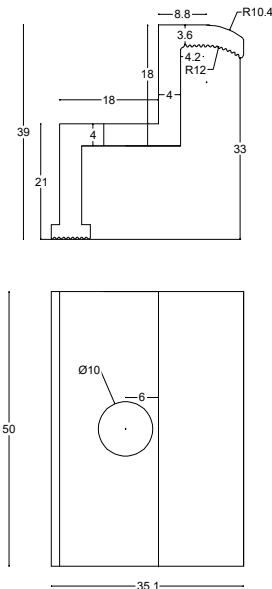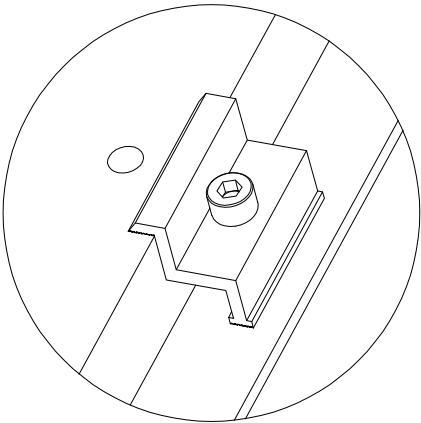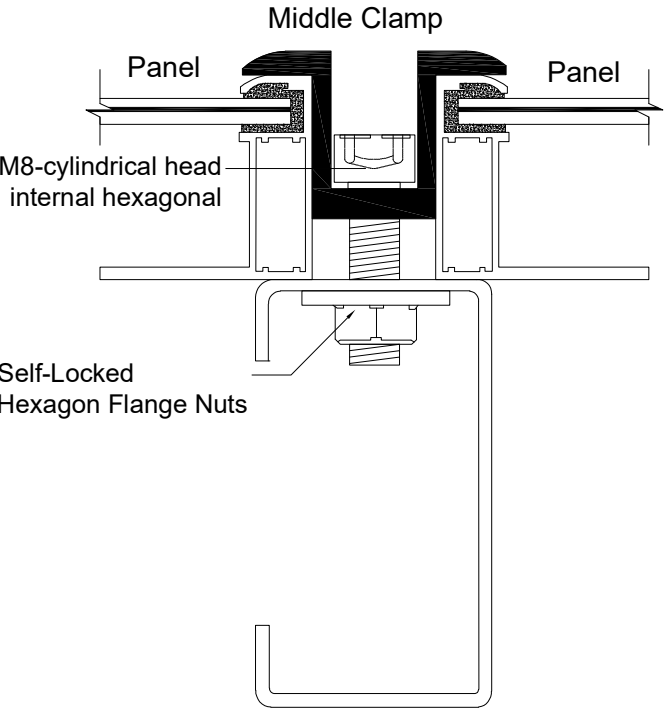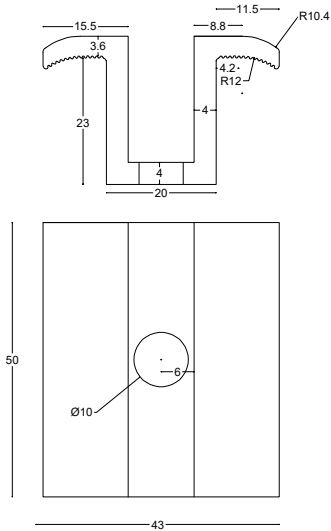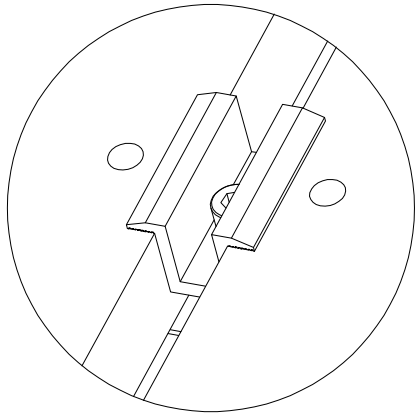



prestressed force for M8 G8.8 is 22.75 KN or 2275 kg .

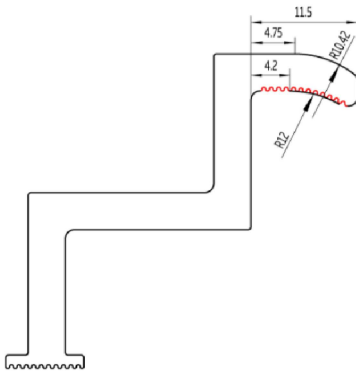


Trina solar-pg 17

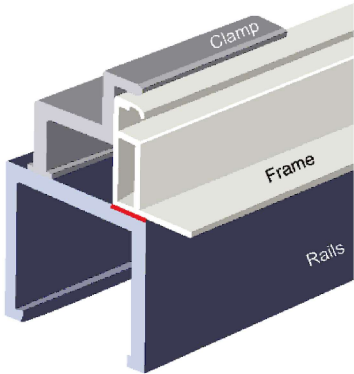


Trina solar-pg 16

  REFERENCE						
REFERENCE.TITLE			REFERENCE.NO .			
NOTES						
ALL DIMENSIONS ARE IN mm.						
LEGEND						
KEY PLAN						
14	06/10/2026	15TH VERSION OF DRAWINGS	H ZAREIEE	H ZAREIEE	F. ESMAEILZADE	H. REZAIEE
13	05/24/2026	14TH VERSION OF DRAWINGS	H ZAREIEE	H ZAREIEE	F. ESMAEILZADE	H. REZAIEE
12	04/29/2026	13TH VERSION OF DRAWINGS	H ZAREIEE	H ZAREIEE	F. ESMAEILZADE	H. REZAIEE
11	04/11/2026	12TH VERSION OF DRAWINGS	H ZAREIEE	H ZAREIEE	F. ESMAEILZADE	H. REZAIEE
10	02/24/2026	11TH VERSION OF DRAWINGS	H ZAREIEE	H ZAREIEE	F. ESMAEILZADE	H. REZAIEE
09	02/07/2026	10TH VERSION OF DRAWINGS	H ZAREIEE	H ZAREIEE	F. ESMAEILZADE	H. REZAIEE
08	01/25/2026	9TH VERSION OF DRAWINGS	H ZAREIEE	H ZAREIEE	F. ESMAEILZADE	H. REZAIEE
07	01/14/2026	8TH VERSION OF DRAWINGS	H ZAREIEE	H ZAREIEE	F. ESMAEILZADE	H. REZAIEE
06	01/10/2026	7TH VERSION OF DRAWINGS	H ZAREIEE	H ZAREIEE	F. ESMAEILZADE	H. REZAIEE
05	12/28/2025	6TH VERSION OF DRAWINGS	H ZAREIEE	H ZAREIEE	F. ESMAEILZADE	H. REZAIEE
04	12/03/2025	5TH VERSION OF DRAWINGS	H ZAREIEE	H ZAREIEE	F. ESMAEILZADE	H. REZAIEE
03	11/16/2025	4TH VERSION OF DRAWINGS	H ZAREIEE	H ZAREIEE	F. ESMAEILZADE	H. REZAIEE
02	10/16/2025	3TH VERSION OF DRAWINGS	H ZAREIEE	H ZAREIEE	F. ESMAEILZADE	H. REZAIEE
01	08/17/2025	SECOND VERSION OF DRAWINGS	H ZAREIEE	H ZAREIEE	F. ESMAEILZADE	H. REZAIEE
00	07/19/2025	FIRST VERSION OF DRAWINGS	H ZAREIEE	H ZAREIEE	F. ESMAEILZADE	H. REZAIEE
REV.	DATE	DESCRIPTION	DESIGN	DRAWN	CHECKED	APPROVED
Client:			Consultant:			
						
						
Contractor:			Sub Contractor:			
						
Project: 100MW Solar Power Plant (SARCHESHME)						
Title: Structure Shop Drawing						
DOC NO.:	28P2-B-3MG-DWC-SOL-000000-ST-330				REV. 14	
SCALE		SIZE		SHEET		FORMAT
FIT		A3		16/26		DWC

A
B
C
D
E
F
G
H

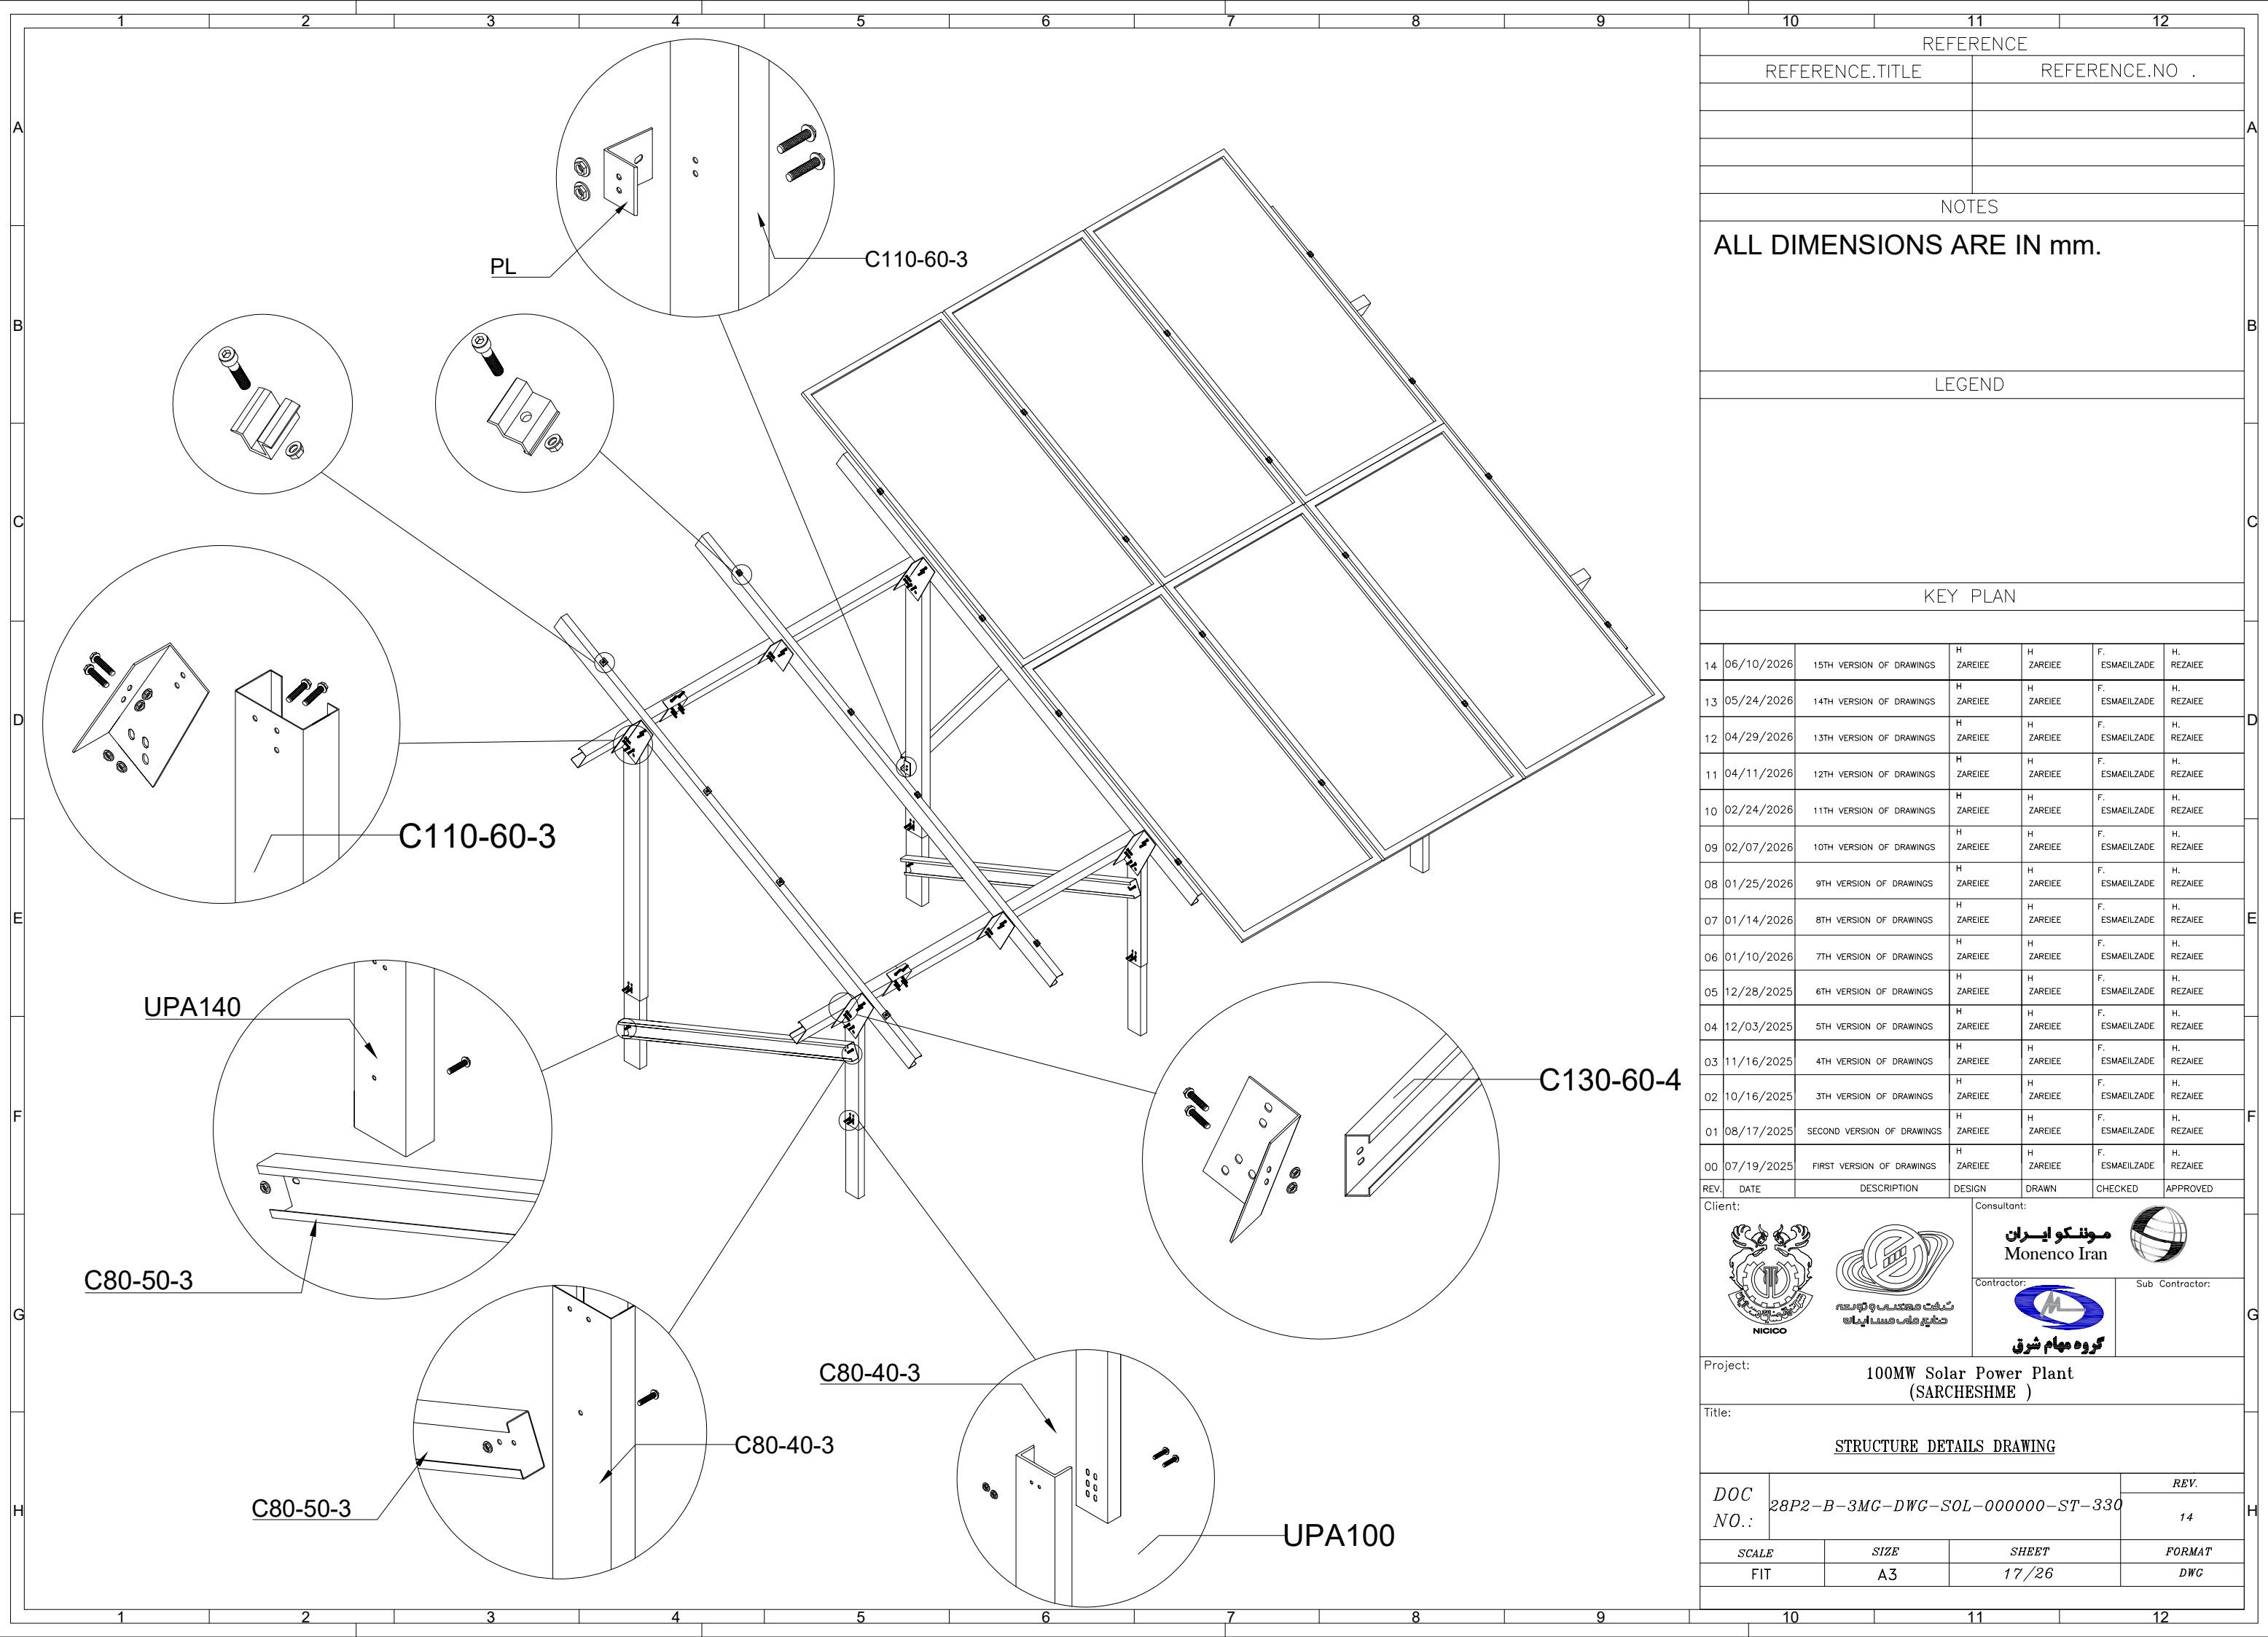

REFERENCE						
REFERENCE.TITLE			REFERENCE.NO .			
NOTES						
ALL DIMENSIONS ARE IN mm.						
LEGEND						
KEY PLAN						
14	06/10/2026	15TH VERSION OF DRAWINGS	H ZAREIEE	H ZAREIEE	F. ESMAEILZADE	H. REZAIEE
13	05/24/2026	14TH VERSION OF DRAWINGS	H ZAREIEE	H ZAREIEE	F. ESMAEILZADE	H. REZAIEE
12	04/29/2026	13TH VERSION OF DRAWINGS	H ZAREIEE	H ZAREIEE	F. ESMAEILZADE	H. REZAIEE
11	04/11/2026	12TH VERSION OF DRAWINGS	H ZAREIEE	H ZAREIEE	F. ESMAEILZADE	H. REZAIEE
10	02/24/2026	11TH VERSION OF DRAWINGS	H ZAREIEE	H ZAREIEE	F. ESMAEILZADE	H. REZAIEE
09	02/07/2026	10TH VERSION OF DRAWINGS	H ZAREIEE	H ZAREIEE	F. ESMAEILZADE	H. REZAIEE
08	01/25/2026	9TH VERSION OF DRAWINGS	H ZAREIEE	H ZAREIEE	F. ESMAEILZADE	H. REZAIEE
07	01/14/2026	8TH VERSION OF DRAWINGS	H ZAREIEE	H ZAREIEE	F. ESMAEILZADE	H. REZAIEE
06	01/10/2026	7TH VERSION OF DRAWINGS	H ZAREIEE	H ZAREIEE	F. ESMAEILZADE	H. REZAIEE
05	12/28/2025	6TH VERSION OF DRAWINGS	H ZAREIEE	H ZAREIEE	F. ESMAEILZADE	H. REZAIEE
04	12/03/2025	5TH VERSION OF DRAWINGS	H ZAREIEE	H ZAREIEE	F. ESMAEILZADE	H. REZAIEE
03	11/16/2025	4TH VERSION OF DRAWINGS	H ZAREIEE	H ZAREIEE	F. ESMAEILZADE	H. REZAIEE
02	10/16/2025	3TH VERSION OF DRAWINGS	H ZAREIEE	H ZAREIEE	F. ESMAEILZADE	H. REZAIEE
01	08/17/2025	SECOND VERSION OF DRAWINGS	H ZAREIEE	H ZAREIEE	F. ESMAEILZADE	H. REZAIEE
00	07/19/2025	FIRST VERSION OF DRAWINGS	H ZAREIEE	H ZAREIEE	F. ESMAEILZADE	H. REZAIEE
REV.	DATE	DESCRIPTION	DESIGN	DRAWN	CHECKED	APPROVED
Client:			Consultant:			
						
			Contractor:		Sub Contractor:	
						
Project: 100MW Solar Power Plant (SARCHESHME)						
Title: STRUCTURE DETAILS DRAWING						
DOC NO.:		28P2-B-3MG-DWC-SOL-000000-ST-330				REV. 14
SCALE		SIZE		SHEET		FORMAT
FIT		A3		17/26		DWG

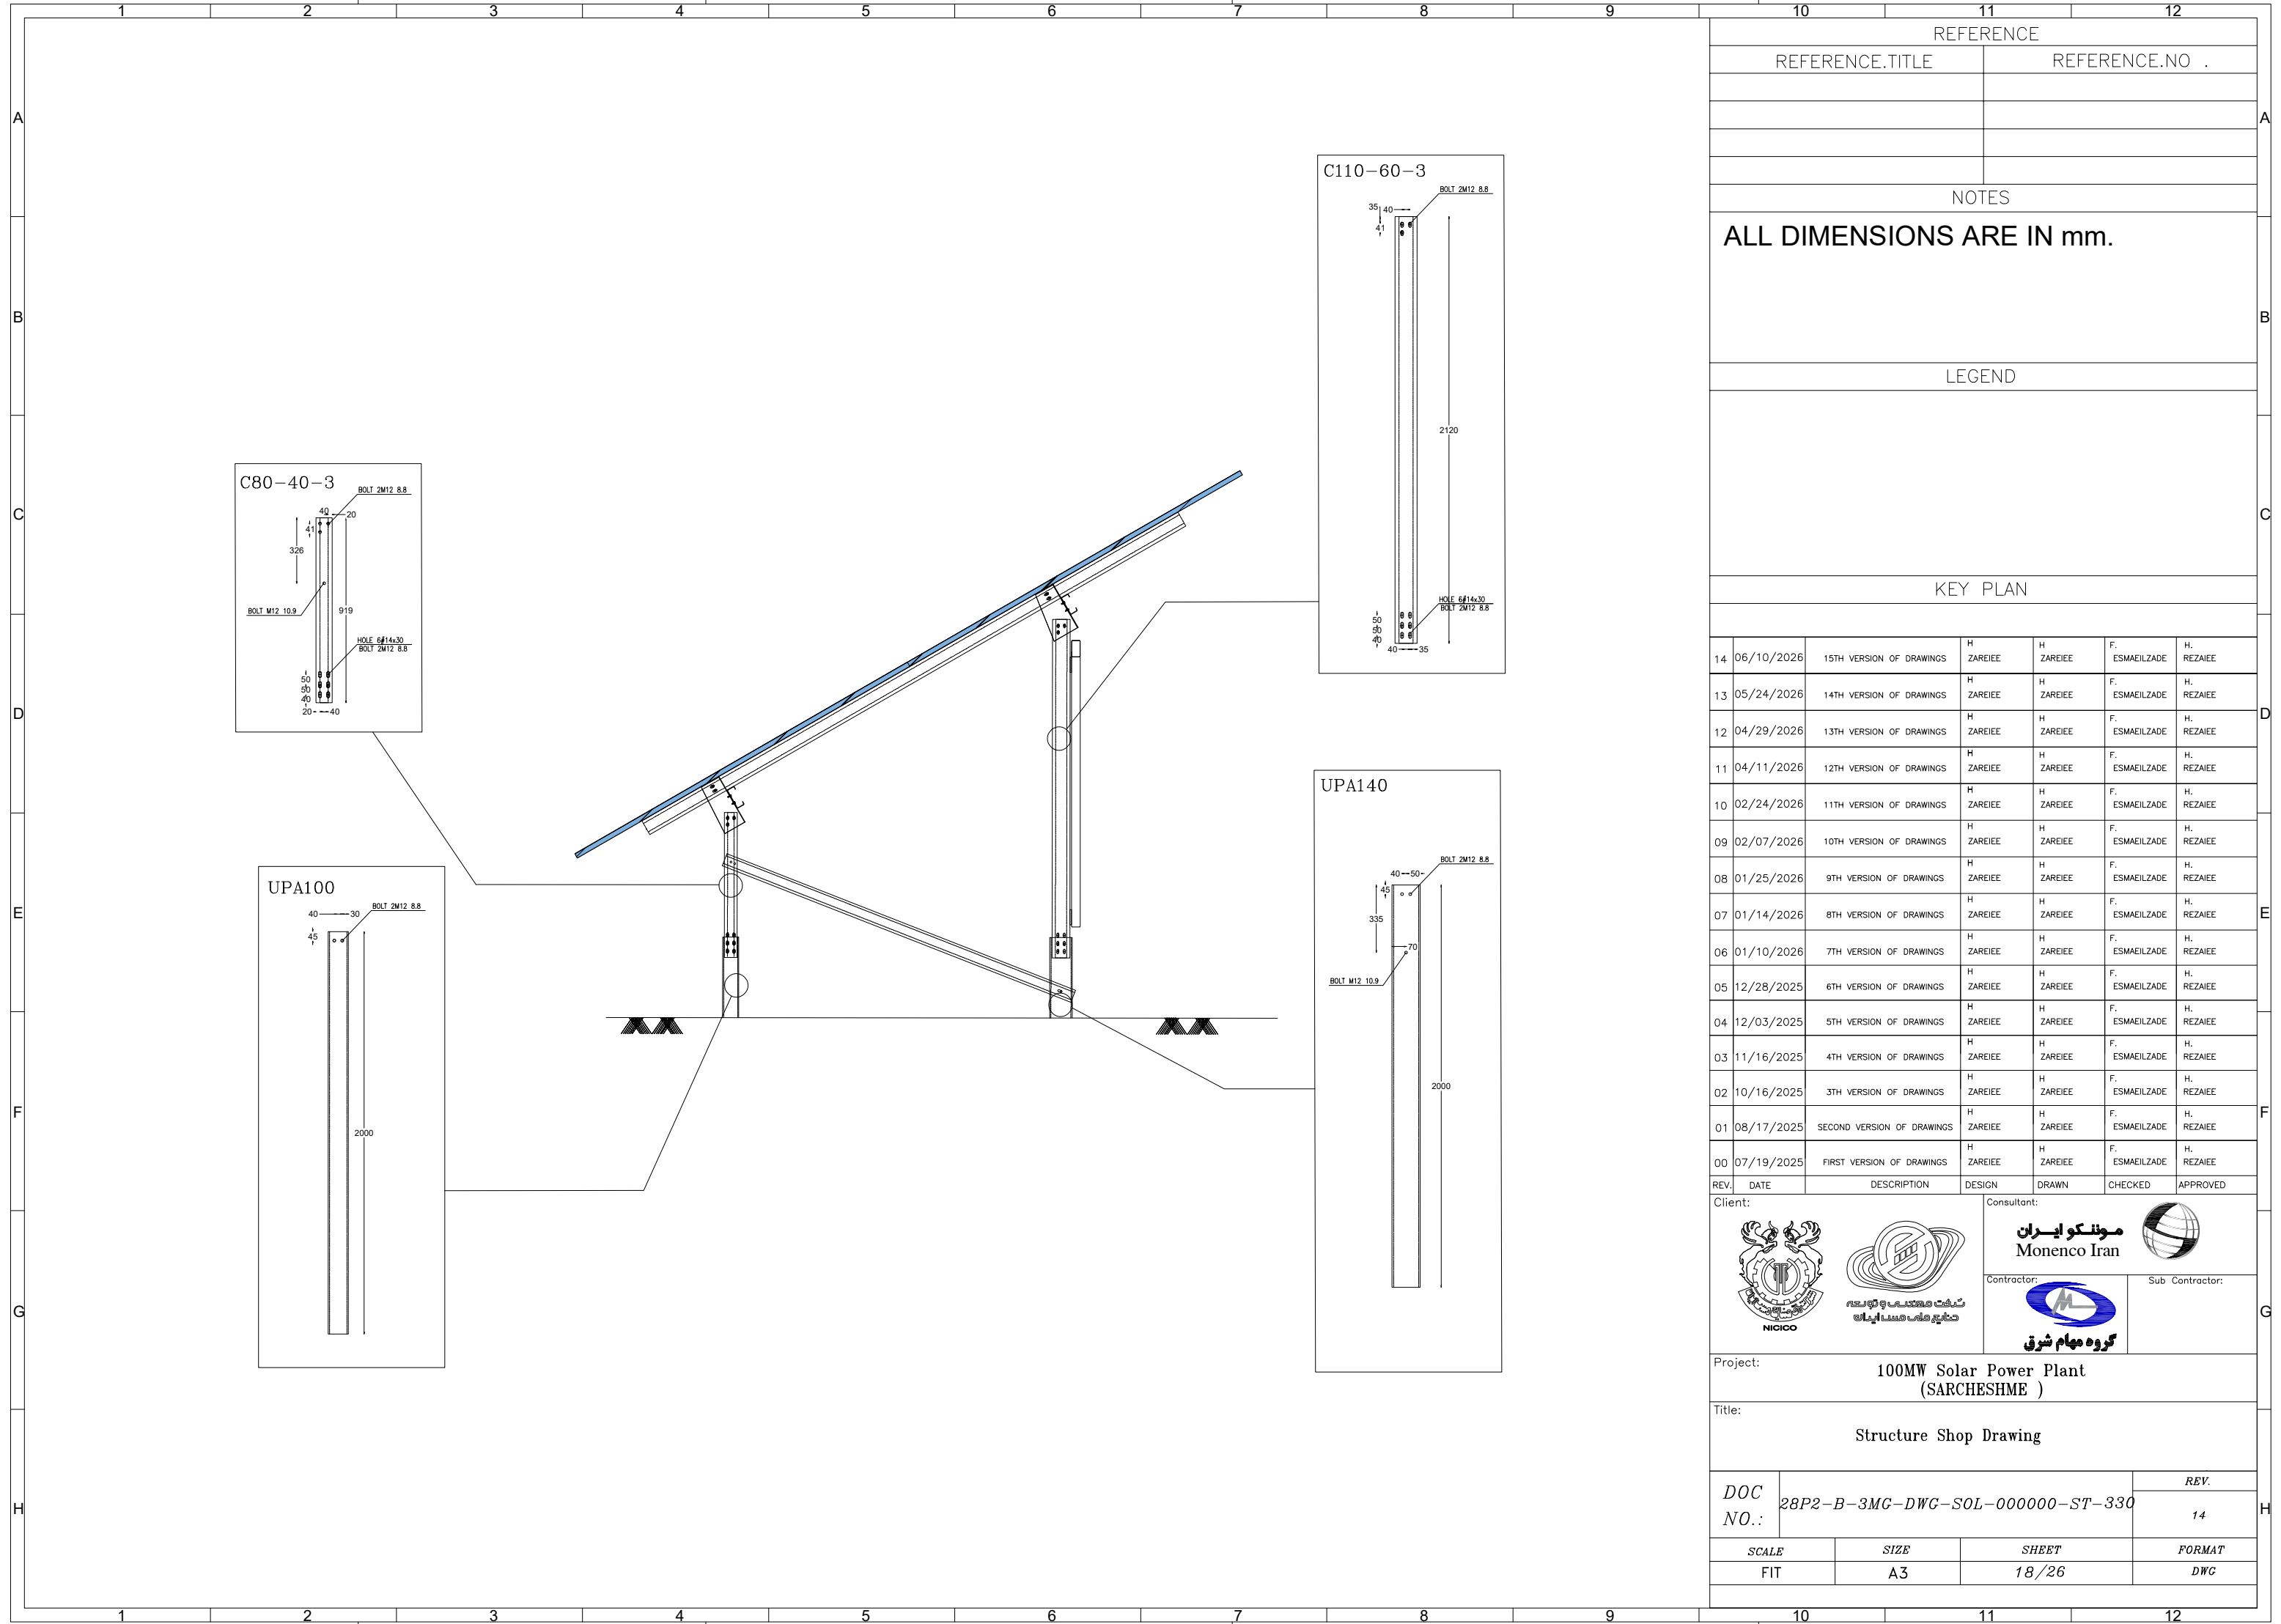

REFERENCE	
REFERENCE.TITLE	REFERENCE.NO .

NOTES	
ALL DIMENSIONS ARE IN mm.	

LEGEND	


KEY PLAN	
----------	--

14	06/10/2026	15TH VERSION OF DRAWINGS	H. ZAREIEE	H. ZAREIEE	F. ESMAEILZADE	H. REZAIEE
13	05/24/2026	14TH VERSION OF DRAWINGS	H. ZAREIEE	H. ZAREIEE	F. ESMAEILZADE	H. REZAIEE
12	04/29/2026	13TH VERSION OF DRAWINGS	H. ZAREIEE	H. ZAREIEE	F. ESMAEILZADE	H. REZAIEE
11	04/11/2026	12TH VERSION OF DRAWINGS	H. ZAREIEE	H. ZAREIEE	F. ESMAEILZADE	H. REZAIEE
10	02/24/2026	11TH VERSION OF DRAWINGS	H. ZAREIEE	H. ZAREIEE	F. ESMAEILZADE	H. REZAIEE
09	02/07/2026	10TH VERSION OF DRAWINGS	H. ZAREIEE	H. ZAREIEE	F. ESMAEILZADE	H. REZAIEE
08	01/25/2026	9TH VERSION OF DRAWINGS	H. ZAREIEE	H. ZAREIEE	F. ESMAEILZADE	H. REZAIEE
07	01/14/2026	8TH VERSION OF DRAWINGS	H. ZAREIEE	H. ZAREIEE	F. ESMAEILZADE	H. REZAIEE
06	01/10/2026	7TH VERSION OF DRAWINGS	H. ZAREIEE	H. ZAREIEE	F. ESMAEILZADE	H. REZAIEE
05	12/28/2025	6TH VERSION OF DRAWINGS	H. ZAREIEE	H. ZAREIEE	F. ESMAEILZADE	H. REZAIEE
04	12/03/2025	5TH VERSION OF DRAWINGS	H. ZAREIEE	H. ZAREIEE	F. ESMAEILZADE	H. REZAIEE
03	11/16/2025	4TH VERSION OF DRAWINGS	H. ZAREIEE	H. ZAREIEE	F. ESMAEILZADE	H. REZAIEE
02	10/16/2025	3TH VERSION OF DRAWINGS	H. ZAREIEE	H. ZAREIEE	F. ESMAEILZADE	H. REZAIEE
01	08/17/2025	SECOND VERSION OF DRAWINGS	H. ZAREIEE	H. ZAREIEE	F. ESMAEILZADE	H. REZAIEE
00	07/19/2025	FIRST VERSION OF DRAWINGS	H. ZAREIEE	H. ZAREIEE	F. ESMAEILZADE	H. REZAIEE
REV.	DATE	DESCRIPTION	DESIGN	DRAWN	CHECKED	APPROVED

Client:



 
Consultant:



Contractor:



 
Sub Contractor:




Project: 100MW Solar Power Plant (SARCHESHME)

Title: Structure Shop Drawing


DOC NO.:	28P2-B-3MG-DWC-SOL-000000-ST-330			REV.
				14
SCALE		SIZE	SHEET	FORMAT
FIT		A3	18/26	DWG

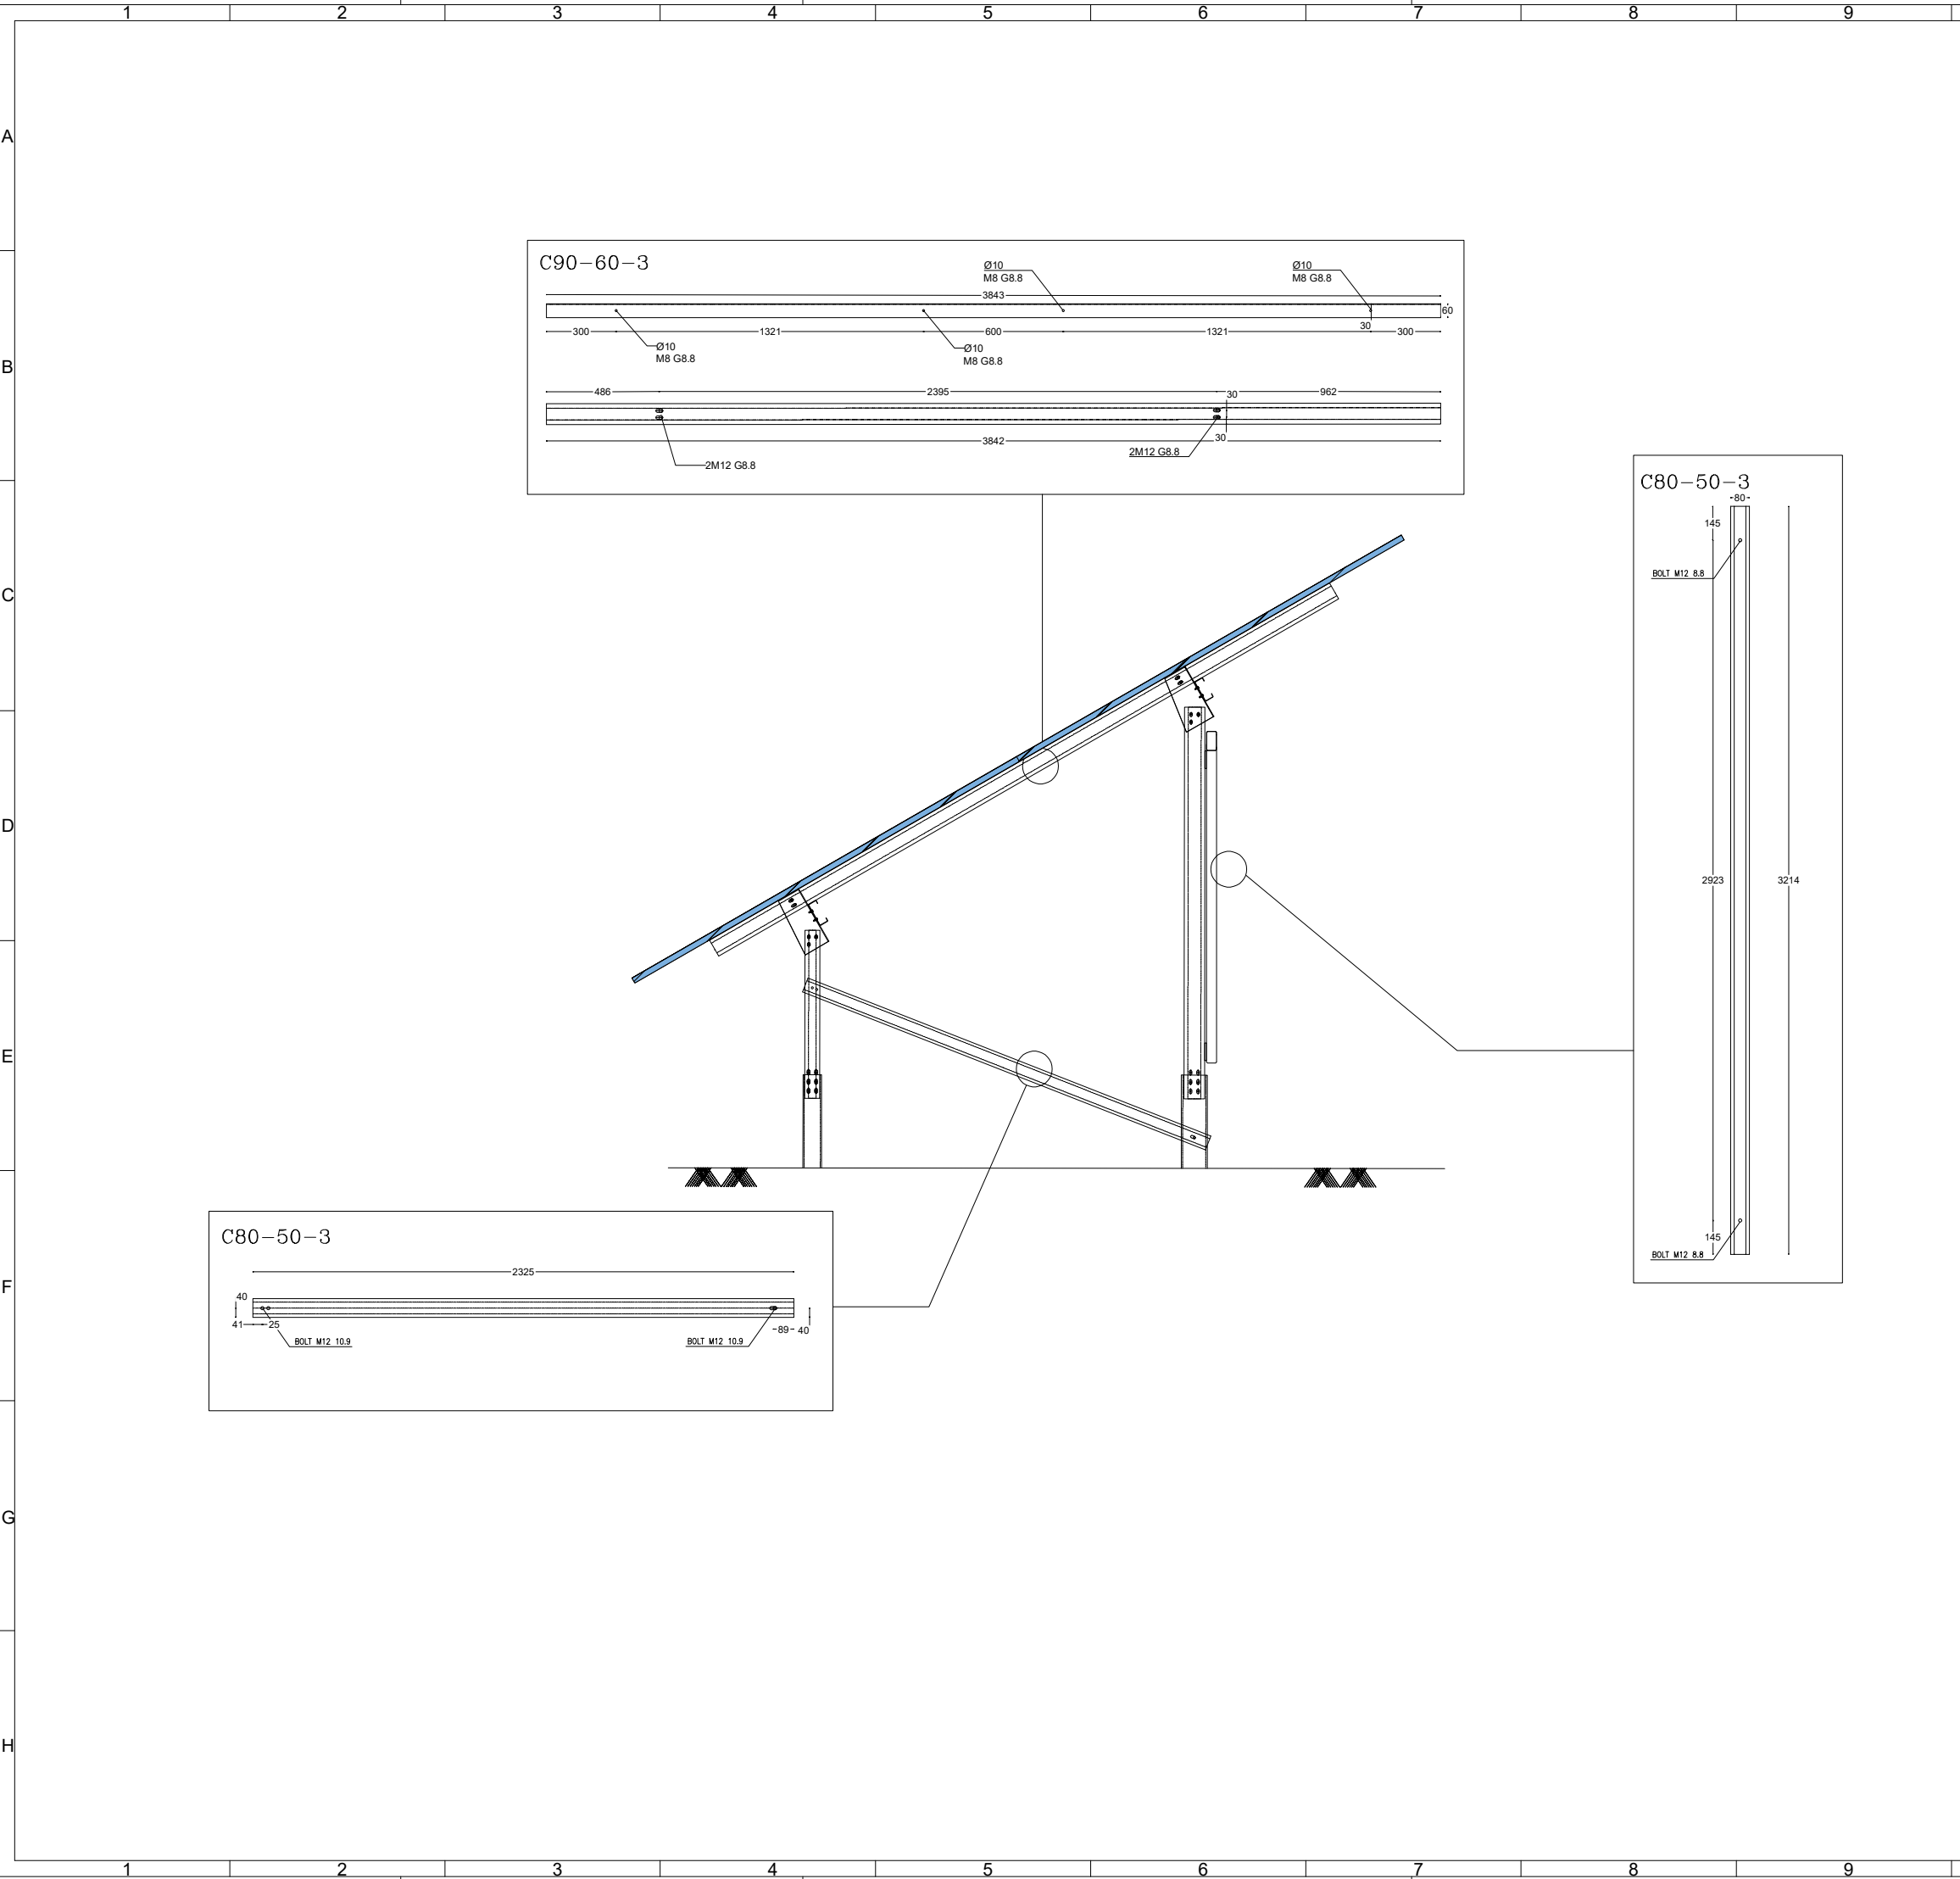

10		11		12	
REFERENCE					
REFERENCE.TITLE			REFERENCE.NO .		
NOTES					
ALL DIMENSIONS ARE IN mm.					
LEGEND					
KEY PLAN					
14	06/10/2026	15TH VERSION OF DRAWINGS	H. ZAREIEE	H. ZAREIEE	F. ESMAEILZADE H. REZAEIEE
13	05/24/2026	14TH VERSION OF DRAWINGS	H. ZAREIEE	H. ZAREIEE	F. ESMAEILZADE H. REZAEIEE
12	04/29/2026	13TH VERSION OF DRAWINGS	H. ZAREIEE	H. ZAREIEE	F. ESMAEILZADE H. REZAEIEE
11	04/11/2026	12TH VERSION OF DRAWINGS	H. ZAREIEE	H. ZAREIEE	F. ESMAEILZADE H. REZAEIEE
10	02/24/2026	11TH VERSION OF DRAWINGS	H. ZAREIEE	H. ZAREIEE	F. ESMAEILZADE H. REZAEIEE
09	02/07/2026	10TH VERSION OF DRAWINGS	H. ZAREIEE	H. ZAREIEE	F. ESMAEILZADE H. REZAEIEE
08	01/25/2026	9TH VERSION OF DRAWINGS	H. ZAREIEE	H. ZAREIEE	F. ESMAEILZADE H. REZAEIEE
07	01/14/2026	8TH VERSION OF DRAWINGS	H. ZAREIEE	H. ZAREIEE	F. ESMAEILZADE H. REZAEIEE
06	01/10/2026	7TH VERSION OF DRAWINGS	H. ZAREIEE	H. ZAREIEE	F. ESMAEILZADE H. REZAEIEE
05	12/28/2025	6TH VERSION OF DRAWINGS	H. ZAREIEE	H. ZAREIEE	F. ESMAEILZADE H. REZAEIEE
04	12/03/2025	5TH VERSION OF DRAWINGS	H. ZAREIEE	H. ZAREIEE	F. ESMAEILZADE H. REZAEIEE
03	11/16/2025	4TH VERSION OF DRAWINGS	H. ZAREIEE	H. ZAREIEE	F. ESMAEILZADE H. REZAEIEE
02	10/16/2025	3TH VERSION OF DRAWINGS	H. ZAREIEE	H. ZAREIEE	F. ESMAEILZADE H. REZAEIEE
01	08/17/2025	SECOND VERSION OF DRAWINGS	H. ZAREIEE	H. ZAREIEE	F. ESMAEILZADE H. REZAEIEE
00	07/19/2025	FIRST VERSION OF DRAWINGS	H. ZAREIEE	H. ZAREIEE	F. ESMAEILZADE H. REZAEIEE
REV.	DATE	DESCRIPTION	DESIGN	DRAWN	CHECKED APPROVED
Client:			Consultant:		
					
			Contractor:		Sub Contractor:
					
Project: 100MW Solar Power Plant (SARCHESHME)					
Title: Structure Shop Drawing					
DOC NO.:		28P2-B-3MG-DWC-SOL-000000-ST-330			REV. 14
SCALE		SIZE	SHEET		FORMAT
FIT		A3	19/26		DWC
10		11		12	

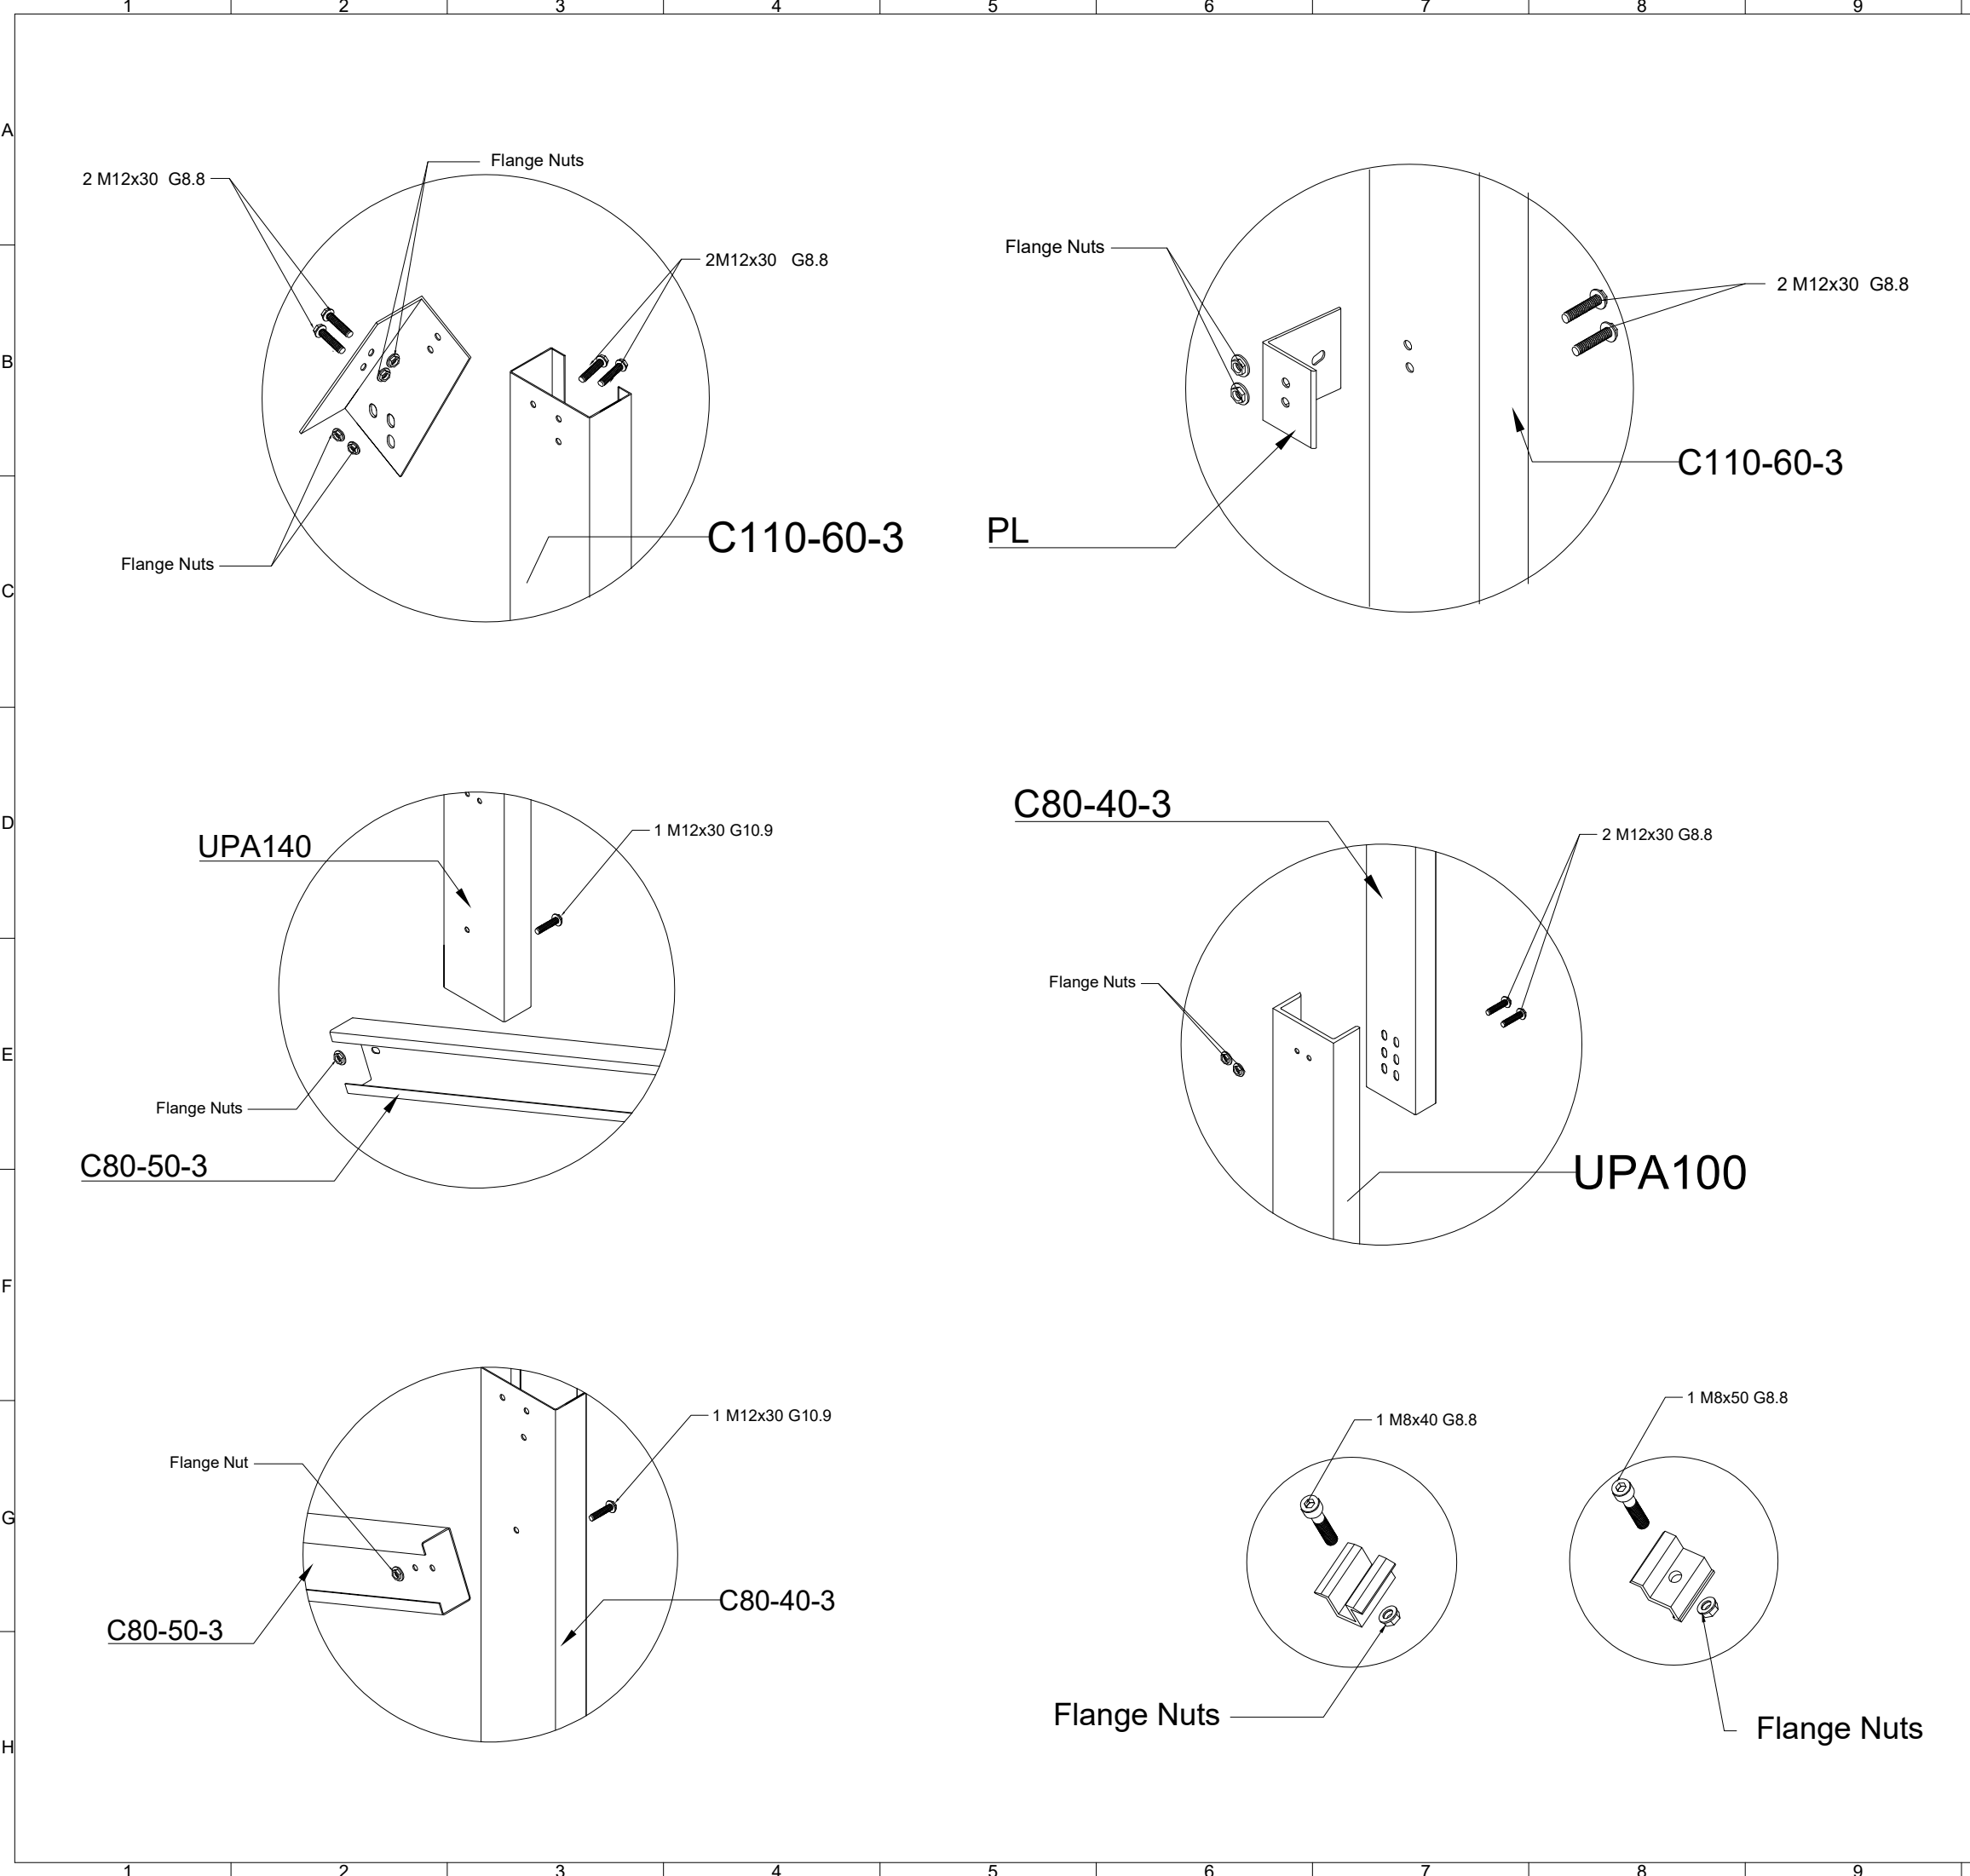


10		11		12		
REFERENCE						
REFERENCE.TITLE			REFERENCE.NO .			
NOTES						
ALL DIMENSIONS ARE IN mm.						
LEGEND						
KEY PLAN						
14	06/10/2026	15TH VERSION OF DRAWINGS	H ZAREIEE	H ZAREIEE	F. ESMAEILZADE	H. REZAEIEE
13	05/24/2026	14TH VERSION OF DRAWINGS	H ZAREIEE	H ZAREIEE	F. ESMAEILZADE	H. REZAEIEE
12	04/29/2026	13TH VERSION OF DRAWINGS	H ZAREIEE	H ZAREIEE	F. ESMAEILZADE	H. REZAEIEE
11	04/11/2026	12TH VERSION OF DRAWINGS	H ZAREIEE	H ZAREIEE	F. ESMAEILZADE	H. REZAEIEE
10	02/24/2026	11TH VERSION OF DRAWINGS	H ZAREIEE	H ZAREIEE	F. ESMAEILZADE	H. REZAEIEE
09	02/07/2026	10TH VERSION OF DRAWINGS	H ZAREIEE	H ZAREIEE	F. ESMAEILZADE	H. REZAEIEE
08	01/25/2026	9TH VERSION OF DRAWINGS	H ZAREIEE	H ZAREIEE	F. ESMAEILZADE	H. REZAEIEE
07	01/14/2026	8TH VERSION OF DRAWINGS	H ZAREIEE	H ZAREIEE	F. ESMAEILZADE	H. REZAEIEE
06	01/10/2026	7TH VERSION OF DRAWINGS	H ZAREIEE	H ZAREIEE	F. ESMAEILZADE	H. REZAEIEE
05	12/28/2025	6TH VERSION OF DRAWINGS	H ZAREIEE	H ZAREIEE	F. ESMAEILZADE	H. REZAEIEE
04	12/03/2025	5TH VERSION OF DRAWINGS	H ZAREIEE	H ZAREIEE	F. ESMAEILZADE	H. REZAEIEE
03	11/16/2025	4TH VERSION OF DRAWINGS	H ZAREIEE	H ZAREIEE	F. ESMAEILZADE	H. REZAEIEE
02	10/16/2025	3TH VERSION OF DRAWINGS	H ZAREIEE	H ZAREIEE	F. ESMAEILZADE	H. REZAEIEE
01	08/17/2025	SECOND VERSION OF DRAWINGS	H ZAREIEE	H ZAREIEE	F. ESMAEILZADE	H. REZAEIEE
00	07/19/2025	FIRST VERSION OF DRAWINGS	H ZAREIEE	H ZAREIEE	F. ESMAEILZADE	H. REZAEIEE
REV.	DATE	DESCRIPTION	DESIGN	DRAWN	CHECKED	APPROVED
Client:			Consultant:			
 NICICO			 موندنکو ایران Monenco Iran			
			Contractor:		Sub Contractor:	
			 گروه مهام شرق			
Project: 100MW Solar Power Plant (SARCHESHME)						
Title: Structure Installation Instructions						
DOC NO.:		28P2-B-3MG-DWG-SOL-000000-ST-330				REV. 14
SCALE		SIZE		SHEET		FORMAT
FIT		A3		20/26		DWG
10		11		12		

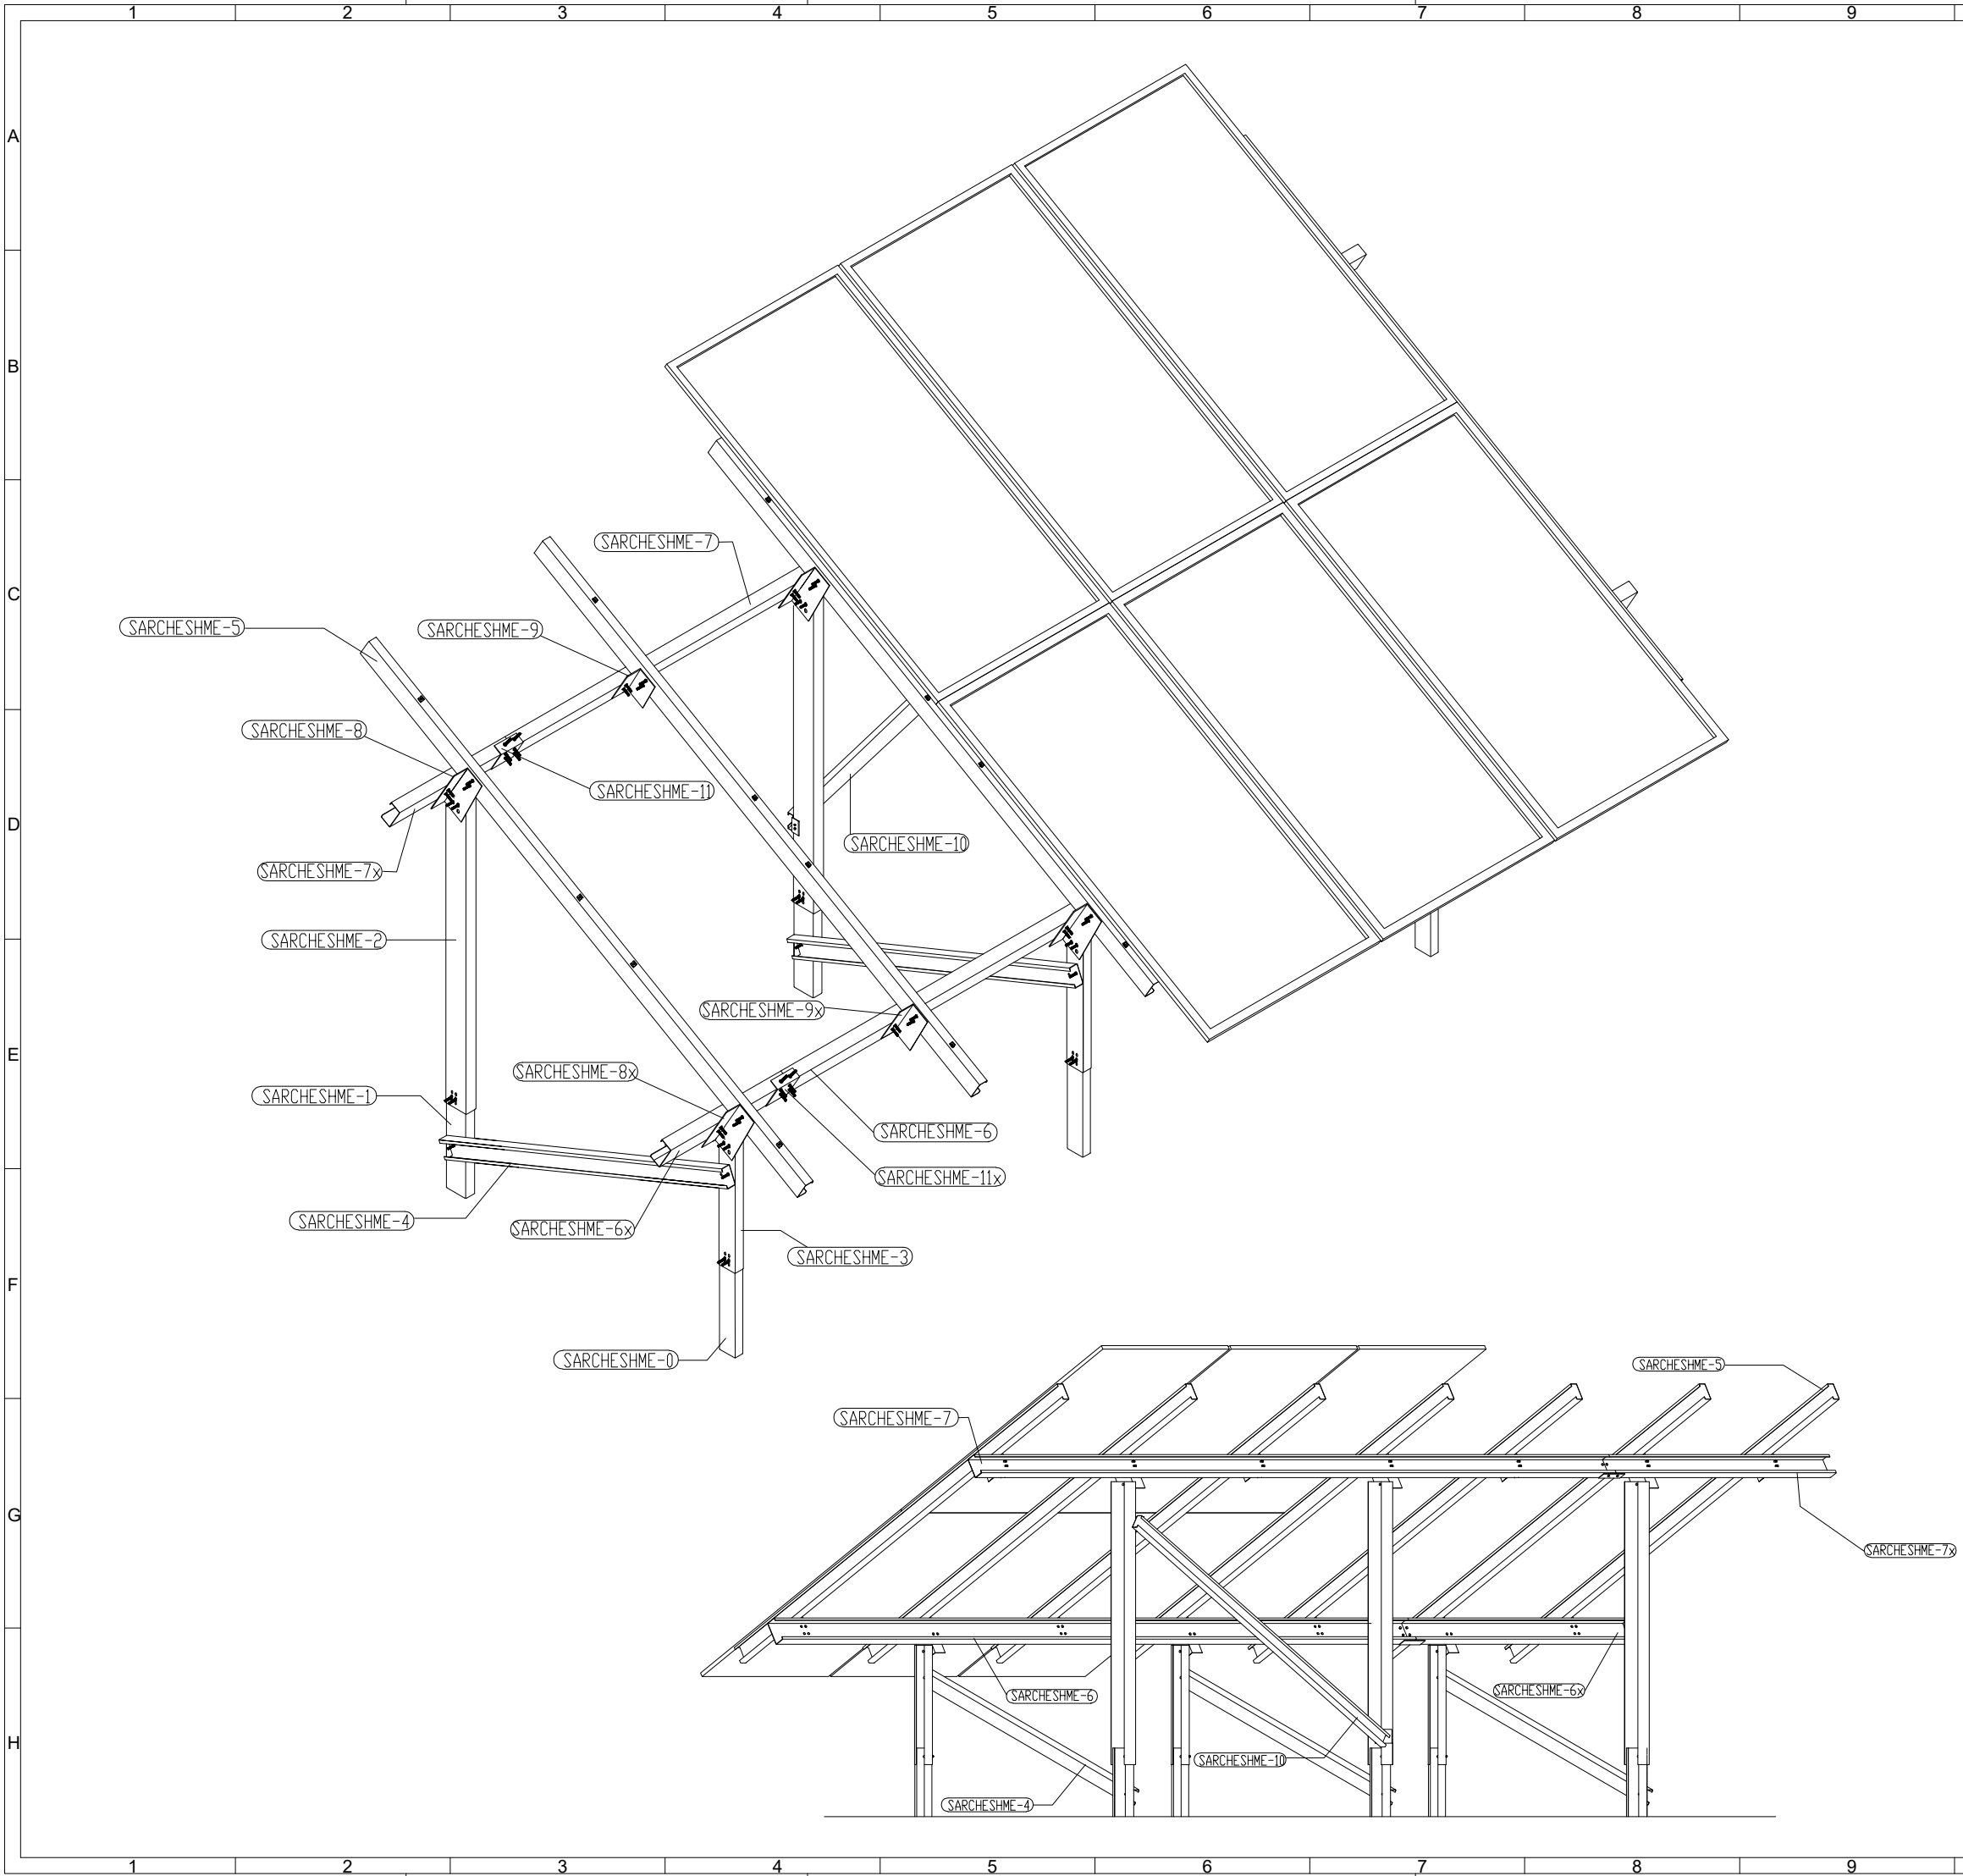

10		11		12	
REFERENCE					
REFERENCE.TITLE			REFERENCE.NO .		
NOTES					
ALL DIMENSIONS ARE IN mm.					
LEGEND					
KEY PLAN					
14	06/10/2026	15TH VERSION OF DRAWINGS	H ZAREIEE	H ZAREIEE	F. ESMAEILZADE H. REZAEIE
13	05/24/2026	14TH VERSION OF DRAWINGS	H ZAREIEE	H ZAREIEE	F. ESMAEILZADE H. REZAEIE
12	04/29/2026	13TH VERSION OF DRAWINGS	H ZAREIEE	H ZAREIEE	F. ESMAEILZADE H. REZAEIE
11	04/11/2026	12TH VERSION OF DRAWINGS	H ZAREIEE	H ZAREIEE	F. ESMAEILZADE H. REZAEIE
10	02/24/2026	11TH VERSION OF DRAWINGS	H ZAREIEE	H ZAREIEE	F. ESMAEILZADE H. REZAEIE
09	02/07/2026	10TH VERSION OF DRAWINGS	H ZAREIEE	H ZAREIEE	F. ESMAEILZADE H. REZAEIE
08	01/25/2026	9TH VERSION OF DRAWINGS	H ZAREIEE	H ZAREIEE	F. ESMAEILZADE H. REZAEIE
07	01/14/2026	8TH VERSION OF DRAWINGS	H ZAREIEE	H ZAREIEE	F. ESMAEILZADE H. REZAEIE
06	01/10/2026	7TH VERSION OF DRAWINGS	H ZAREIEE	H ZAREIEE	F. ESMAEILZADE H. REZAEIE
05	12/28/2025	6TH VERSION OF DRAWINGS	H ZAREIEE	H ZAREIEE	F. ESMAEILZADE H. REZAEIE
04	12/03/2025	5TH VERSION OF DRAWINGS	H ZAREIEE	H ZAREIEE	F. ESMAEILZADE H. REZAEIE
03	11/16/2025	4TH VERSION OF DRAWINGS	H ZAREIEE	H ZAREIEE	F. ESMAEILZADE H. REZAEIE
02	10/16/2025	3TH VERSION OF DRAWINGS	H ZAREIEE	H ZAREIEE	F. ESMAEILZADE H. REZAEIE
01	08/17/2025	SECOND VERSION OF DRAWINGS	H ZAREIEE	H ZAREIEE	F. ESMAEILZADE H. REZAEIE
00	07/19/2025	FIRST VERSION OF DRAWINGS	H ZAREIEE	H ZAREIEE	F. ESMAEILZADE H. REZAEIE
REV.	DATE	DESCRIPTION	DESIGN	DRAWN	CHECKED APPROVED
Client:			Consultant:		
					
			Contractor:		Sub Contractor:
					
Project: 100MW Solar Power Plant (SARCHESHME)					
Title: Structure & Mounting System MTO					
DOC NO.:		28P2-B-3MG-DWC-SOL-000000-ST-330			REV. 14
SCALE		SIZE	SHEET		FORMAT
FIT		A3	21 /26		DWG
10		11		12	


A										REFERENCE														
										REFERENCE.TITLE		REFERENCE.NO .												
B																								
C										NOTES														
										ALL DIMENSIONS ARE IN mm.														
D										LEGEND														
E										KEY PLAN														
F	14	06/10/2026	15TH VERSION OF DRAWINGS	H ZAREIEE	H ZAREIEE	F. ESMAEILZADE	H. REZAAIEE																	
	13	05/24/2026	14TH VERSION OF DRAWINGS	H ZAREIEE	H ZAREIEE	F. ESMAEILZADE	H. REZAAIEE																	
	12	04/29/2026	13TH VERSION OF DRAWINGS	H ZAREIEE	H ZAREIEE	F. ESMAEILZADE	H. REZAAIEE																	
G	11	04/11/2026	12TH VERSION OF DRAWINGS	H ZAREIEE	H ZAREIEE	F. ESMAEILZADE	H. REZAAIEE																	
	10	02/24/2026	11TH VERSION OF DRAWINGS	H ZAREIEE	H ZAREIEE	F. ESMAEILZADE	H. REZAAIEE																	
	09	02/07/2026	10TH VERSION OF DRAWINGS	H ZAREIEE	H ZAREIEE	F. ESMAEILZADE	H. REZAAIEE																	
H	08	01/25/2026	9TH VERSION OF DRAWINGS	H ZAREIEE	H ZAREIEE	F. ESMAEILZADE	H. REZAAIEE																	
	07	01/14/2026	8TH VERSION OF DRAWINGS	H ZAREIEE	H ZAREIEE	F. ESMAEILZADE	H. REZAAIEE																	
	06	01/10/2026	7TH VERSION OF DRAWINGS	H ZAREIEE	H ZAREIEE	F. ESMAEILZADE	H. REZAAIEE																	
	05	12/28/2025	6TH VERSION OF DRAWINGS	H ZAREIEE	H ZAREIEE	F. ESMAEILZADE	H. REZAAIEE																	
	04	12/03/2025	5TH VERSION OF DRAWINGS	H ZAREIEE	H ZAREIEE	F. ESMAEILZADE	H. REZAAIEE																	
	03	11/16/2025	4TH VERSION OF DRAWINGS	H ZAREIEE	H ZAREIEE	F. ESMAEILZADE	H. REZAAIEE																	
	02	10/16/2025	3TH VERSION OF DRAWINGS	H ZAREIEE	H ZAREIEE	F. ESMAEILZADE	H. REZAAIEE																	
	01	08/17/2025	SECOND VERSION OF DRAWINGS	H ZAREIEE	H ZAREIEE	F. ESMAEILZADE	H. REZAAIEE																	
	00	07/19/2025	FIRST VERSION OF DRAWINGS	H ZAREIEE	H ZAREIEE	F. ESMAEILZADE	H. REZAAIEE																	
REV. DATE				DESCRIPTION		DESIGN	DRAWN	CHECKED	APPROVED															
Client:						Consultant:																		
 						 مونتکو ایران Monenco Iran																		
						Contractor:  گروه مهام شرق																		
						Sub Contractor:																		
Project: 100MW Solar Power Plant (SARCHESHME)																								
Title: Structure & Mounting System MT0																								
DOC NO.:		28P2-B-3MG-DWG-SOL-000000-ST-330									REV.													
											14													
SCALE			SIZE			SHEET			FORMAT															
FIT			A3			22/26			DWG															

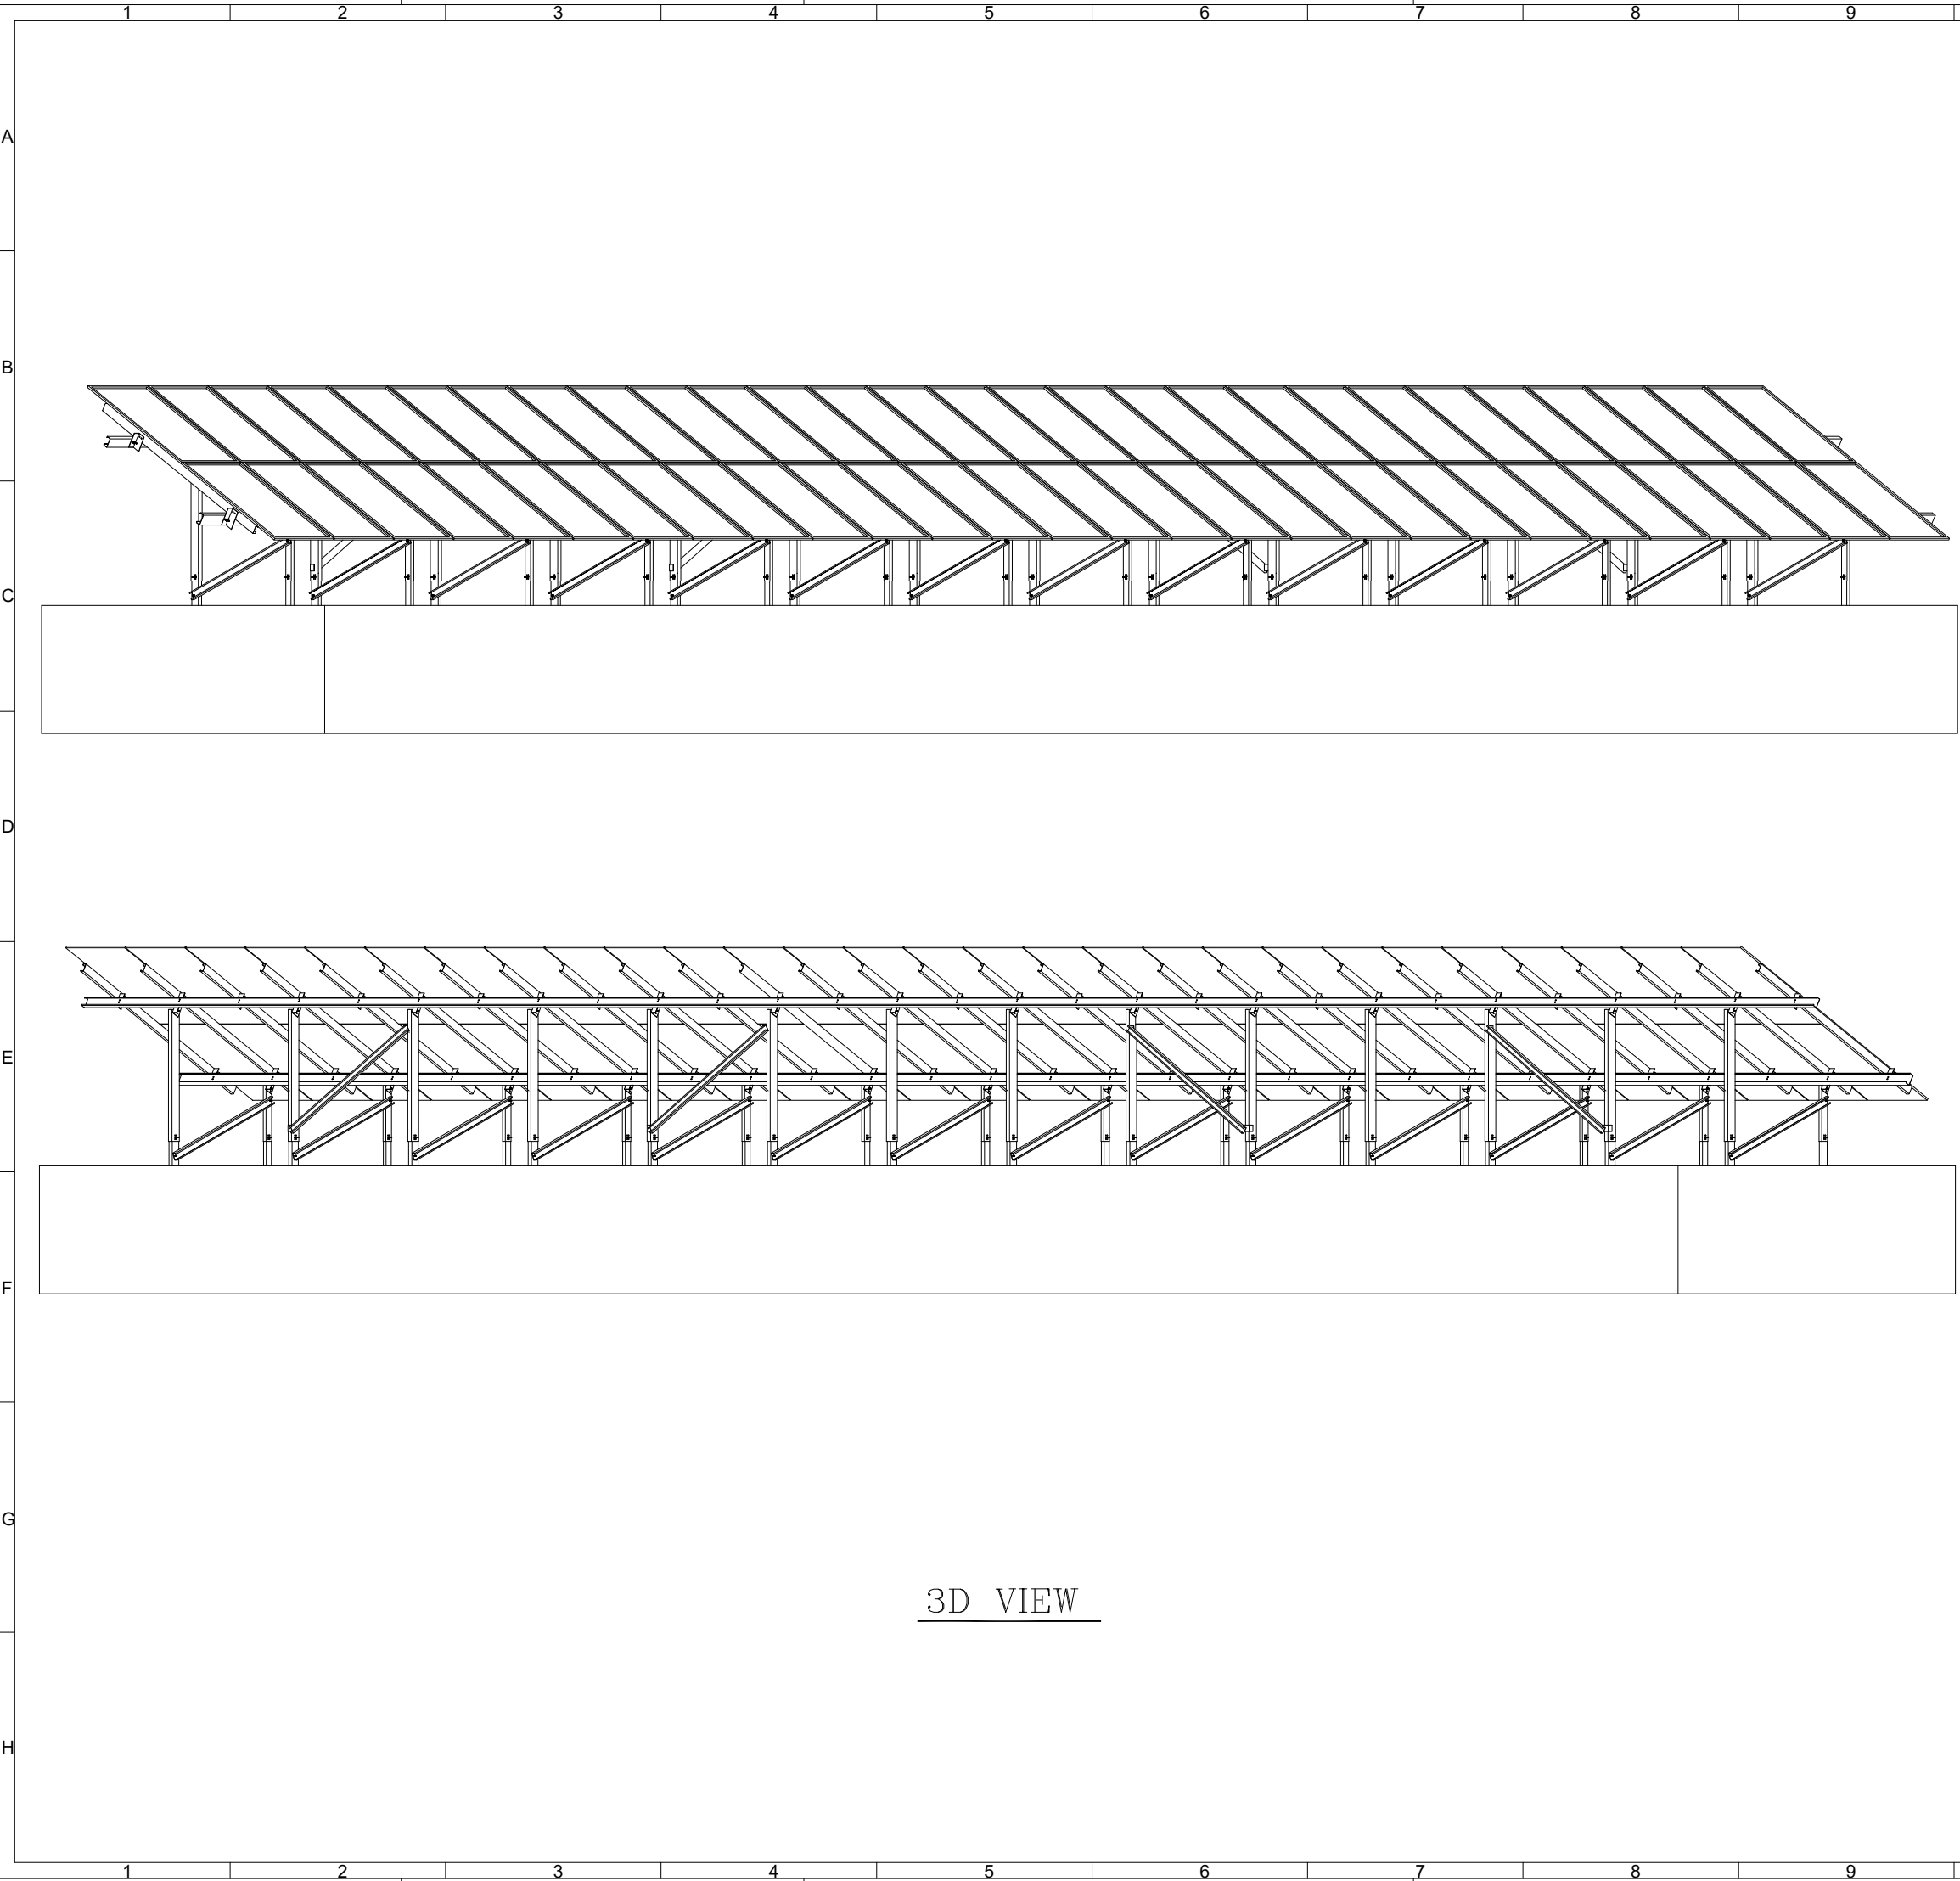


10		11		12		
REFERENCE						
REFERENCE.TITLE			REFERENCE.NO .			
NOTES						
ALL DIMENSIONS ARE IN mm.						
LEGEND						
KEY PLAN						
14	06/10/2026	15TH VERSION OF DRAWINGS	H ZAREIEE	H ZAREIEE	F. ESMAEILZADE	H. REZAAIEE
13	05/24/2026	14TH VERSION OF DRAWINGS	H ZAREIEE	H ZAREIEE	F. ESMAEILZADE	H. REZAAIEE
12	04/29/2026	13TH VERSION OF DRAWINGS	H ZAREIEE	H ZAREIEE	F. ESMAEILZADE	H. REZAAIEE
11	04/11/2026	12TH VERSION OF DRAWINGS	H ZAREIEE	H ZAREIEE	F. ESMAEILZADE	H. REZAAIEE
10	02/24/2026	11TH VERSION OF DRAWINGS	H ZAREIEE	H ZAREIEE	F. ESMAEILZADE	H. REZAAIEE
09	02/07/2026	10TH VERSION OF DRAWINGS	H ZAREIEE	H ZAREIEE	F. ESMAEILZADE	H. REZAAIEE
08	01/25/2026	9TH VERSION OF DRAWINGS	H ZAREIEE	H ZAREIEE	F. ESMAEILZADE	H. REZAAIEE
07	01/14/2026	8TH VERSION OF DRAWINGS	H ZAREIEE	H ZAREIEE	F. ESMAEILZADE	H. REZAAIEE
06	01/10/2026	7TH VERSION OF DRAWINGS	H ZAREIEE	H ZAREIEE	F. ESMAEILZADE	H. REZAAIEE
05	12/28/2025	6TH VERSION OF DRAWINGS	H ZAREIEE	H ZAREIEE	F. ESMAEILZADE	H. REZAAIEE
04	12/03/2025	5TH VERSION OF DRAWINGS	H ZAREIEE	H ZAREIEE	F. ESMAEILZADE	H. REZAAIEE
03	11/16/2025	4TH VERSION OF DRAWINGS	H ZAREIEE	H ZAREIEE	F. ESMAEILZADE	H. REZAAIEE
02	10/16/2025	3TH VERSION OF DRAWINGS	H ZAREIEE	H ZAREIEE	F. ESMAEILZADE	H. REZAAIEE
01	08/17/2025	SECOND VERSION OF DRAWINGS	H ZAREIEE	H ZAREIEE	F. ESMAEILZADE	H. REZAAIEE
00	07/19/2025	FIRST VERSION OF DRAWINGS	H ZAREIEE	H ZAREIEE	F. ESMAEILZADE	H. REZAAIEE
REV.	DATE	DESCRIPTION	DESIGN	DRAWN	CHECKED	APPROVED
Client:			Consultant:			
						
						
			Contractor:		Sub Contractor:	
						
Project: 100MW Solar Power Plant (SARCHESHME)						
Title: 3D VIEW						
DOC NO.:		28P2-B-3MG-DWG-SOL-000000-ST-330				REV. 14
SCALE		SIZE		SHEET		FORMAT
FIT		A3		23/26		DWG
10		11		12		



A
B
C
D
E
F
G
H

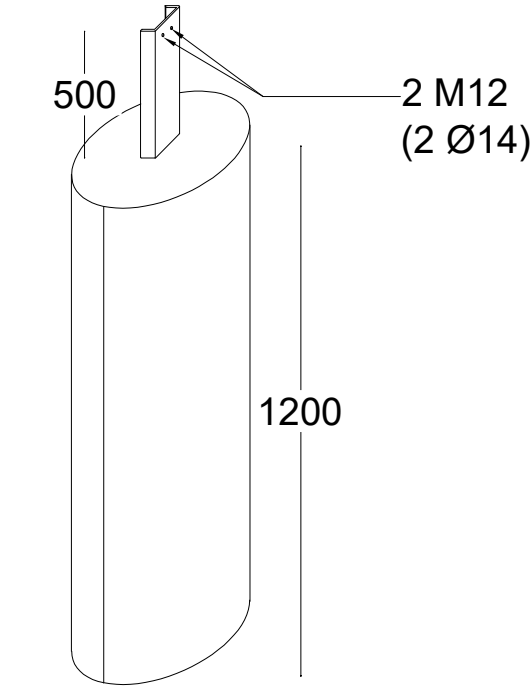


3D view

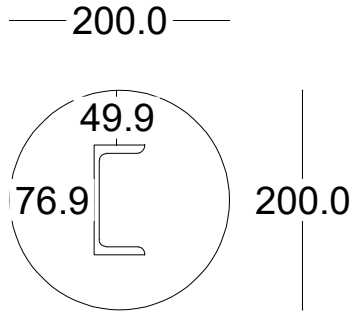

UPA100

Plan view

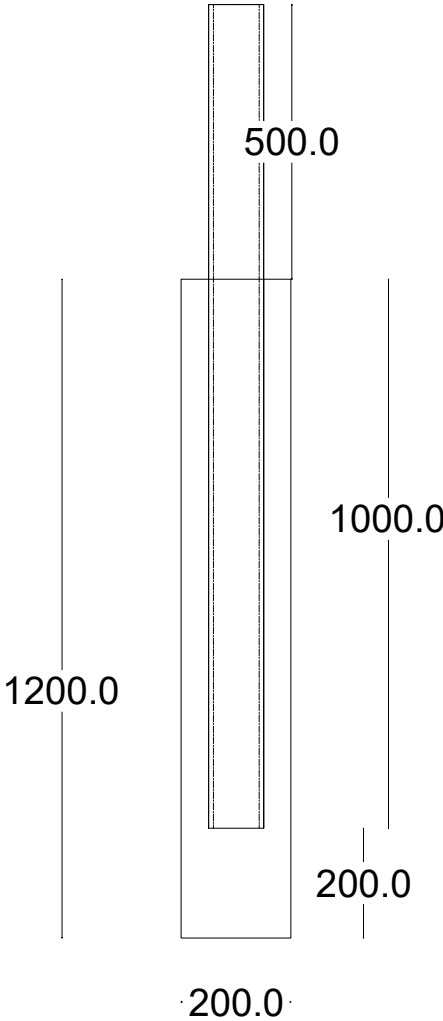


$f_c = 30 \text{ MPa}$,
Cement type: II, $W/C < 0.50$

Side view


Concret Foundation for UPA100
F1 Type

REFERENCE						
REFERENCE.TITLE			REFERENCE.NO .			
NOTES						
ALL DIMENSIONS ARE IN mm.						
LEGEND						
KEY PLAN						
14	06/10/2026	15TH VERSION OF DRAWINGS	H ZAREIEE	H ZAREIEE	F. ESMAEILZADE	H. REZAIEE
13	05/24/2026	14TH VERSION OF DRAWINGS	H ZAREIEE	H ZAREIEE	F. ESMAEILZADE	H. REZAIEE
12	04/29/2026	13TH VERSION OF DRAWINGS	H ZAREIEE	H ZAREIEE	F. ESMAEILZADE	H. REZAIEE
11	04/11/2026	12TH VERSION OF DRAWINGS	H ZAREIEE	H ZAREIEE	F. ESMAEILZADE	H. REZAIEE
10	02/24/2026	11TH VERSION OF DRAWINGS	H ZAREIEE	H ZAREIEE	F. ESMAEILZADE	H. REZAIEE
09	02/07/2026	10TH VERSION OF DRAWINGS	H ZAREIEE	H ZAREIEE	F. ESMAEILZADE	H. REZAIEE
08	01/25/2026	9TH VERSION OF DRAWINGS	H ZAREIEE	H ZAREIEE	F. ESMAEILZADE	H. REZAIEE
07	01/14/2026	8TH VERSION OF DRAWINGS	H ZAREIEE	H ZAREIEE	F. ESMAEILZADE	H. REZAIEE
06	01/10/2026	7TH VERSION OF DRAWINGS	H ZAREIEE	H ZAREIEE	F. ESMAEILZADE	H. REZAIEE
05	12/28/2025	6TH VERSION OF DRAWINGS	H ZAREIEE	H ZAREIEE	F. ESMAEILZADE	H. REZAIEE
04	12/03/2025	5TH VERSION OF DRAWINGS	H ZAREIEE	H ZAREIEE	F. ESMAEILZADE	H. REZAIEE
03	11/16/2025	4TH VERSION OF DRAWINGS	H ZAREIEE	H ZAREIEE	F. ESMAEILZADE	H. REZAIEE
02	10/16/2025	3TH VERSION OF DRAWINGS	H ZAREIEE	H ZAREIEE	F. ESMAEILZADE	H. REZAIEE
01	08/17/2025	SECOND VERSION OF DRAWINGS	H ZAREIEE	H ZAREIEE	F. ESMAEILZADE	H. REZAIEE
00	07/19/2025	FIRST VERSION OF DRAWINGS	H ZAREIEE	H ZAREIEE	F. ESMAEILZADE	H. REZAIEE
REV.	DATE	DESCRIPTION	DESIGN	DRAWN	CHECKED	APPROVED
Client:			Consultant:			
					 مونتکو ایران Monenco Iran	
			Contractor:		Sub Contractor:	
			 گروه مهام شرق			
Project: 100MW Solar Power Plant (SARCHESHME)						
Title: Foundation Details						
DOC NO.:		28P2-B-3MG-DWG-SOL-000000-ST-330				REV.
						14
SCALE		SIZE		SHEET		FORMAT
FIT		A3		25/26		DWG


A
B
C
D
E
F
G
H

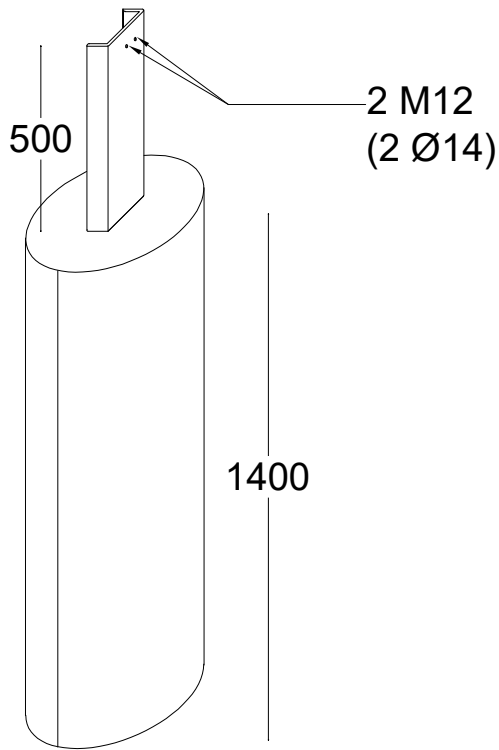

3D view

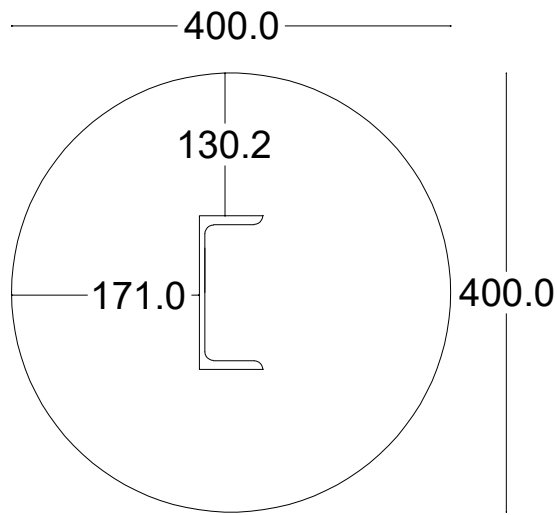

Plan view

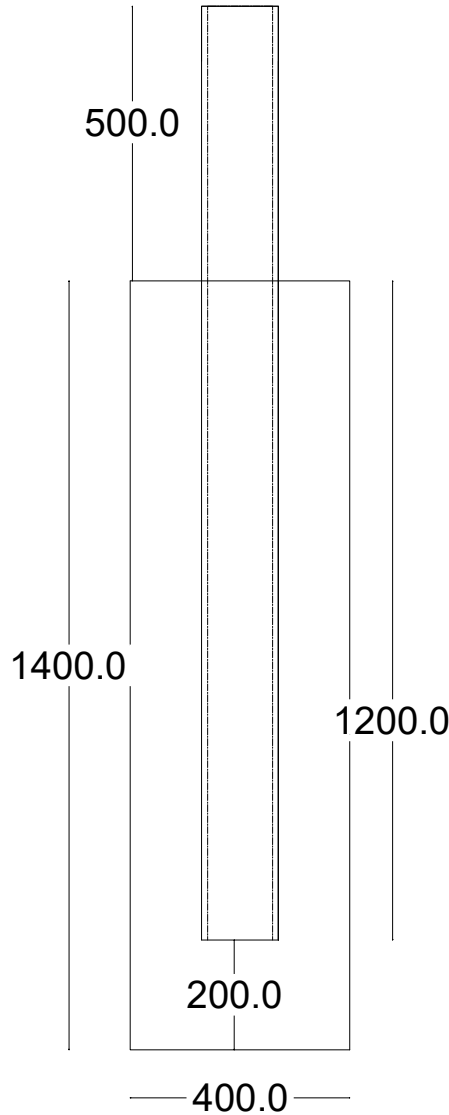

Side view

$f_c = 30 \text{ MPa}$,
Cement type: II, $W/C < 0.50$

Concret Foundation for UPA140
F2 Type

REFERENCE						
REFERENCE.TITLE			REFERENCE.NO .			
NOTES						
ALL DIMENSIONS ARE IN mm.						
LEGEND						
KEY PLAN						
14	06/10/2026	15TH VERSION OF DRAWINGS	H ZAREIEE	H ZAREIEE	F. ESMAEILZADE	H. REZAEIE
13	05/24/2026	14TH VERSION OF DRAWINGS	H ZAREIEE	H ZAREIEE	F. ESMAEILZADE	H. REZAEIE
12	04/29/2026	13TH VERSION OF DRAWINGS	H ZAREIEE	H ZAREIEE	F. ESMAEILZADE	H. REZAEIE
11	04/11/2026	12TH VERSION OF DRAWINGS	H ZAREIEE	H ZAREIEE	F. ESMAEILZADE	H. REZAEIE
10	02/24/2026	11TH VERSION OF DRAWINGS	H ZAREIEE	H ZAREIEE	F. ESMAEILZADE	H. REZAEIE
09	02/07/2026	10TH VERSION OF DRAWINGS	H ZAREIEE	H ZAREIEE	F. ESMAEILZADE	H. REZAEIE
08	01/25/2026	9TH VERSION OF DRAWINGS	H ZAREIEE	H ZAREIEE	F. ESMAEILZADE	H. REZAEIE
07	01/14/2026	8TH VERSION OF DRAWINGS	H ZAREIEE	H ZAREIEE	F. ESMAEILZADE	H. REZAEIE
06	01/10/2026	7TH VERSION OF DRAWINGS	H ZAREIEE	H ZAREIEE	F. ESMAEILZADE	H. REZAEIE
05	12/28/2025	6TH VERSION OF DRAWINGS	H ZAREIEE	H ZAREIEE	F. ESMAEILZADE	H. REZAEIE
04	12/03/2025	5TH VERSION OF DRAWINGS	H ZAREIEE	H ZAREIEE	F. ESMAEILZADE	H. REZAEIE
03	11/16/2025	4TH VERSION OF DRAWINGS	H ZAREIEE	H ZAREIEE	F. ESMAEILZADE	H. REZAEIE
02	10/16/2025	3TH VERSION OF DRAWINGS	H ZAREIEE	H ZAREIEE	F. ESMAEILZADE	H. REZAEIE
01	08/17/2025	SECOND VERSION OF DRAWINGS	H ZAREIEE	H ZAREIEE	F. ESMAEILZADE	H. REZAEIE
00	07/19/2025	FIRST VERSION OF DRAWINGS	H ZAREIEE	H ZAREIEE	F. ESMAEILZADE	H. REZAEIE
REV.	DATE	DESCRIPTION	DESIGN	DRAWN	CHECKED	APPROVED
Client:			Consultant:			
 جمهوری اسلامی ایران NICICO			 مونتکو ایران شرکت مهندسی و معماری		 مونتکو ایران Monenco Iran	
			Contractor:		Sub Contractor:	
			 گروه مهام شرقی			
Project: 100MW Solar Power Plant (SARCHESHME)						
Title: Foundation Details						
DOC NO.:		28P2-B-3MG-DWG-SOL-000000-ST-330				REV. 14
SCALE		SIZE	SHEET			FORMAT
FIT		A3	26/26			DWG

A
B
C
D
E
F
G
H