


BORDER		
Station	<i>x</i>	<i>y</i>
P1	764861.998	3575501.998
P2	764927.0	3575880
P3	765560.985	3575919.985
P4	765553.0	3575825

Legend		
	LVT	LV CABLE TRENCH
	DC & LV	DC and LV CABLE TRENCH
	MVT	MV CABLE TRENCH
	DCT1	DC CABLE TRENCH
	EARTH	EARTH CABLE TRENCH
	CCTV	CCTV CABLE TRENCH
	MONITORING	MONITORING CABLE TRENCH

Existing Works(5 MW)

BOUNDARY FENCE

EXIST ACCESS ROAD

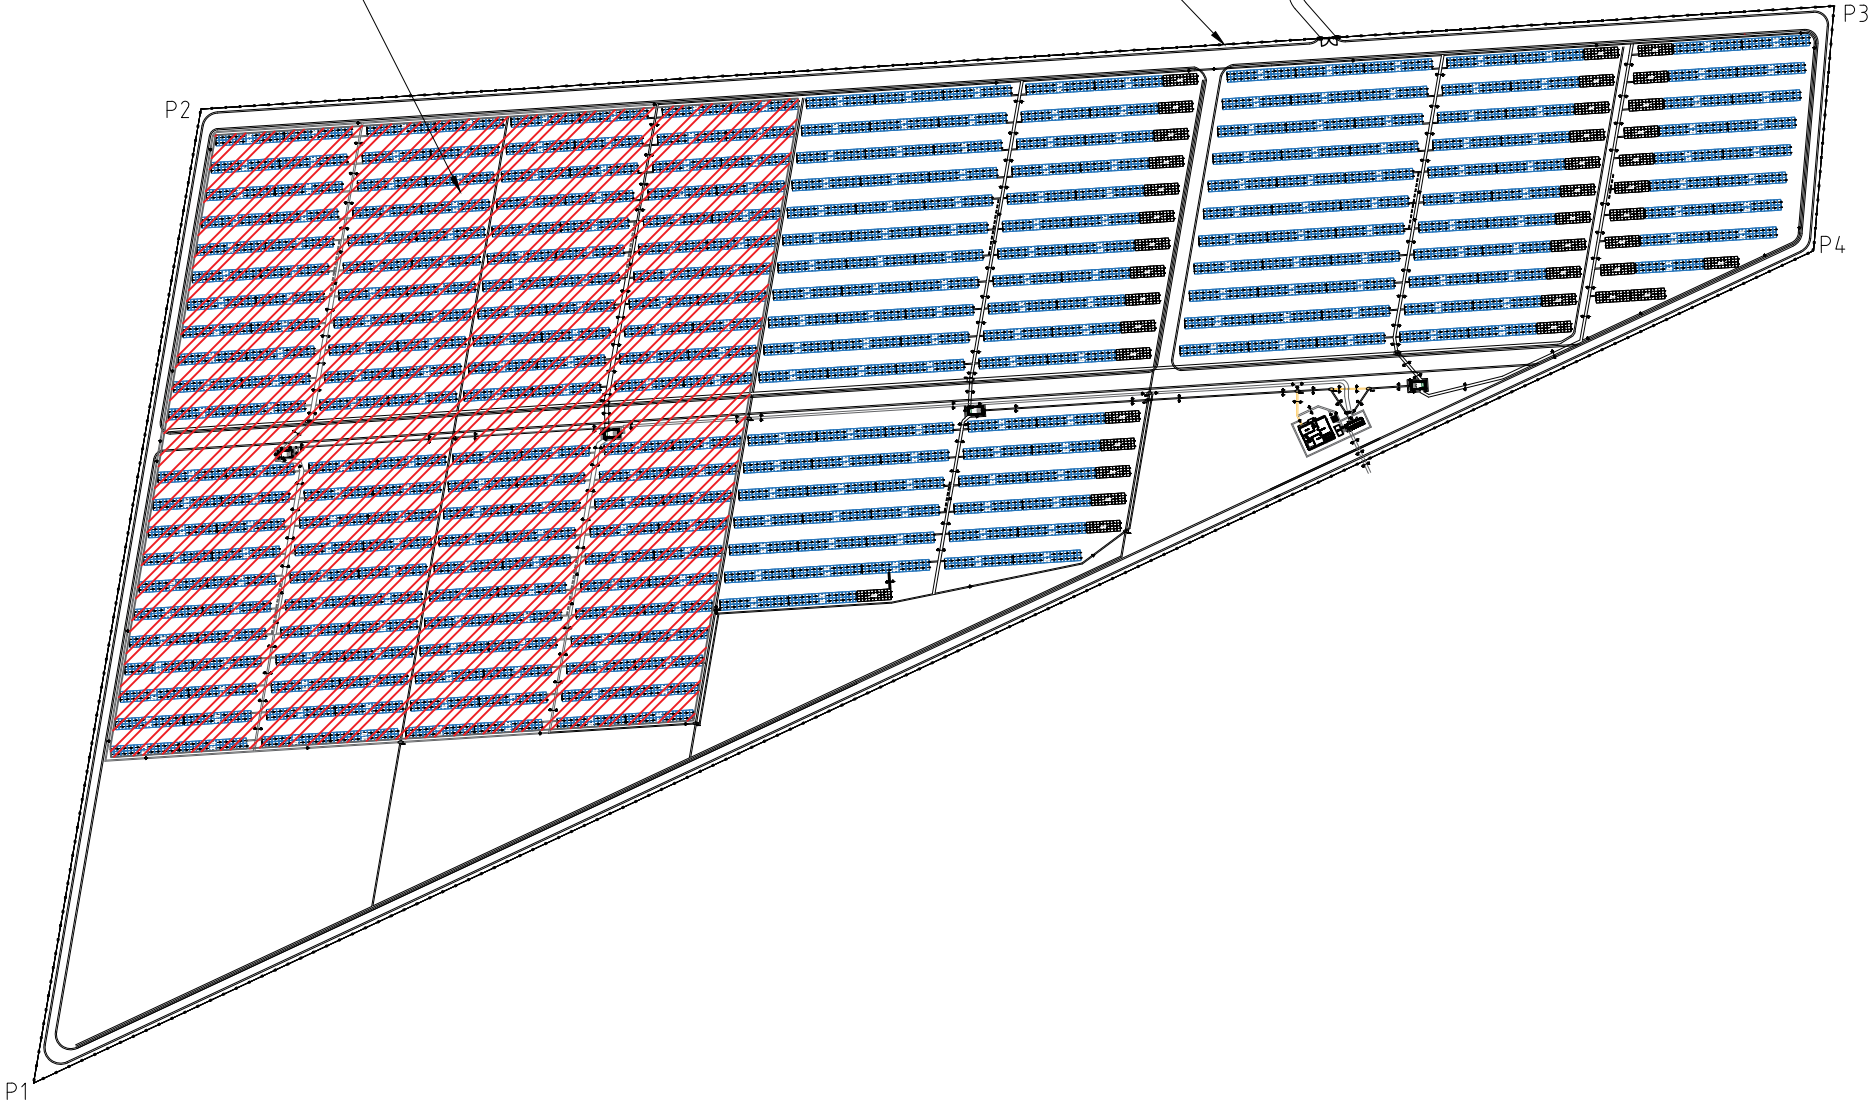

C			Consultant:	Employer:	Contractor:			Name	Date	Title:	Project:	Scale:
B								M. AMMARI	1404/08/01		NEHBANDAN 10MW	
A	Second ISSUE	1404/08/01						M. AMMARI	1404/08/01	TRENCH DETAIL AND	SOLAR POWER PLANET	Size:
Z	FIRST ISSUE	1404/05/05						M. DEHESTANI	1404/08/01	CABLE ROUTE		Sheet:
REV	Description.	DATE						M. DEHESTANI	1404/08/01	DWG NO:	Contract No: -----	Next: 01